


1 FLOOR PLAN  
A100 SCALE: N.T.S.

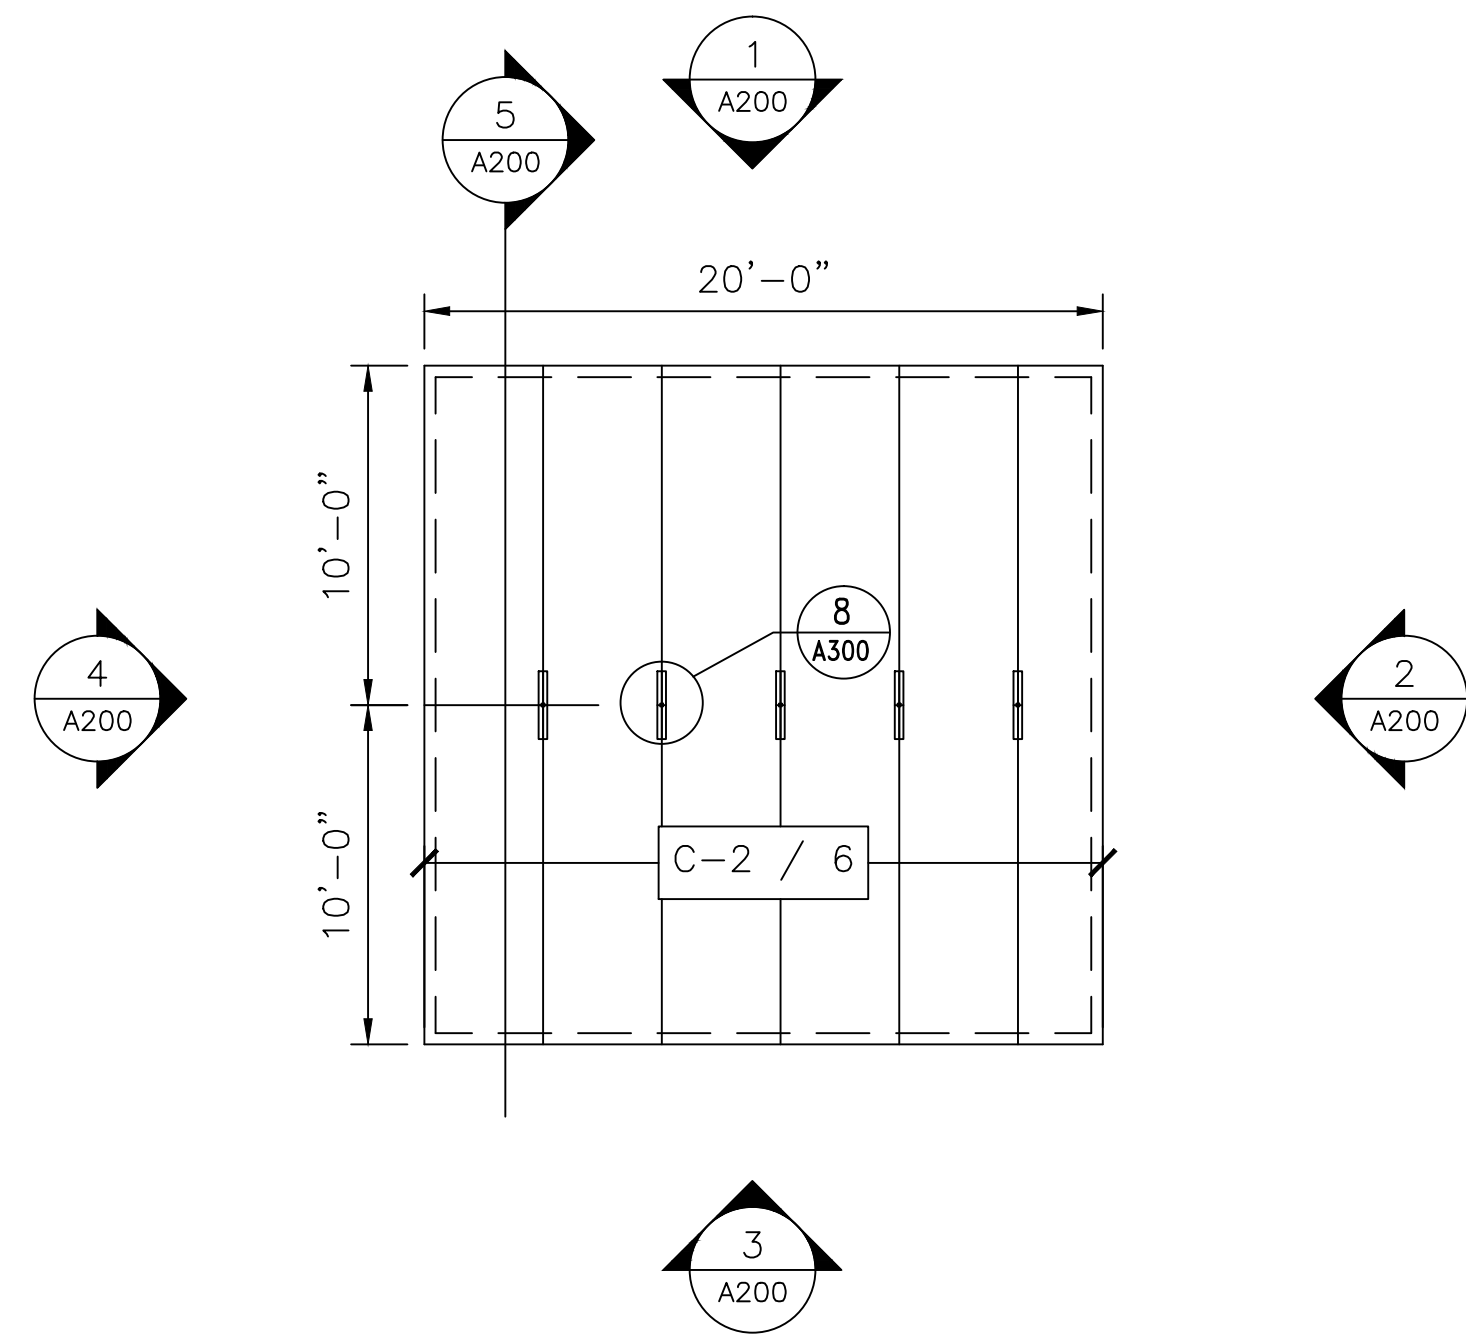

2 CEILING PLAN  
A100 SCALE: N.T.S.

PANEL SCHEDULE

PANEL DESIG.	PANEL HEIGHT	QTY OF PANELS	PANEL THICK	PANEL SERIES	PANEL COLOR
W-1	8'-0"	24	4"	MESALINE	USDA WHITE
C-2	20'-0"	6	4"	MESALINE	USDA WHITE

NO.	REVISION	BY	DATE

**Barr Inc.**  
1423 Planeview Drive  
Oshkosh, WI 54904  
920-231-1711 Phone






20' x 20' x 8'-4"  
Drive-In Cooler

TOLERANCES UNLESS SPECIFIED  
FRACTIONAL X/X" ± 1/32"  
DECIMAL .XX ± .015  
" X ± 0'30"  
ANGLE .XXX ± .005  
XXX' ± 0'05"  
XXXX ± .001

Draftsman is not responsible for panel heights, quantities and/or dimensions. Contractor to verify all information.

FLOOR PLAN







DR.BY: KRZ  
DATE: 8/30/2016  
SCALE: NTS  
CHECKED BY:  
SHEET NO. A100

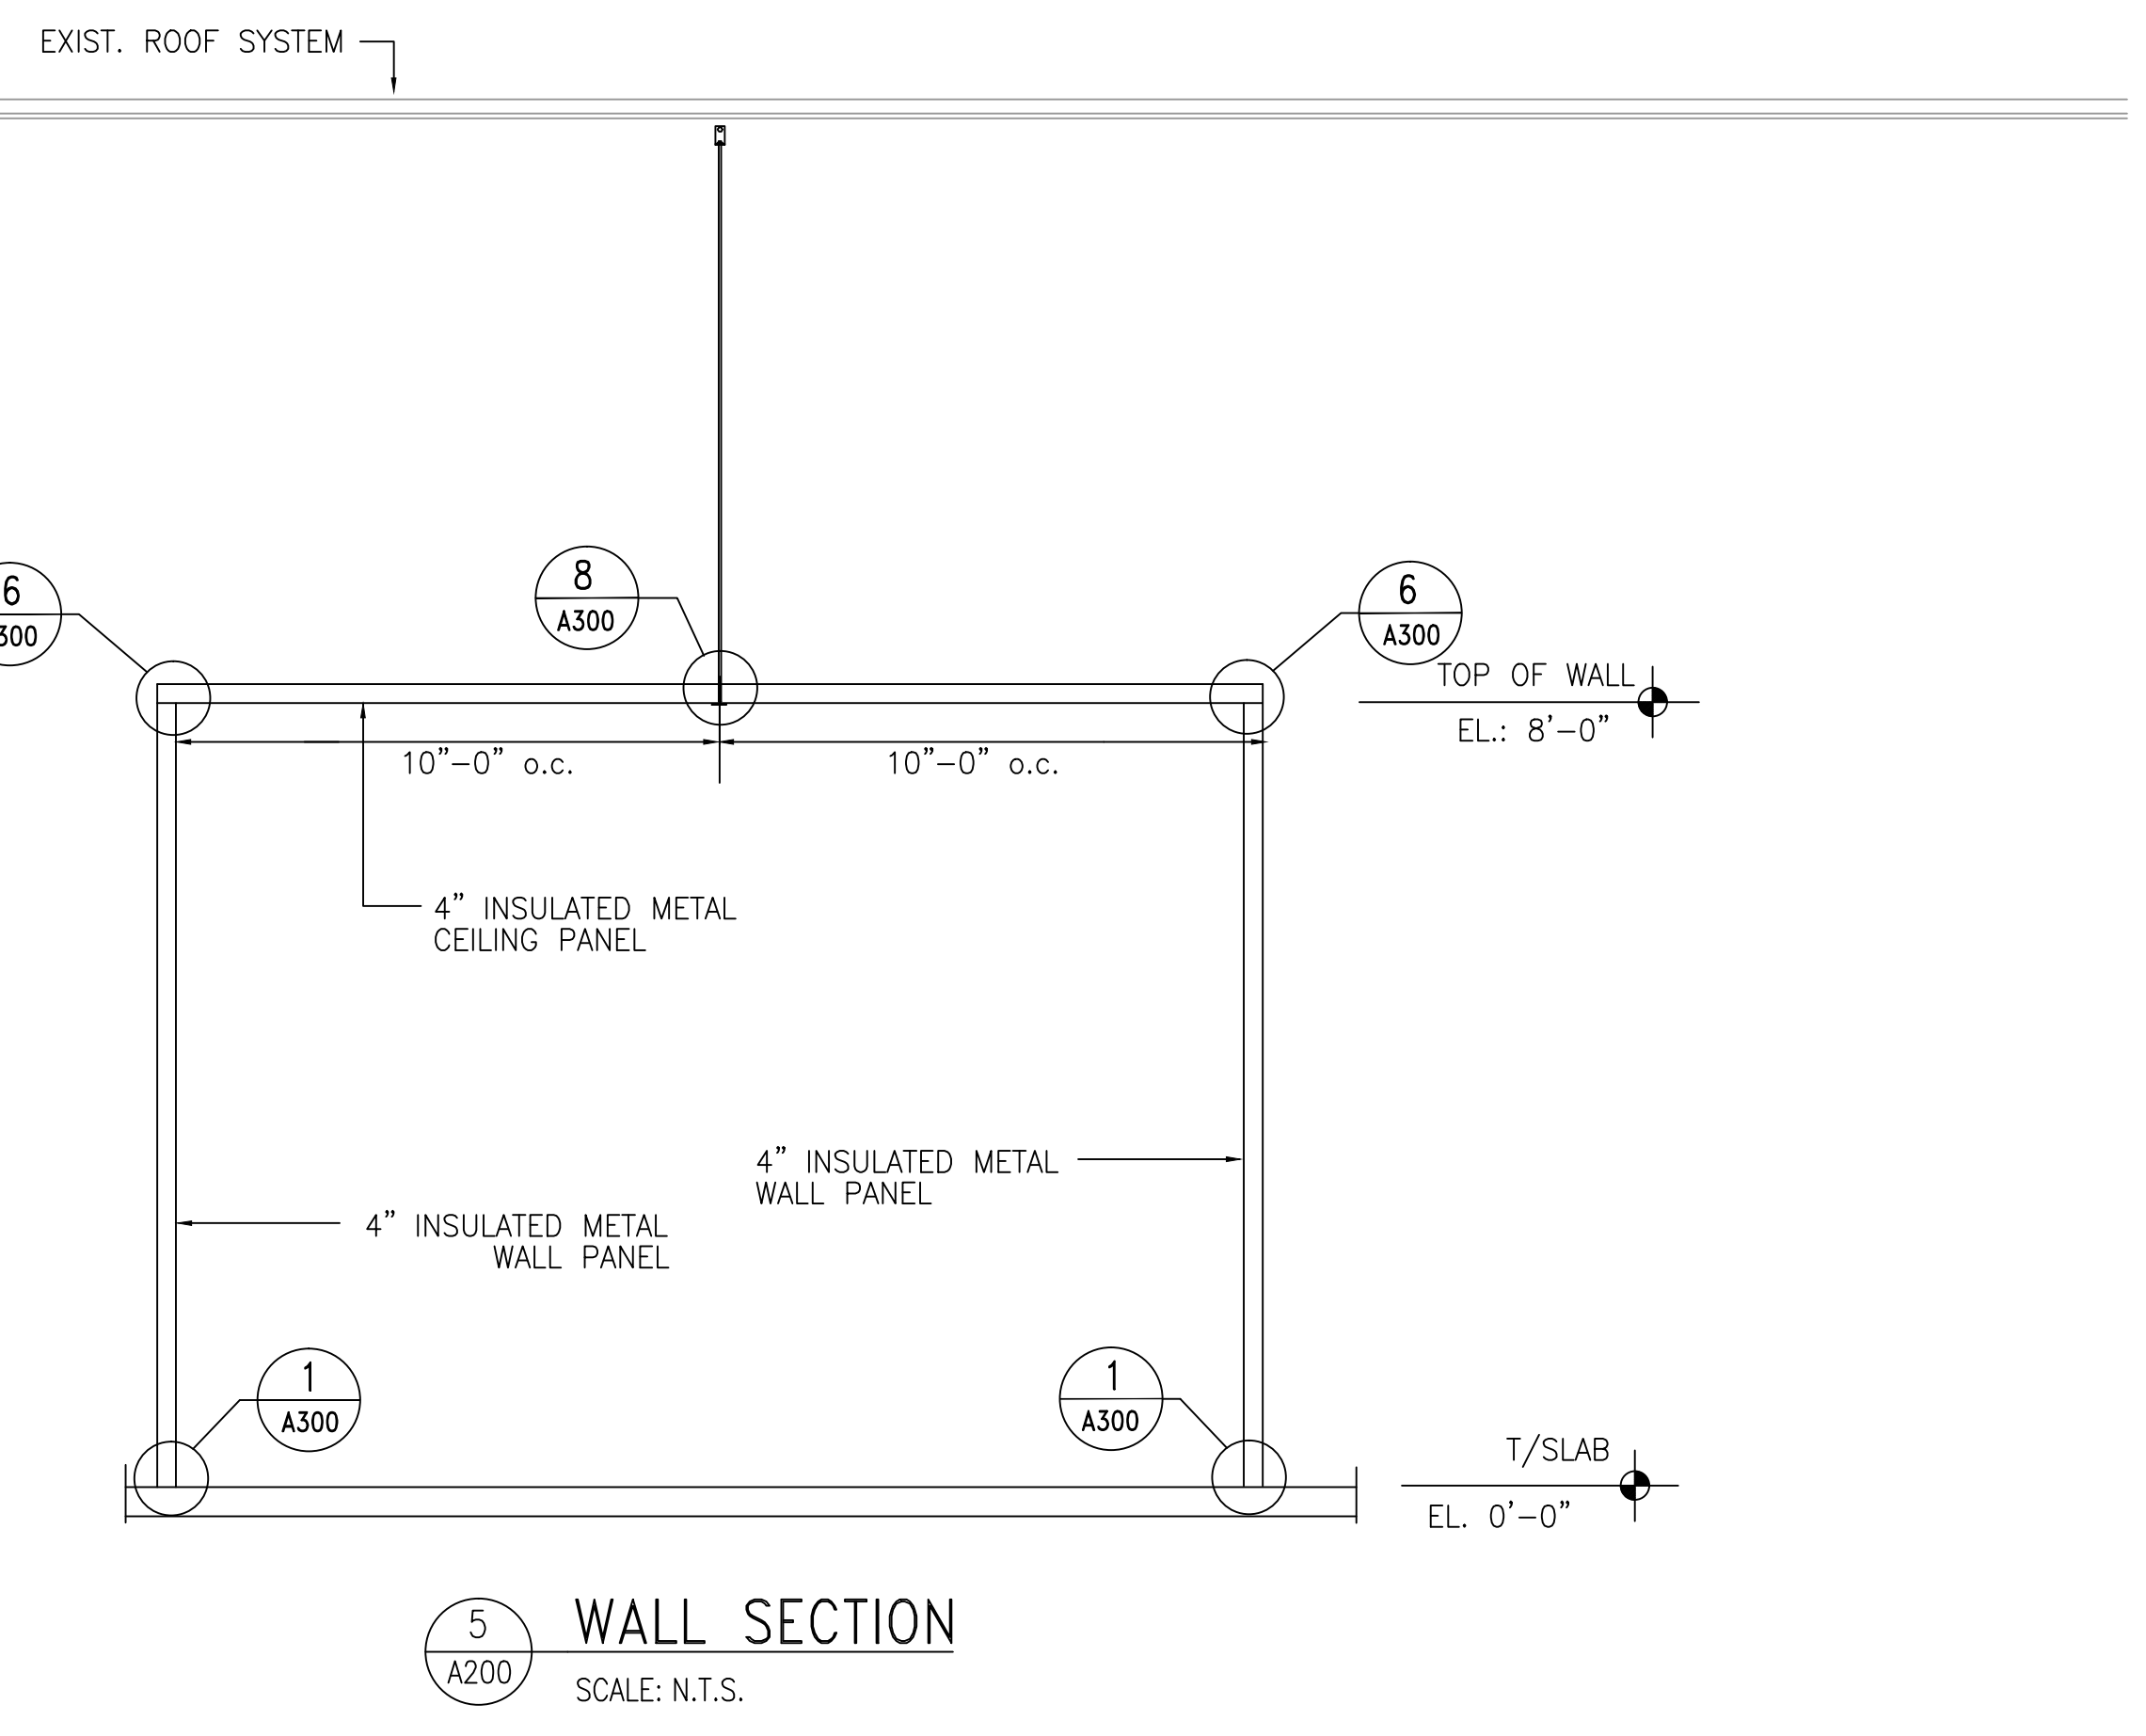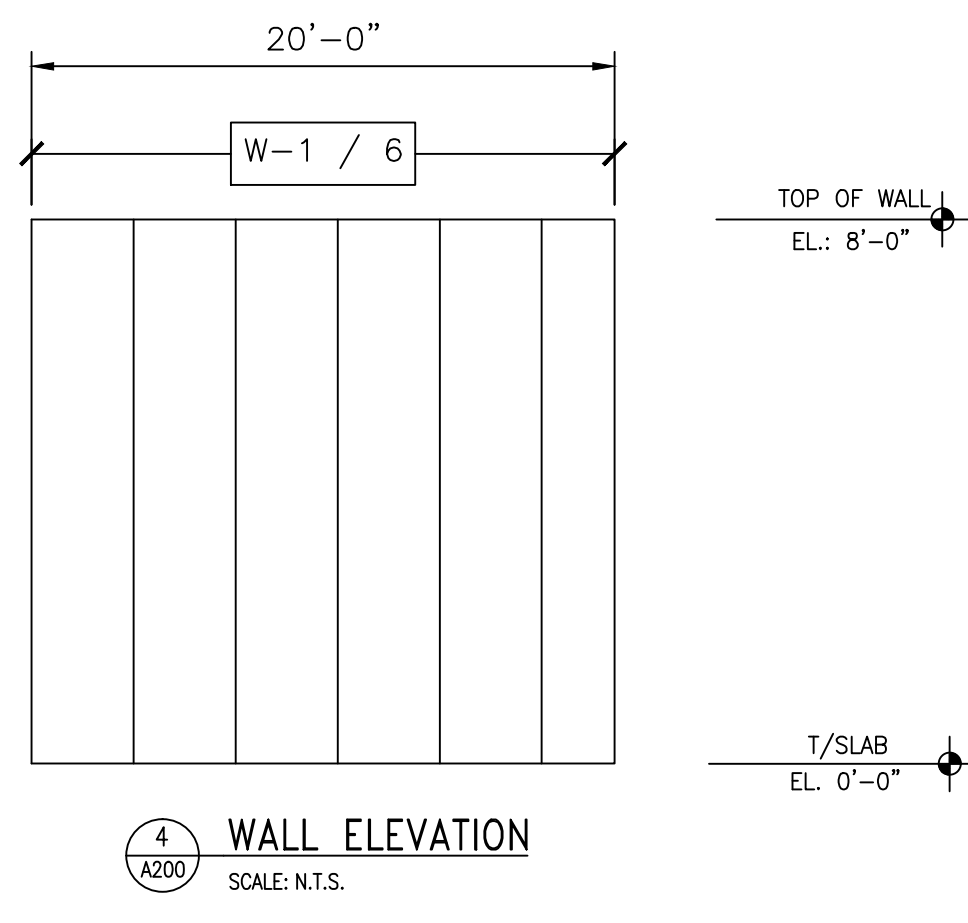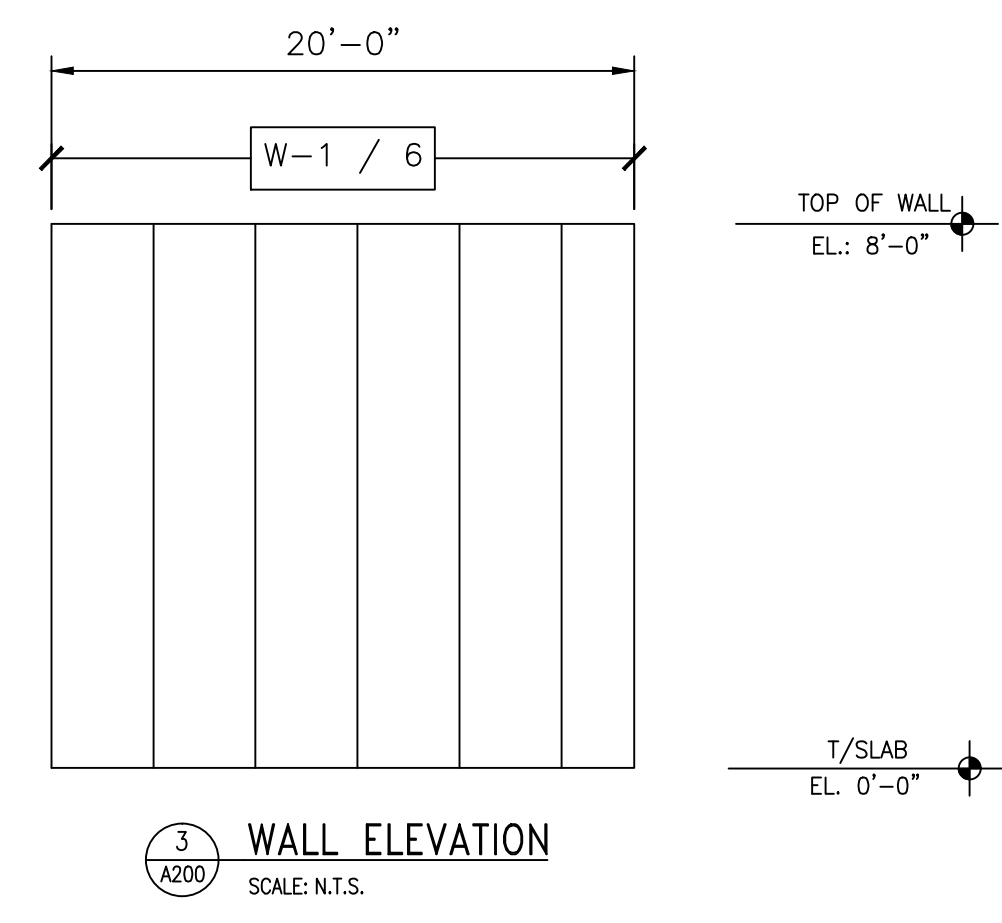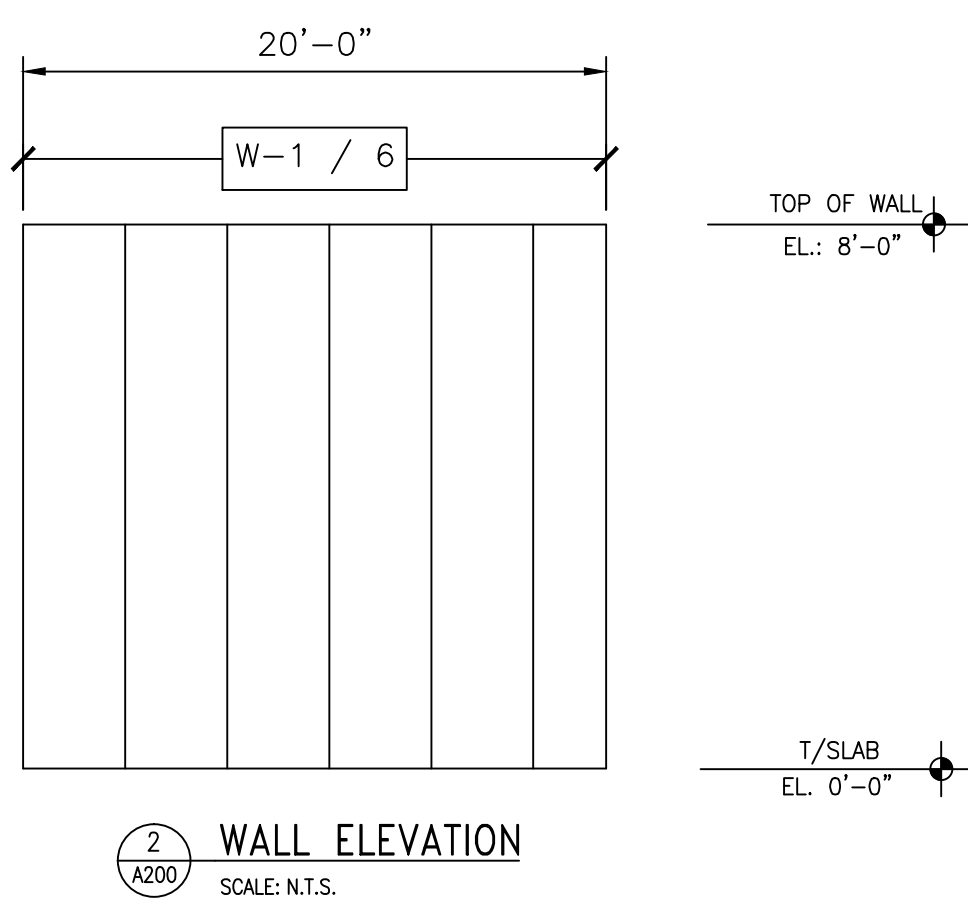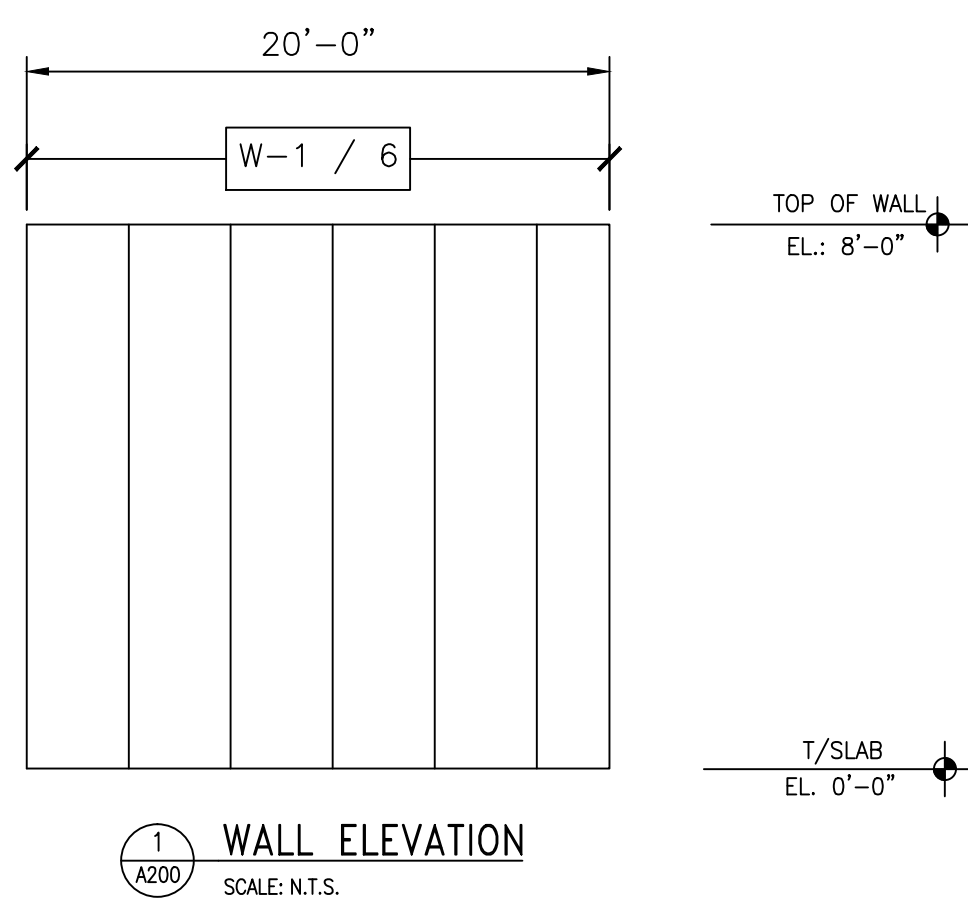


PANEL SCHEDULE

PANEL DESIG.	PANEL HEIGHT	QTY. OF PANELS	PANEL THICK	PANEL SERIES	PANEL COLOR
W-1	8'-0"	24	4"	MESALINE	USDA WHITE
C-2	20'-0"	6	4"	MESALINE	USDA WHITE

Barr Inc. 1423 Planeview Drive Oshkosh, WI 54904 920-231-1711 Phone		20' x 20' x 8'-4" Drive-In Cooler		TOLERANCES UNLESS SPECIFIED FRACTIONAL .XX ± 1/32" DECIMAL .015 ± .005 X" ± .005 ANGLE ° ± .030" " ± .005 " ± .005 " ± .005 " ± .005		Draftsman is not responsible for panel heights, quantities and/or dimensions. Contractor to verify all information.	
WALL ELEVATIONS				DR.BY: KRZ			
				DATE: 8/30/2016			
				SCALE: NTS			
				CHECKED BY:			
				SHEET NO. A200			
		REVISION		BY		DATE	

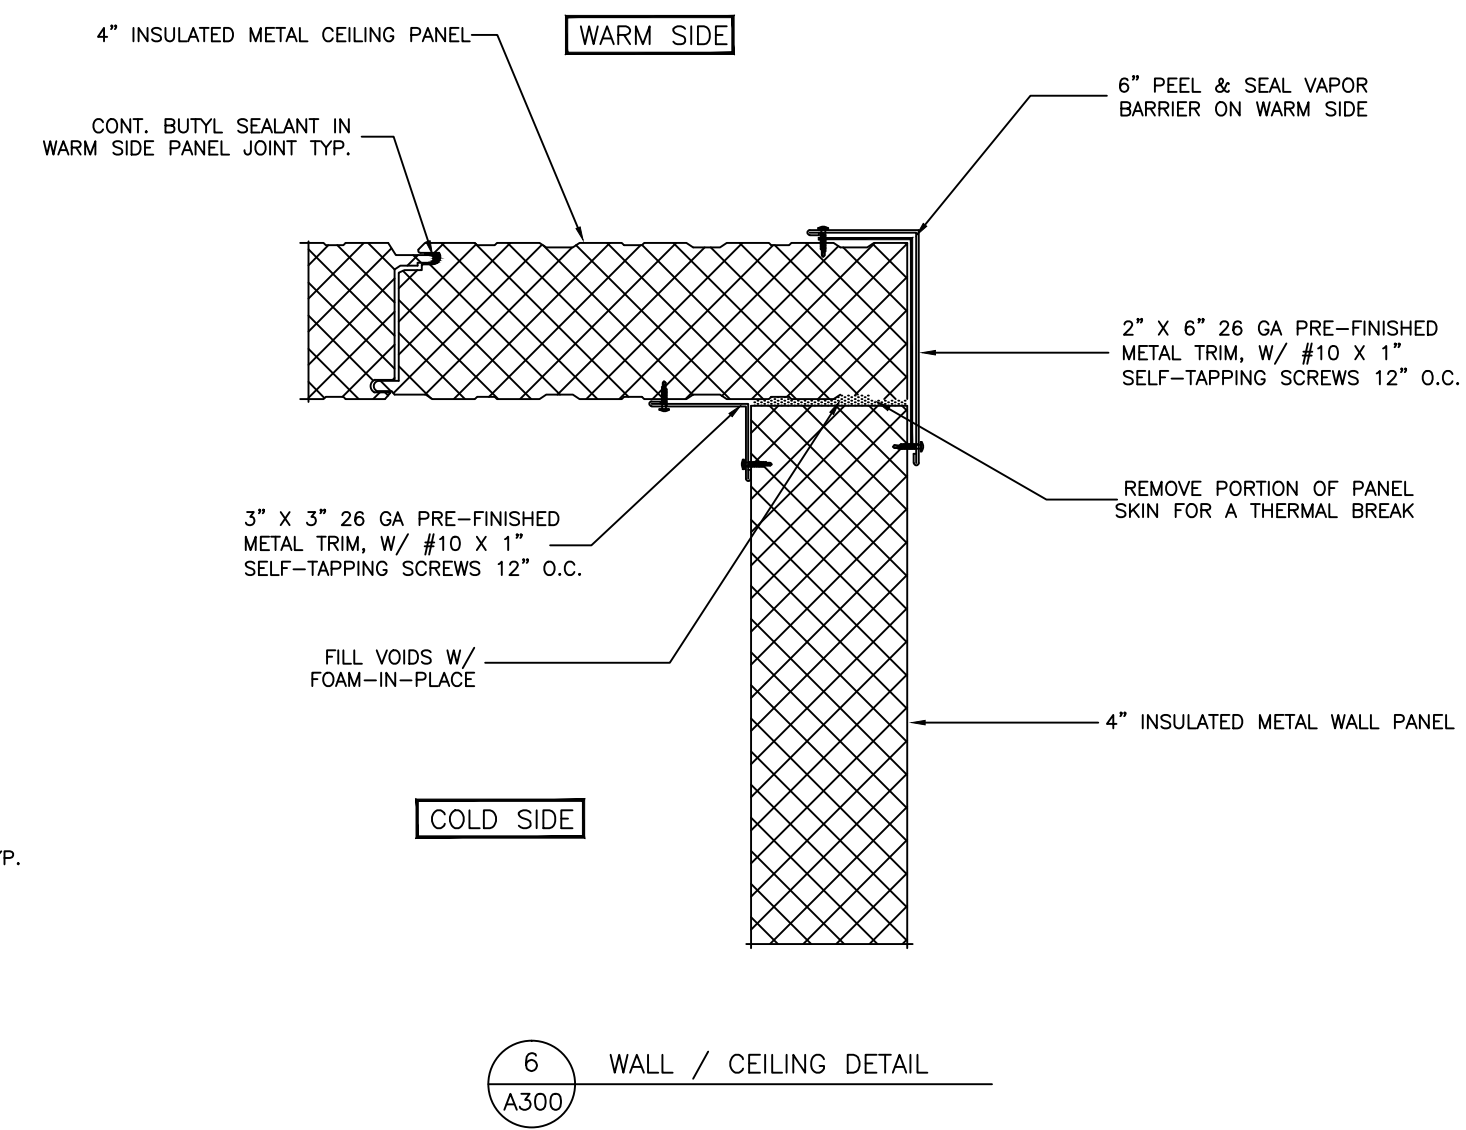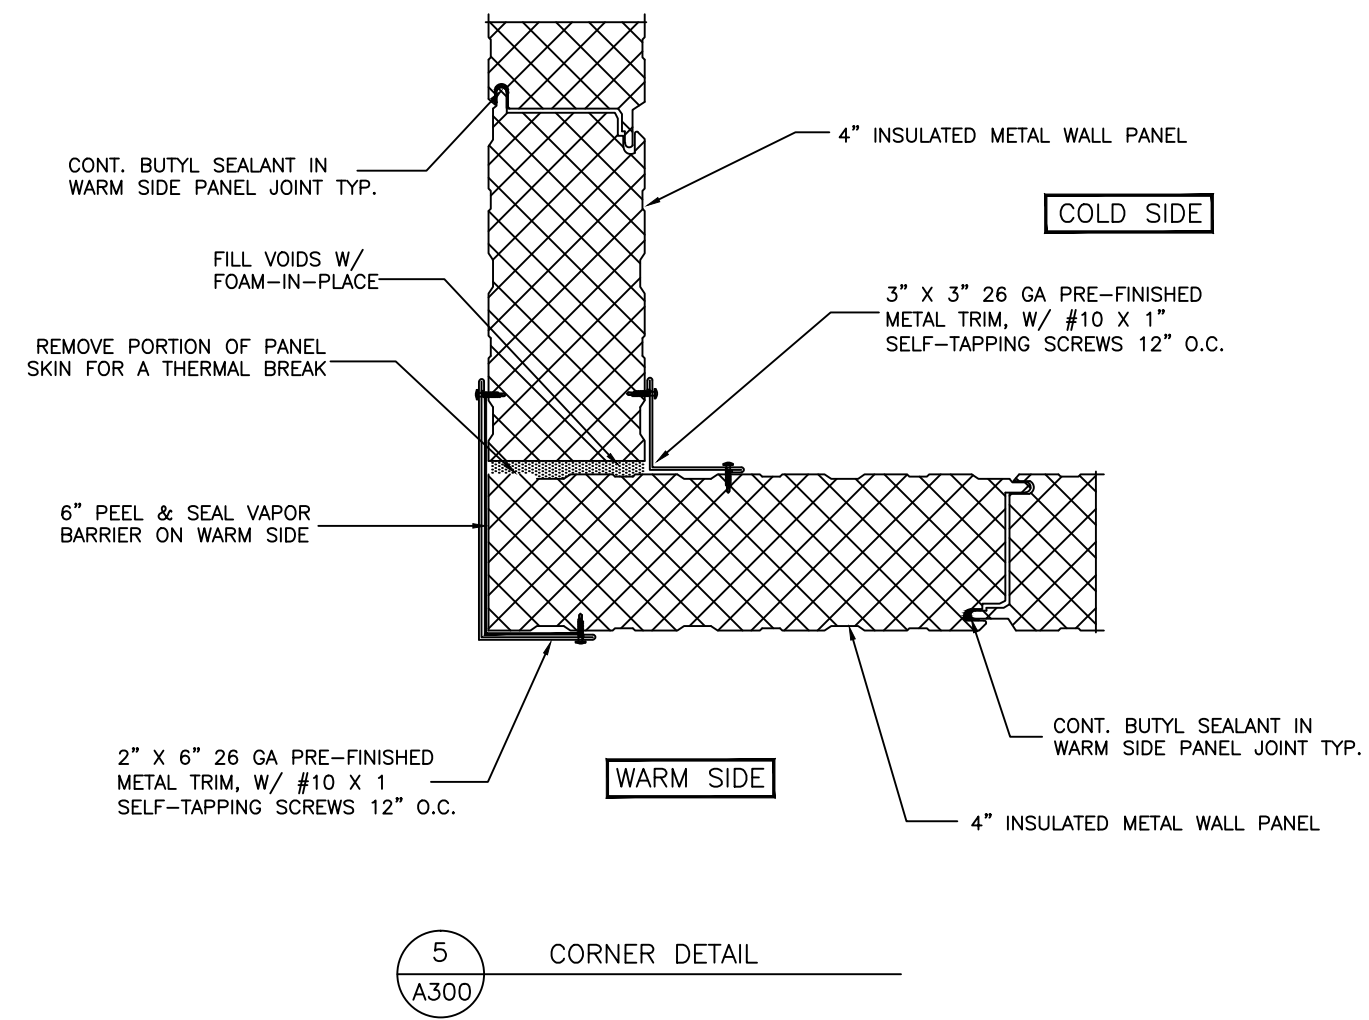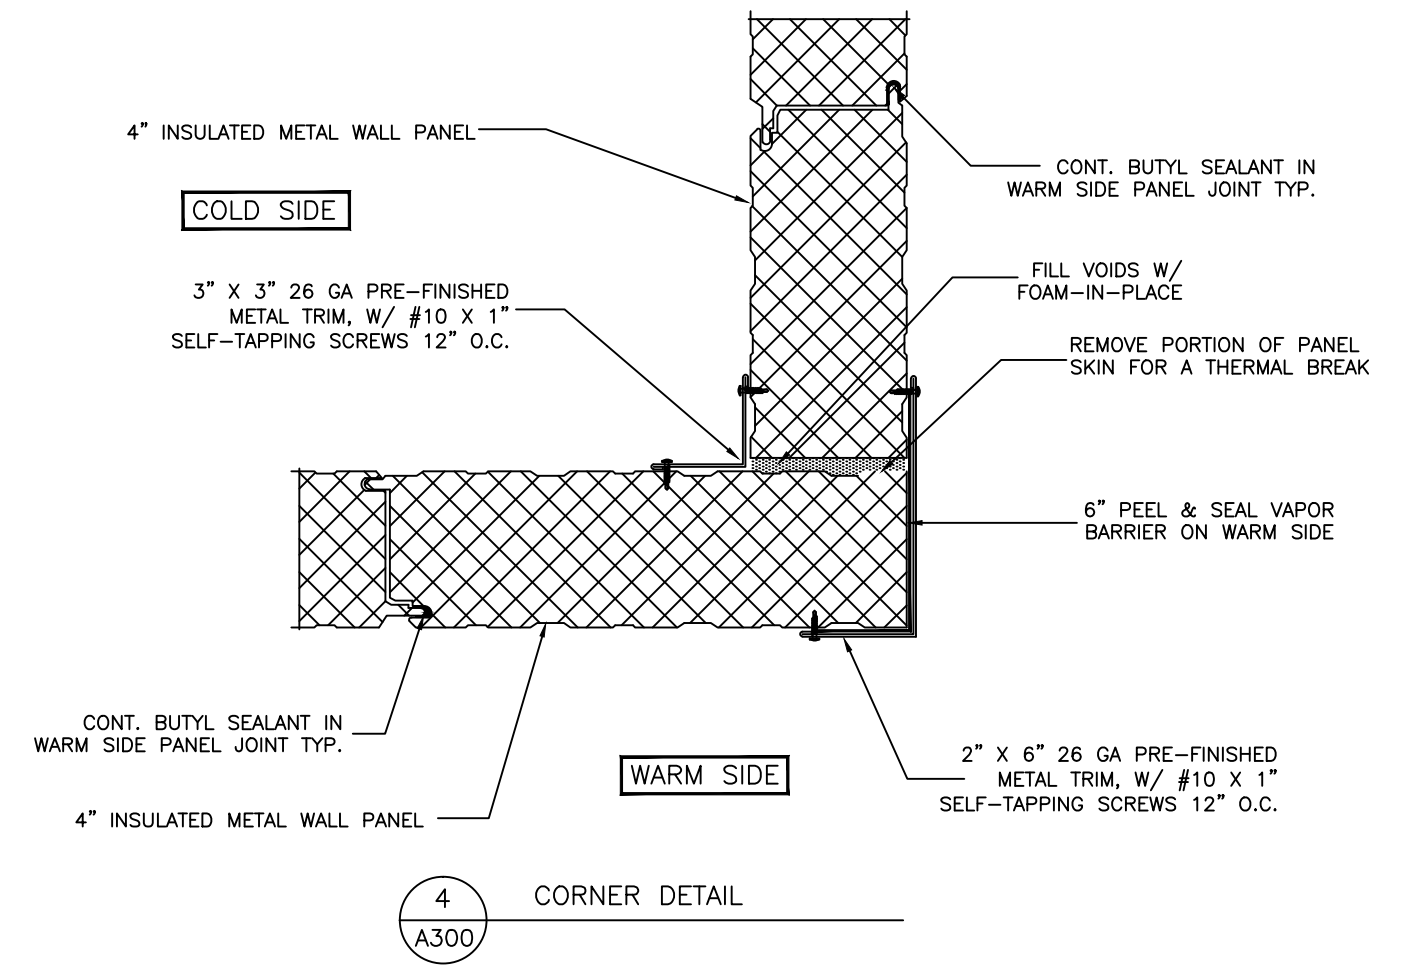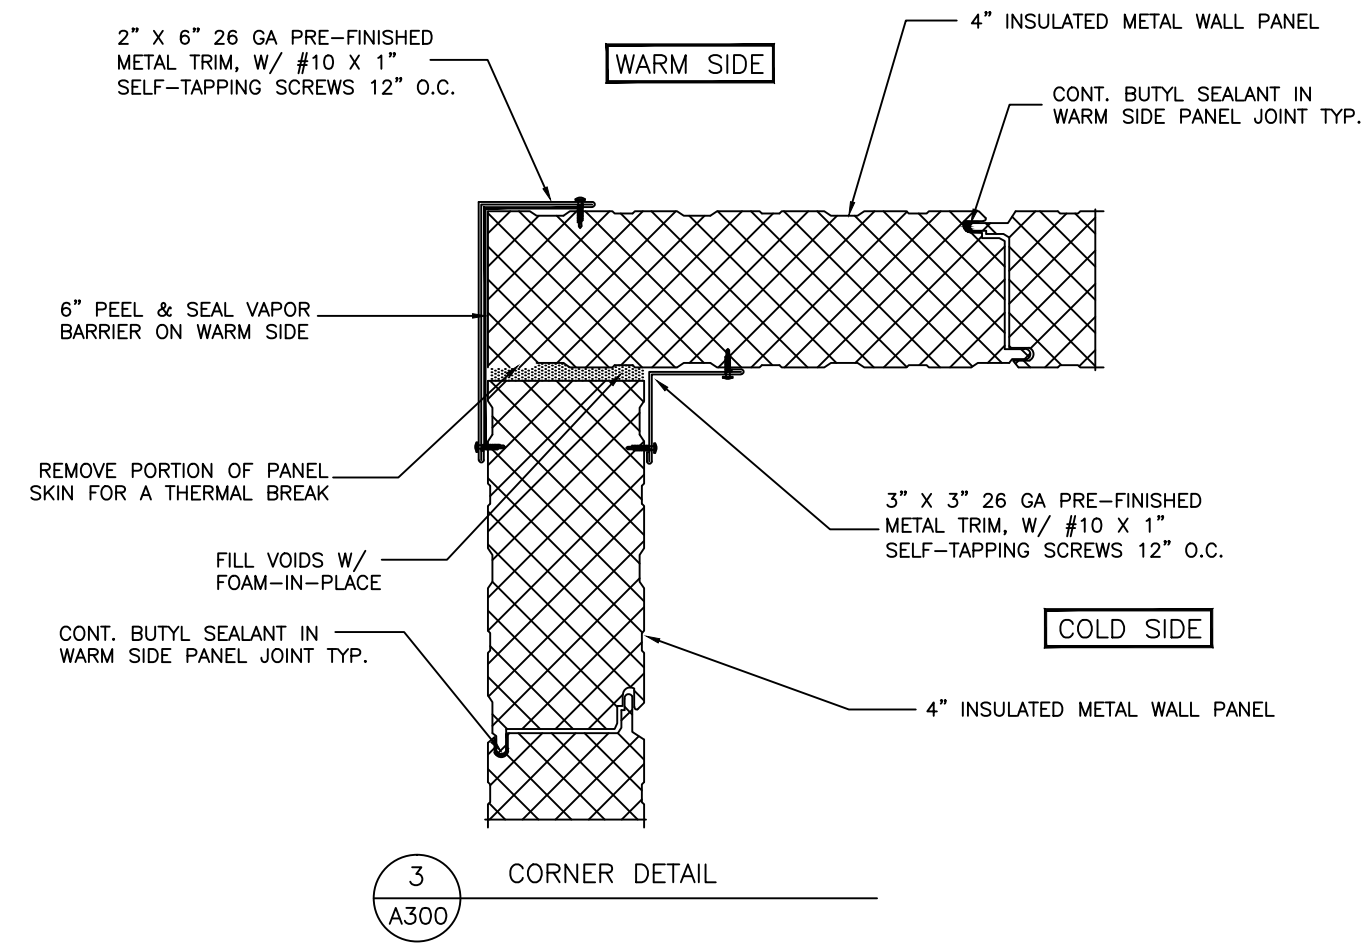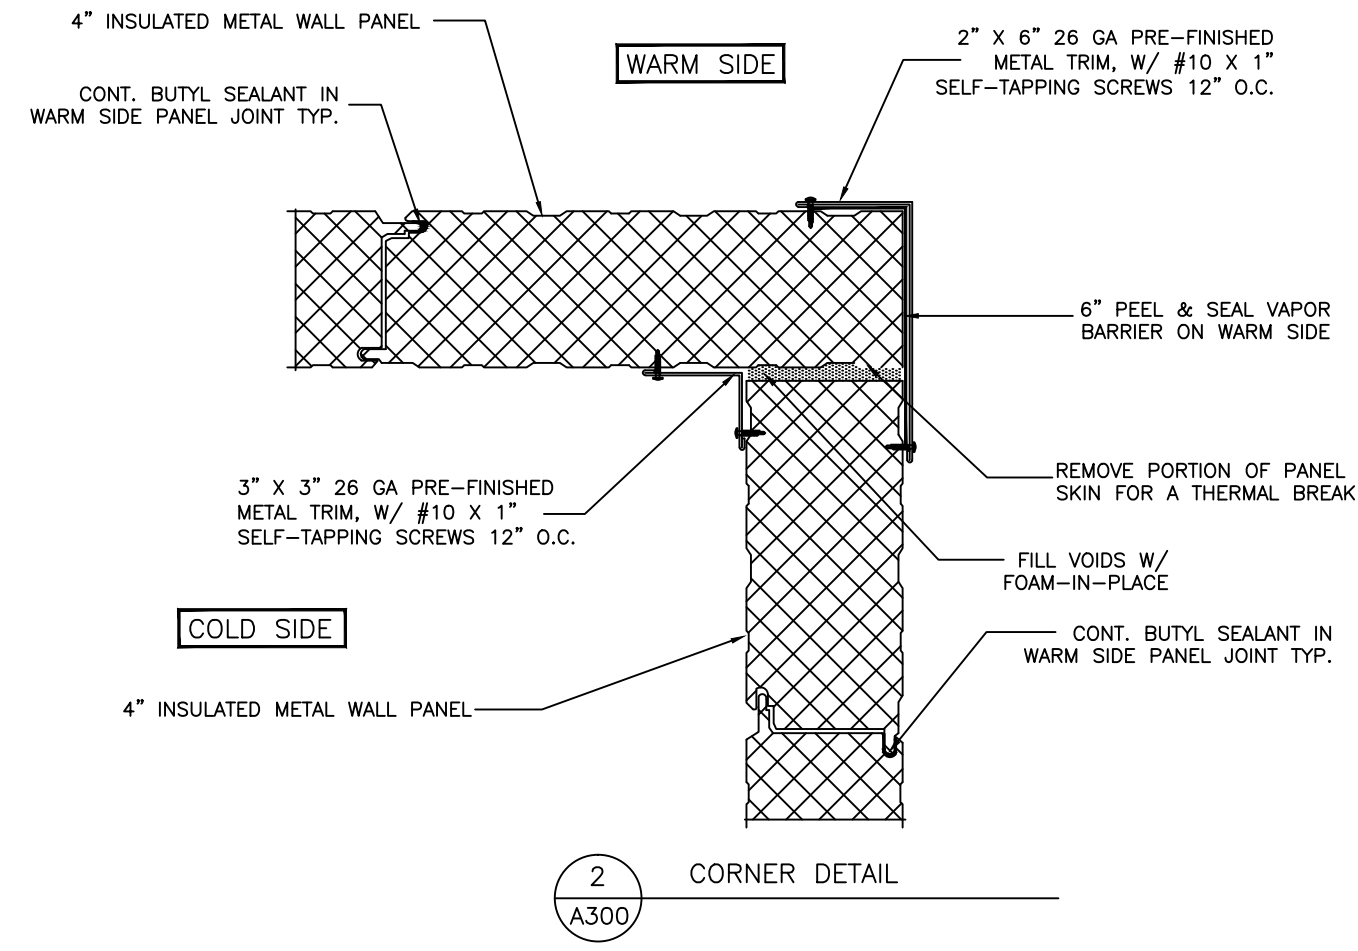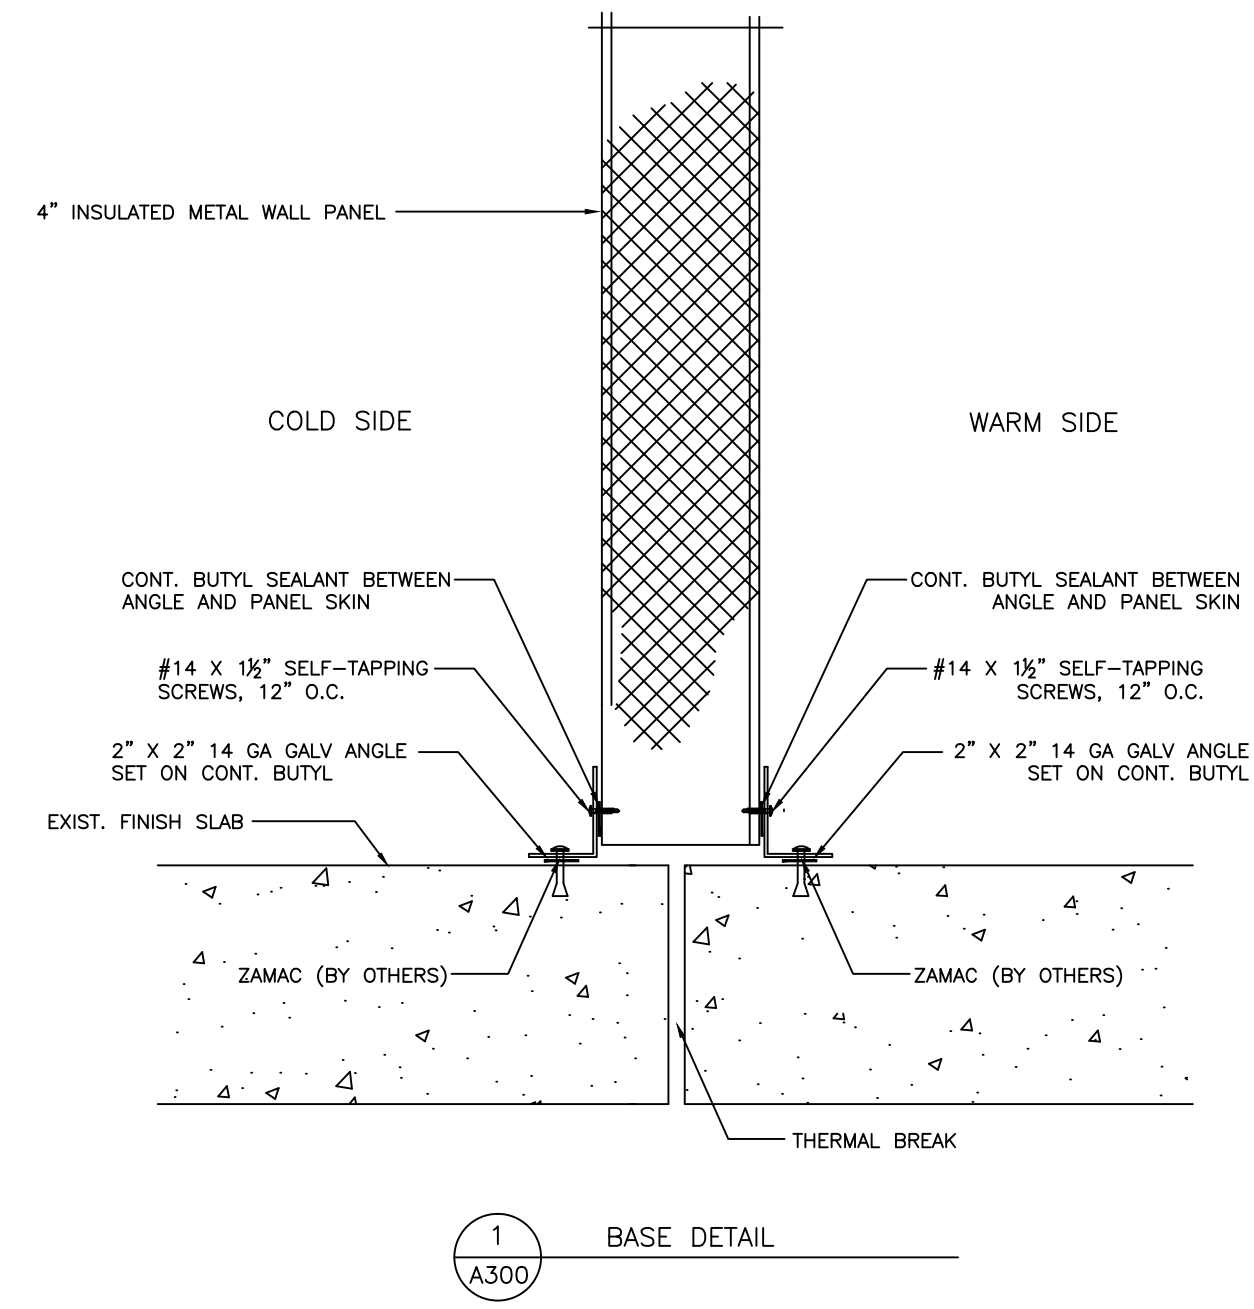

7 NOT USED  
A300

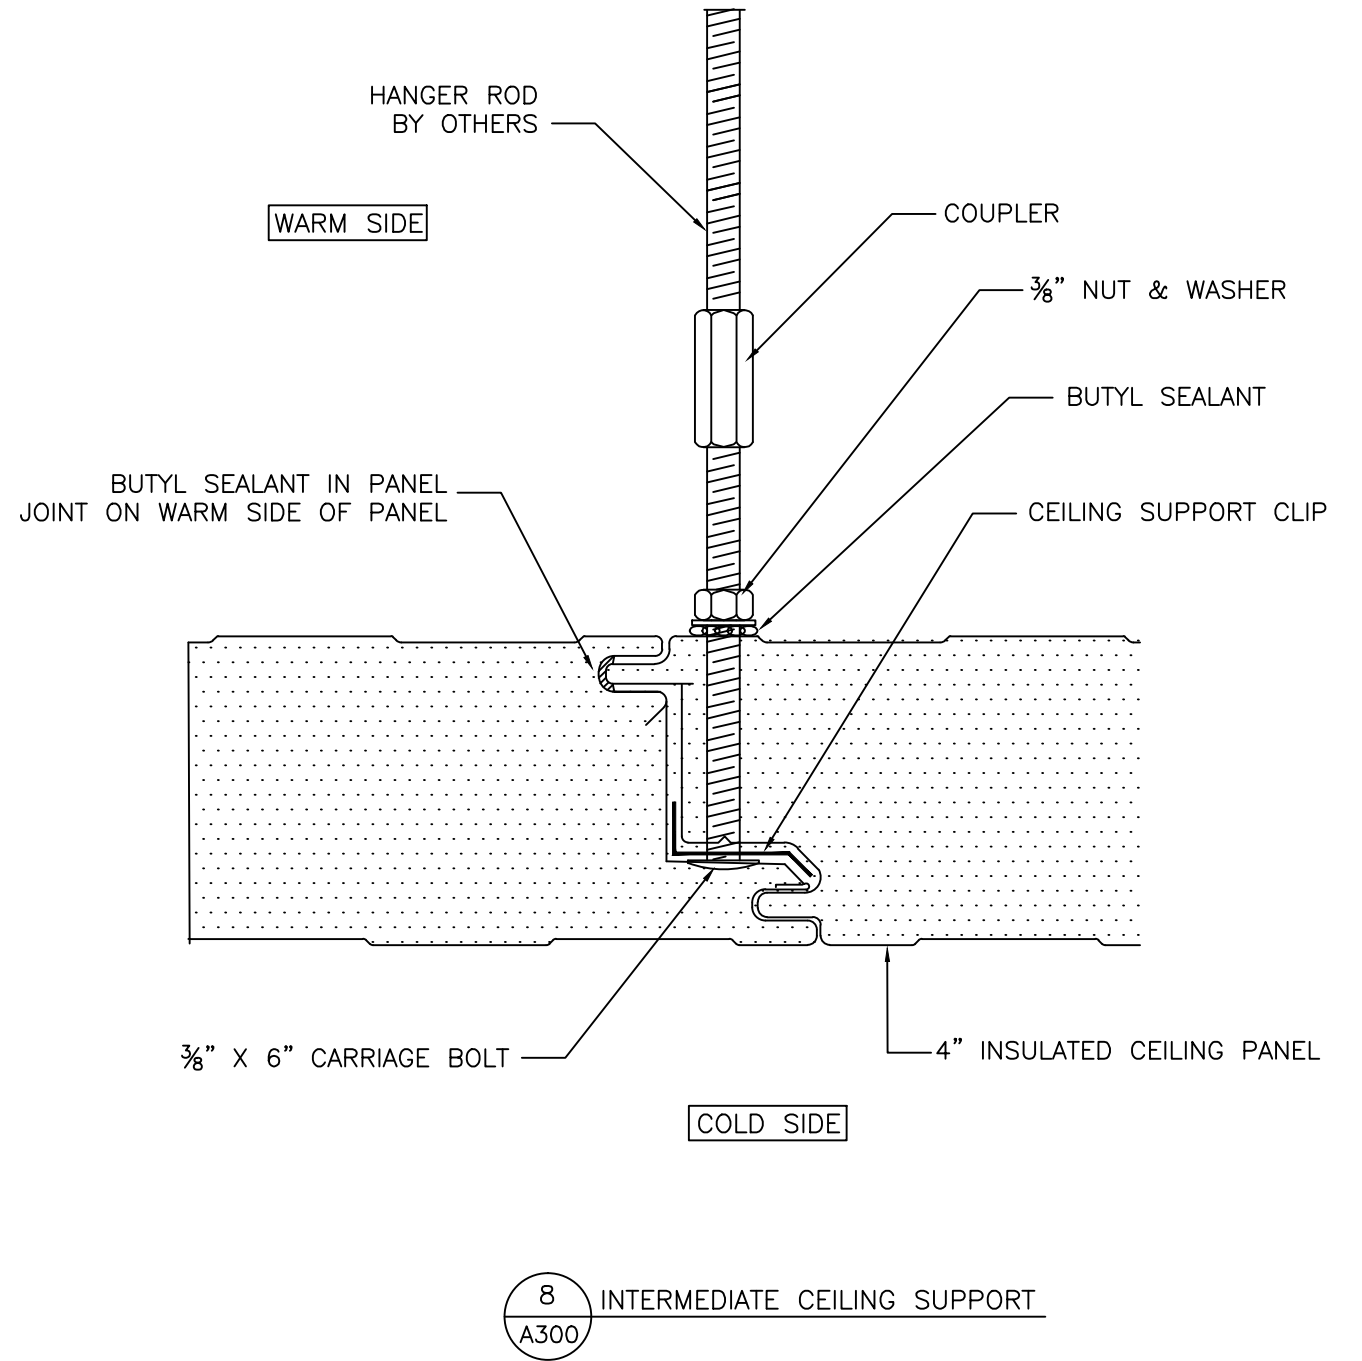

Barr Inc.  
1423 Planeview Drive  
Oshkosh, WI 54904  
920-231-1711 Phone

20' x 20' x 8'-4"  
Drive-In Cooler

TOLERANCES UNLESS SPECIFIED  
FRACTIONAL XX ± 1/32"  
DECIMAL .XX ± .015  
ANGLE X° ± 0°30'  
X'X" ± .005  
X'X' ± 0°05'  
.XXXX ± .001  
Draftsman is not responsible for panel heights, quantities and/or dimensions. Contractor to verify all information.

WALL DETAILS

DR. BY: KRZ  
DATE: 8/30/2016  
SCALE: NTS  
CHECKED BY:  
SHEET NO. A300

NO.	REVISION	BY	DATE