

Barr Inc.  
 1423 Planeview Drive  
 Oshkosh, WI 54904  
 920-231-1711 Phone

40' x 40' x 16'-5"  
 Drive-In Freezer

**DRAWING INDEX**

<b>T.1</b>	<b>TITLE SHEET</b>
<b>A100</b>	<b>FLOOR/CEILING PLAN</b>
<b>A200</b>	<b>INSULATED WALL PANEL ELEVATIONS</b>
<b>A300</b>	<b>INSULATED WALL PANEL DETAILS</b>

REVISION	DATE	BY

Barr Inc.  
 1423 Planeview Drive  
 Oshkosh, WI 54904  
 920-231-1711 Phone


40' x 40' x 16'-5"  
 Drive-In Freezer

TOLERANCES UNLESS SPECIFIED  
 FRACTIONAL ± 1/32"  
 DECIMAL ± .015"  
 ANGLE ± 0°30'  
 X/X" ± .005"  
 .XXX ± .005"  
 .XXXX ± .001"


Draftsmen is not responsible for panel heights,  
 wall dimensions. Contractor to  
 verify all information.

TITLE


DR. BY: KRZ  
 DATE: 8/1/2023  
 SCALE: NTS  
 CHECKED BY:  
 SHEET NO. T.1

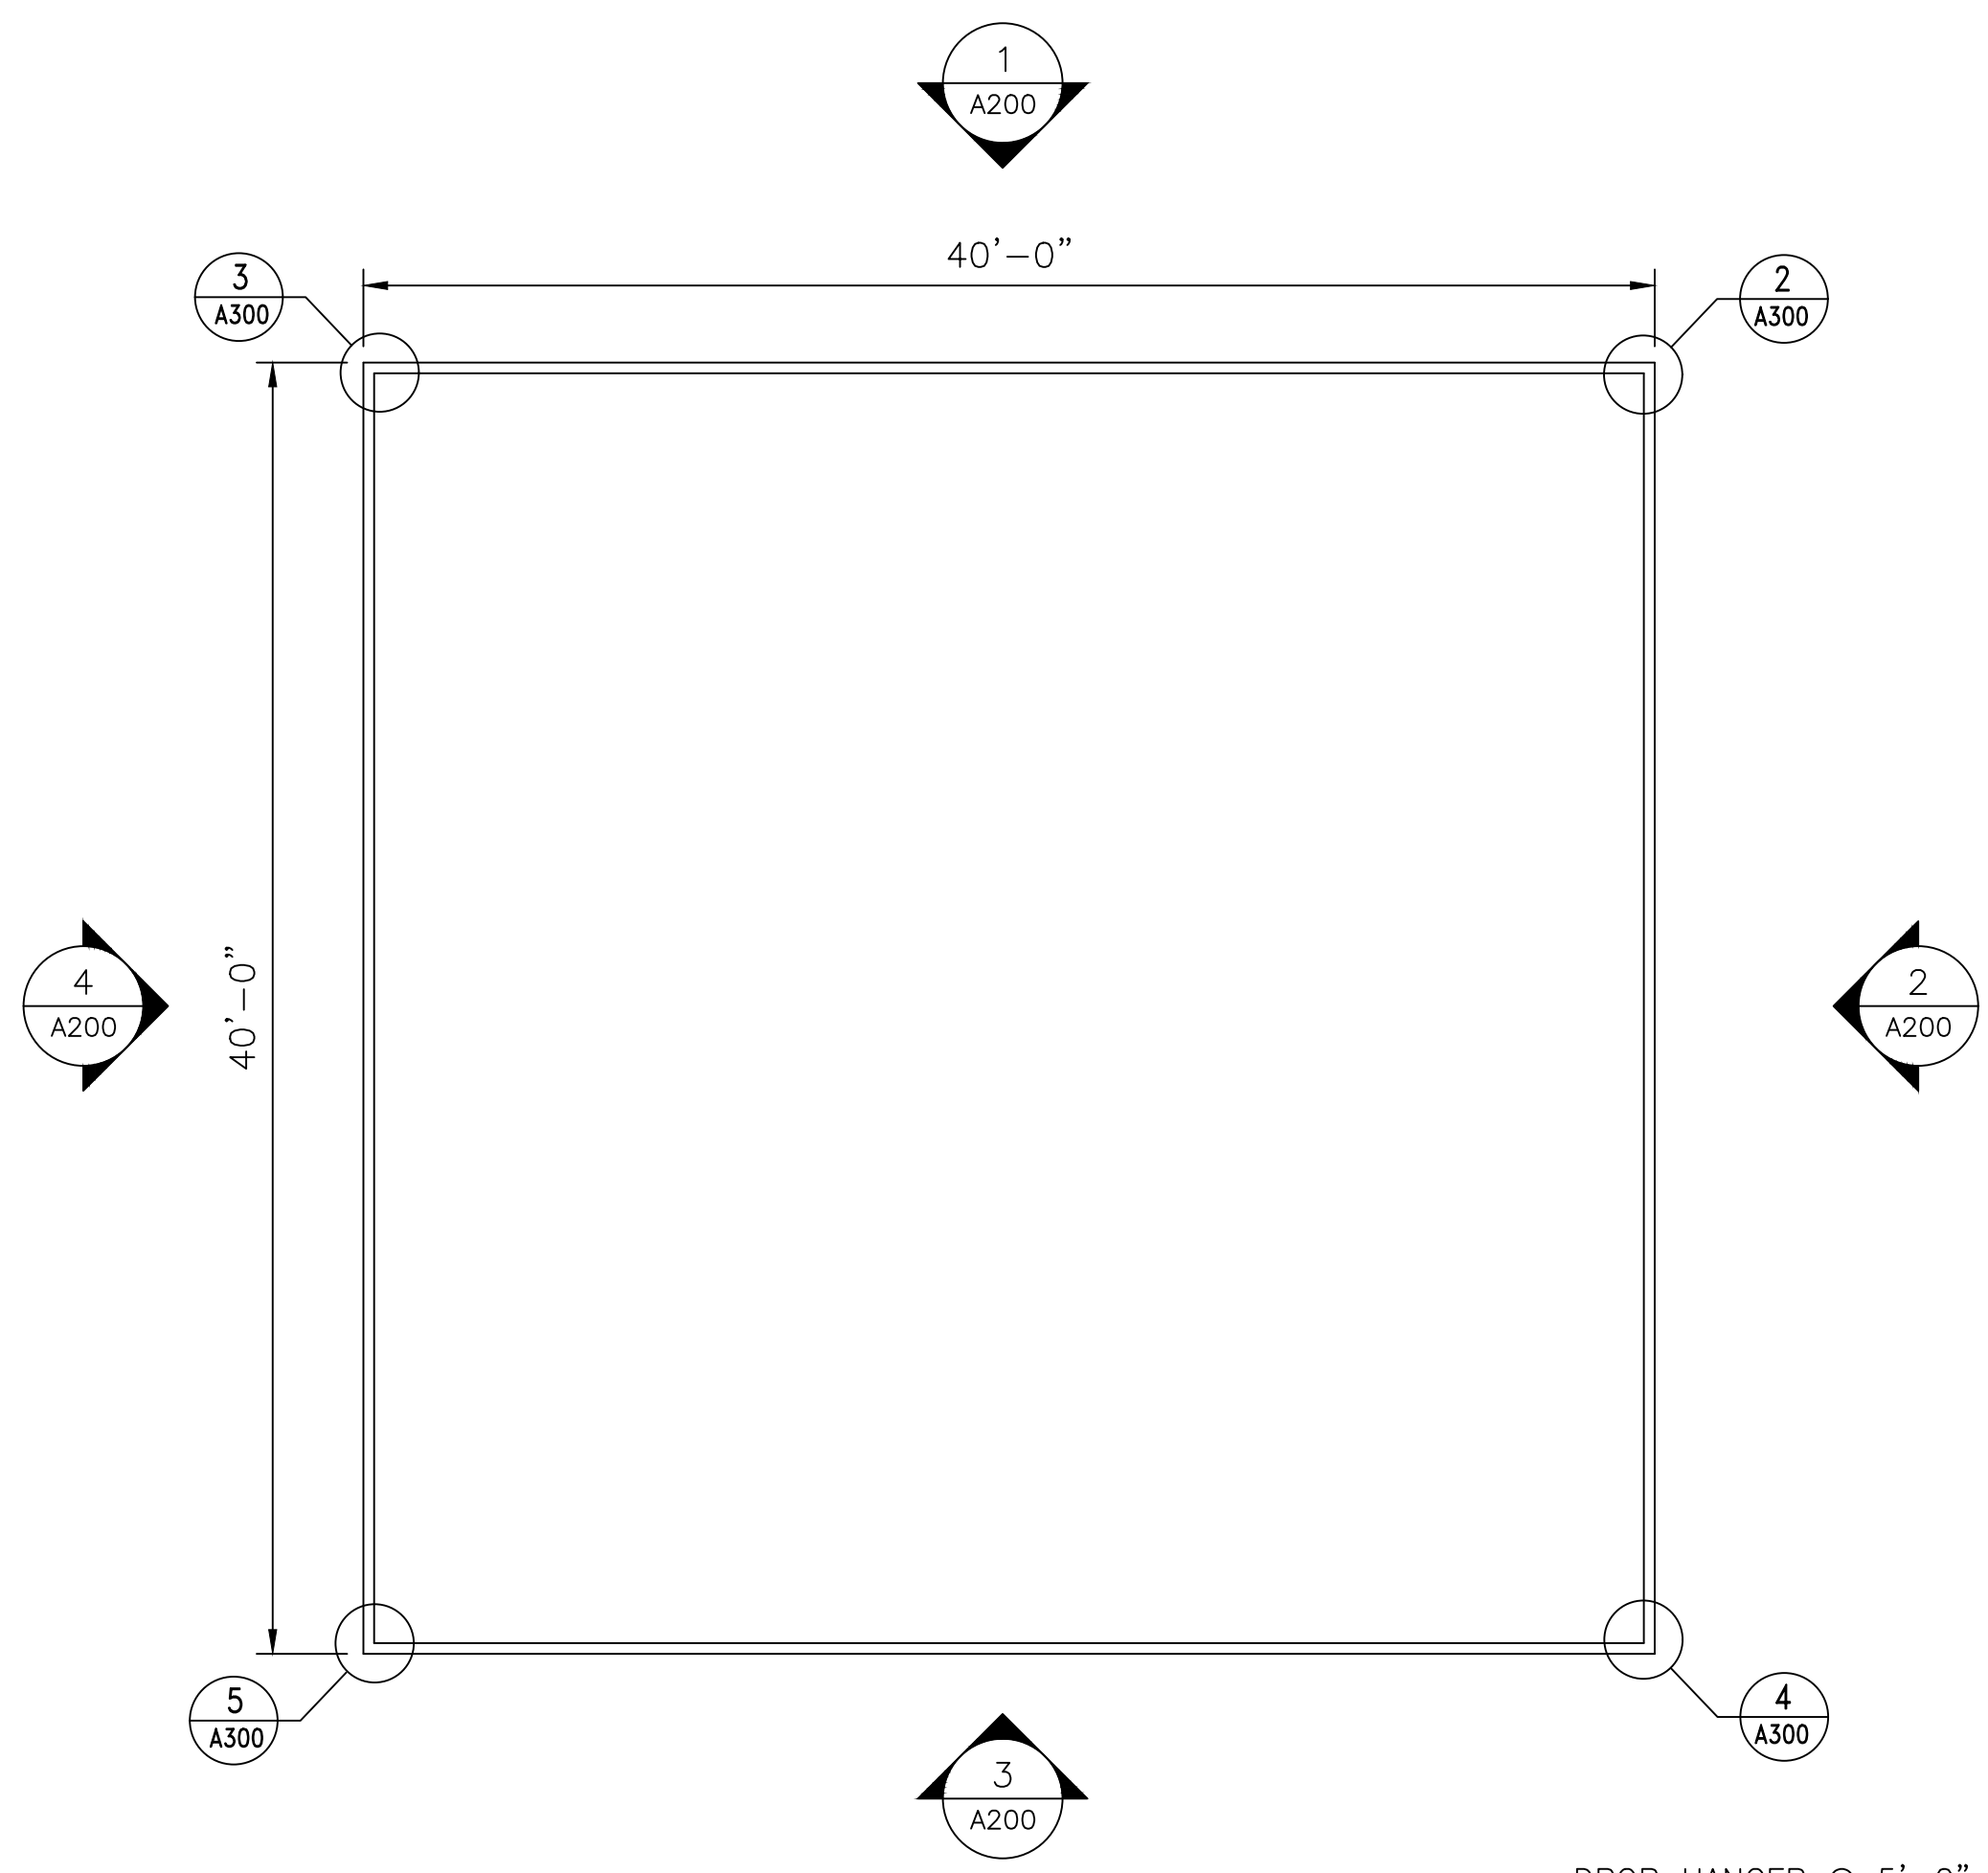

1 FLOOR PLAN  
A100 SCALE: N.T.S.

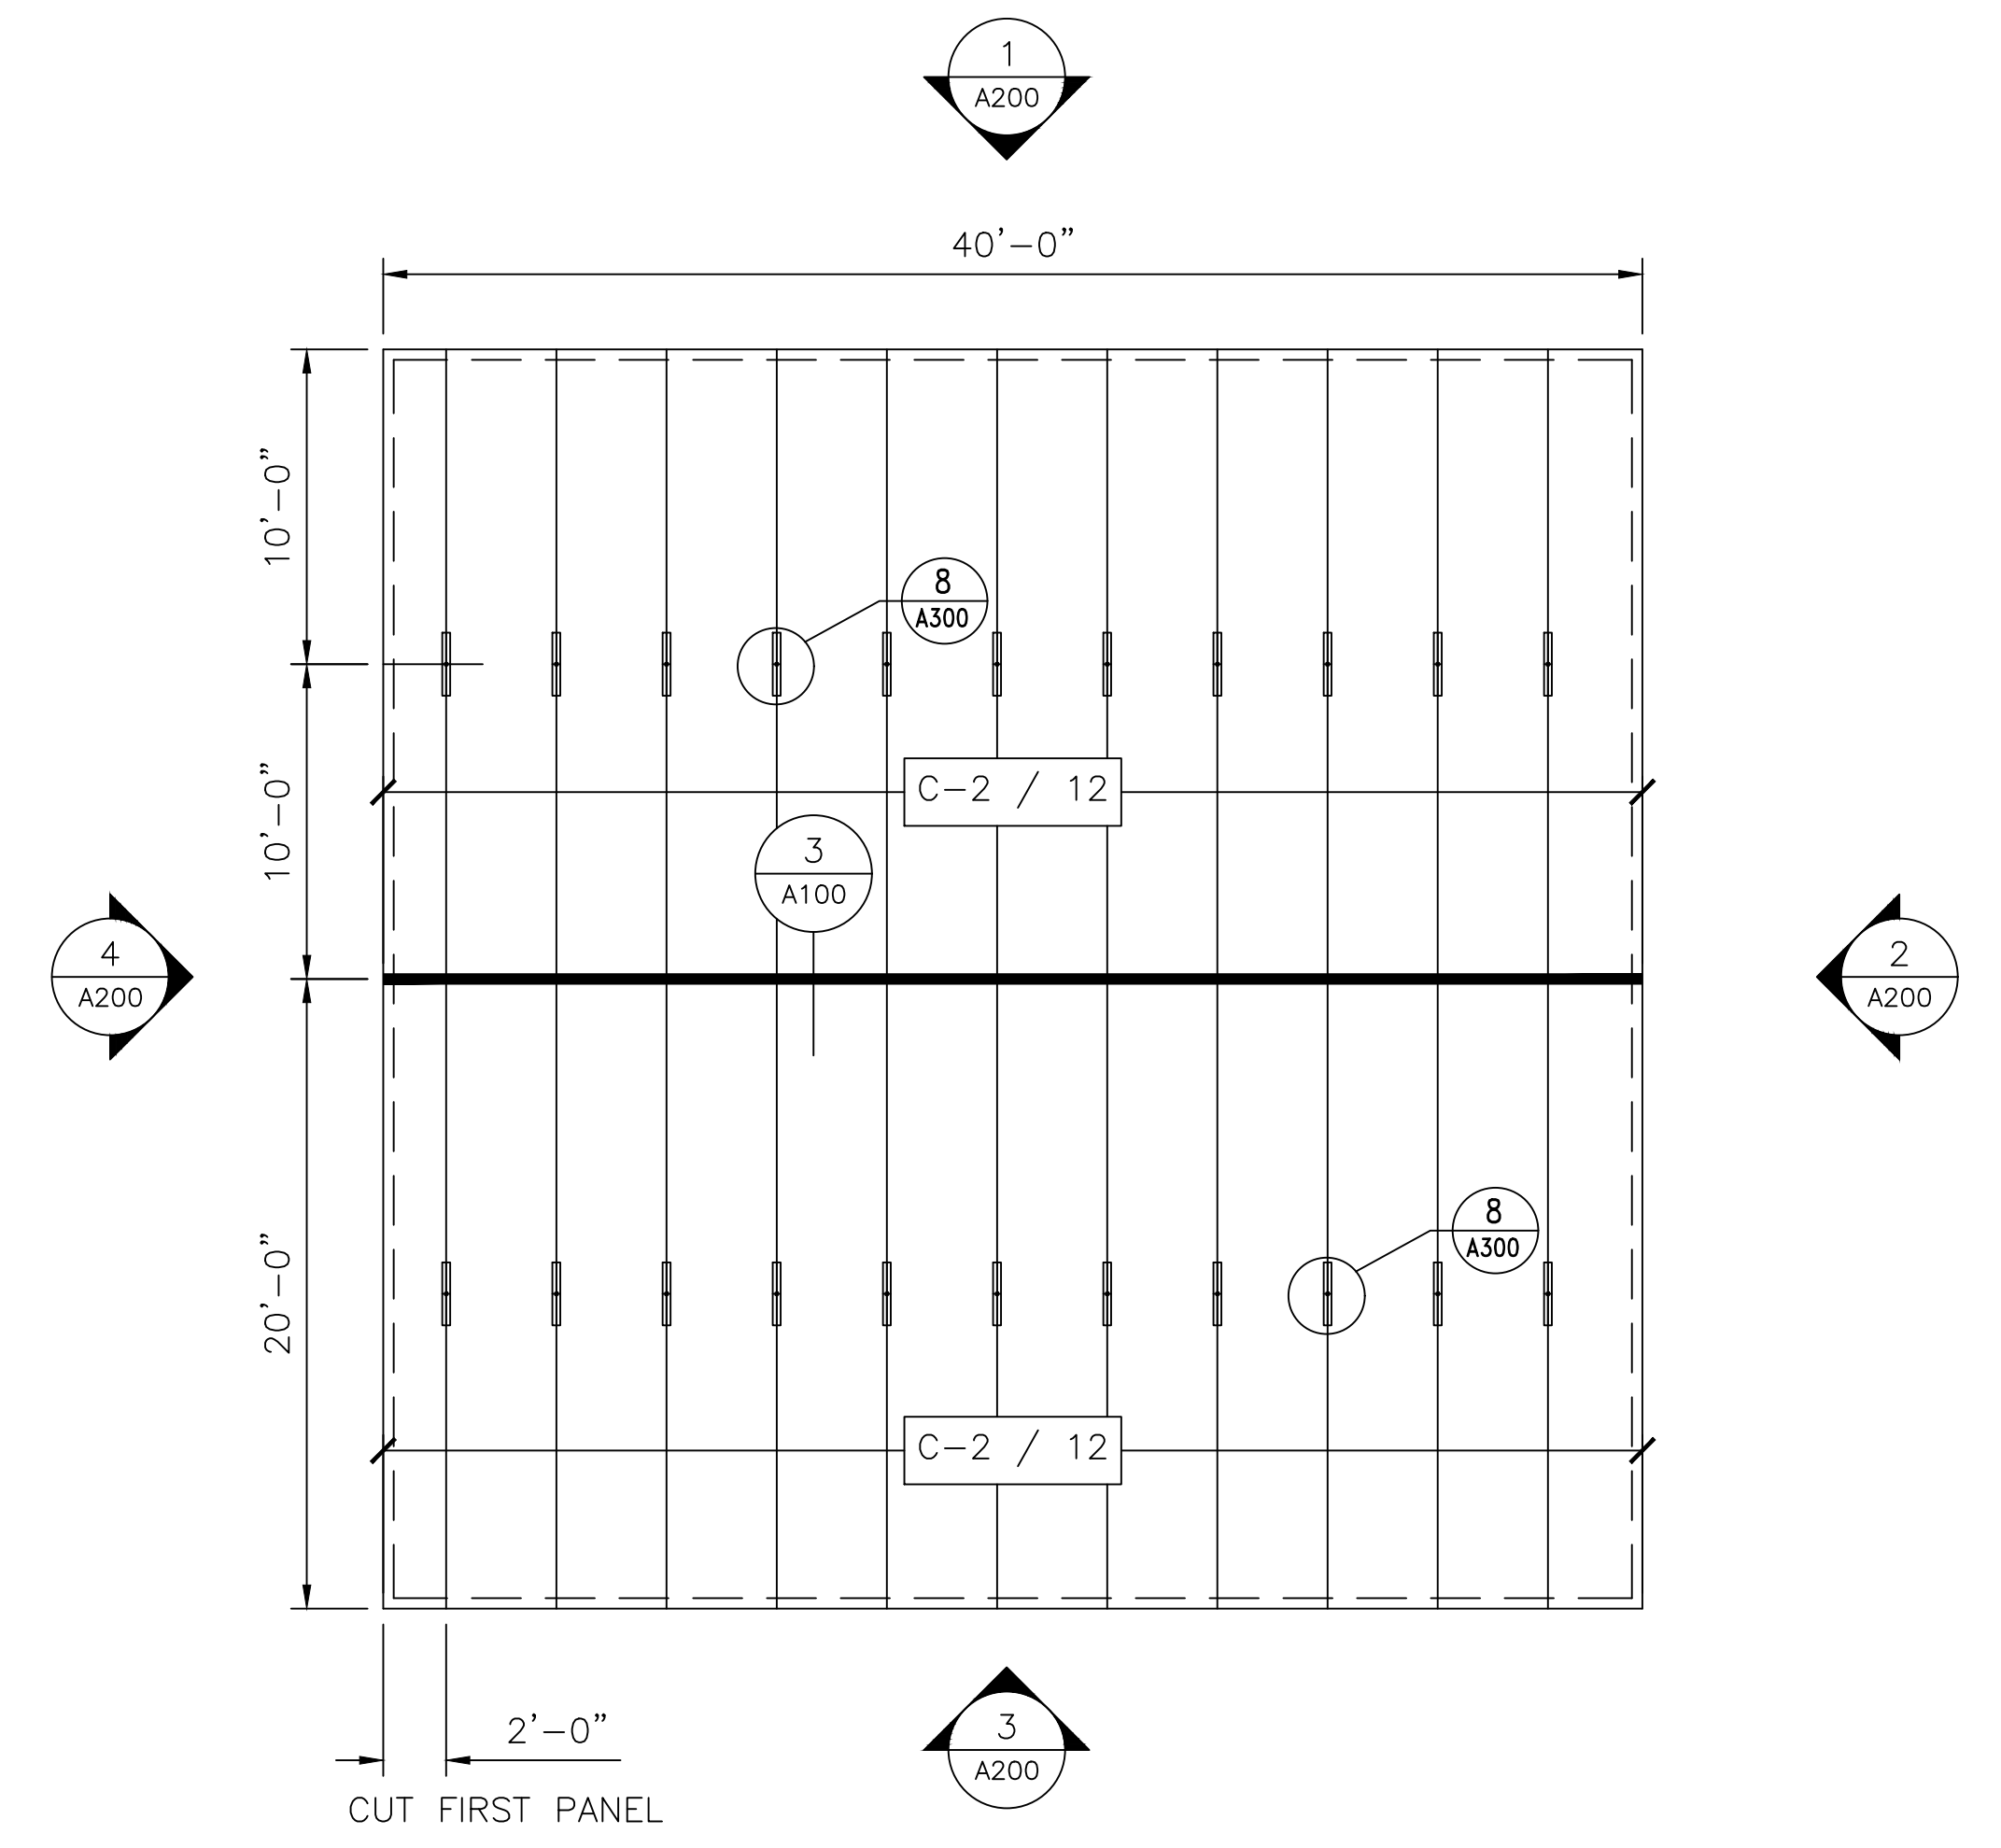

2 CEILING PLAN  
A100 SCALE: N.T.S.

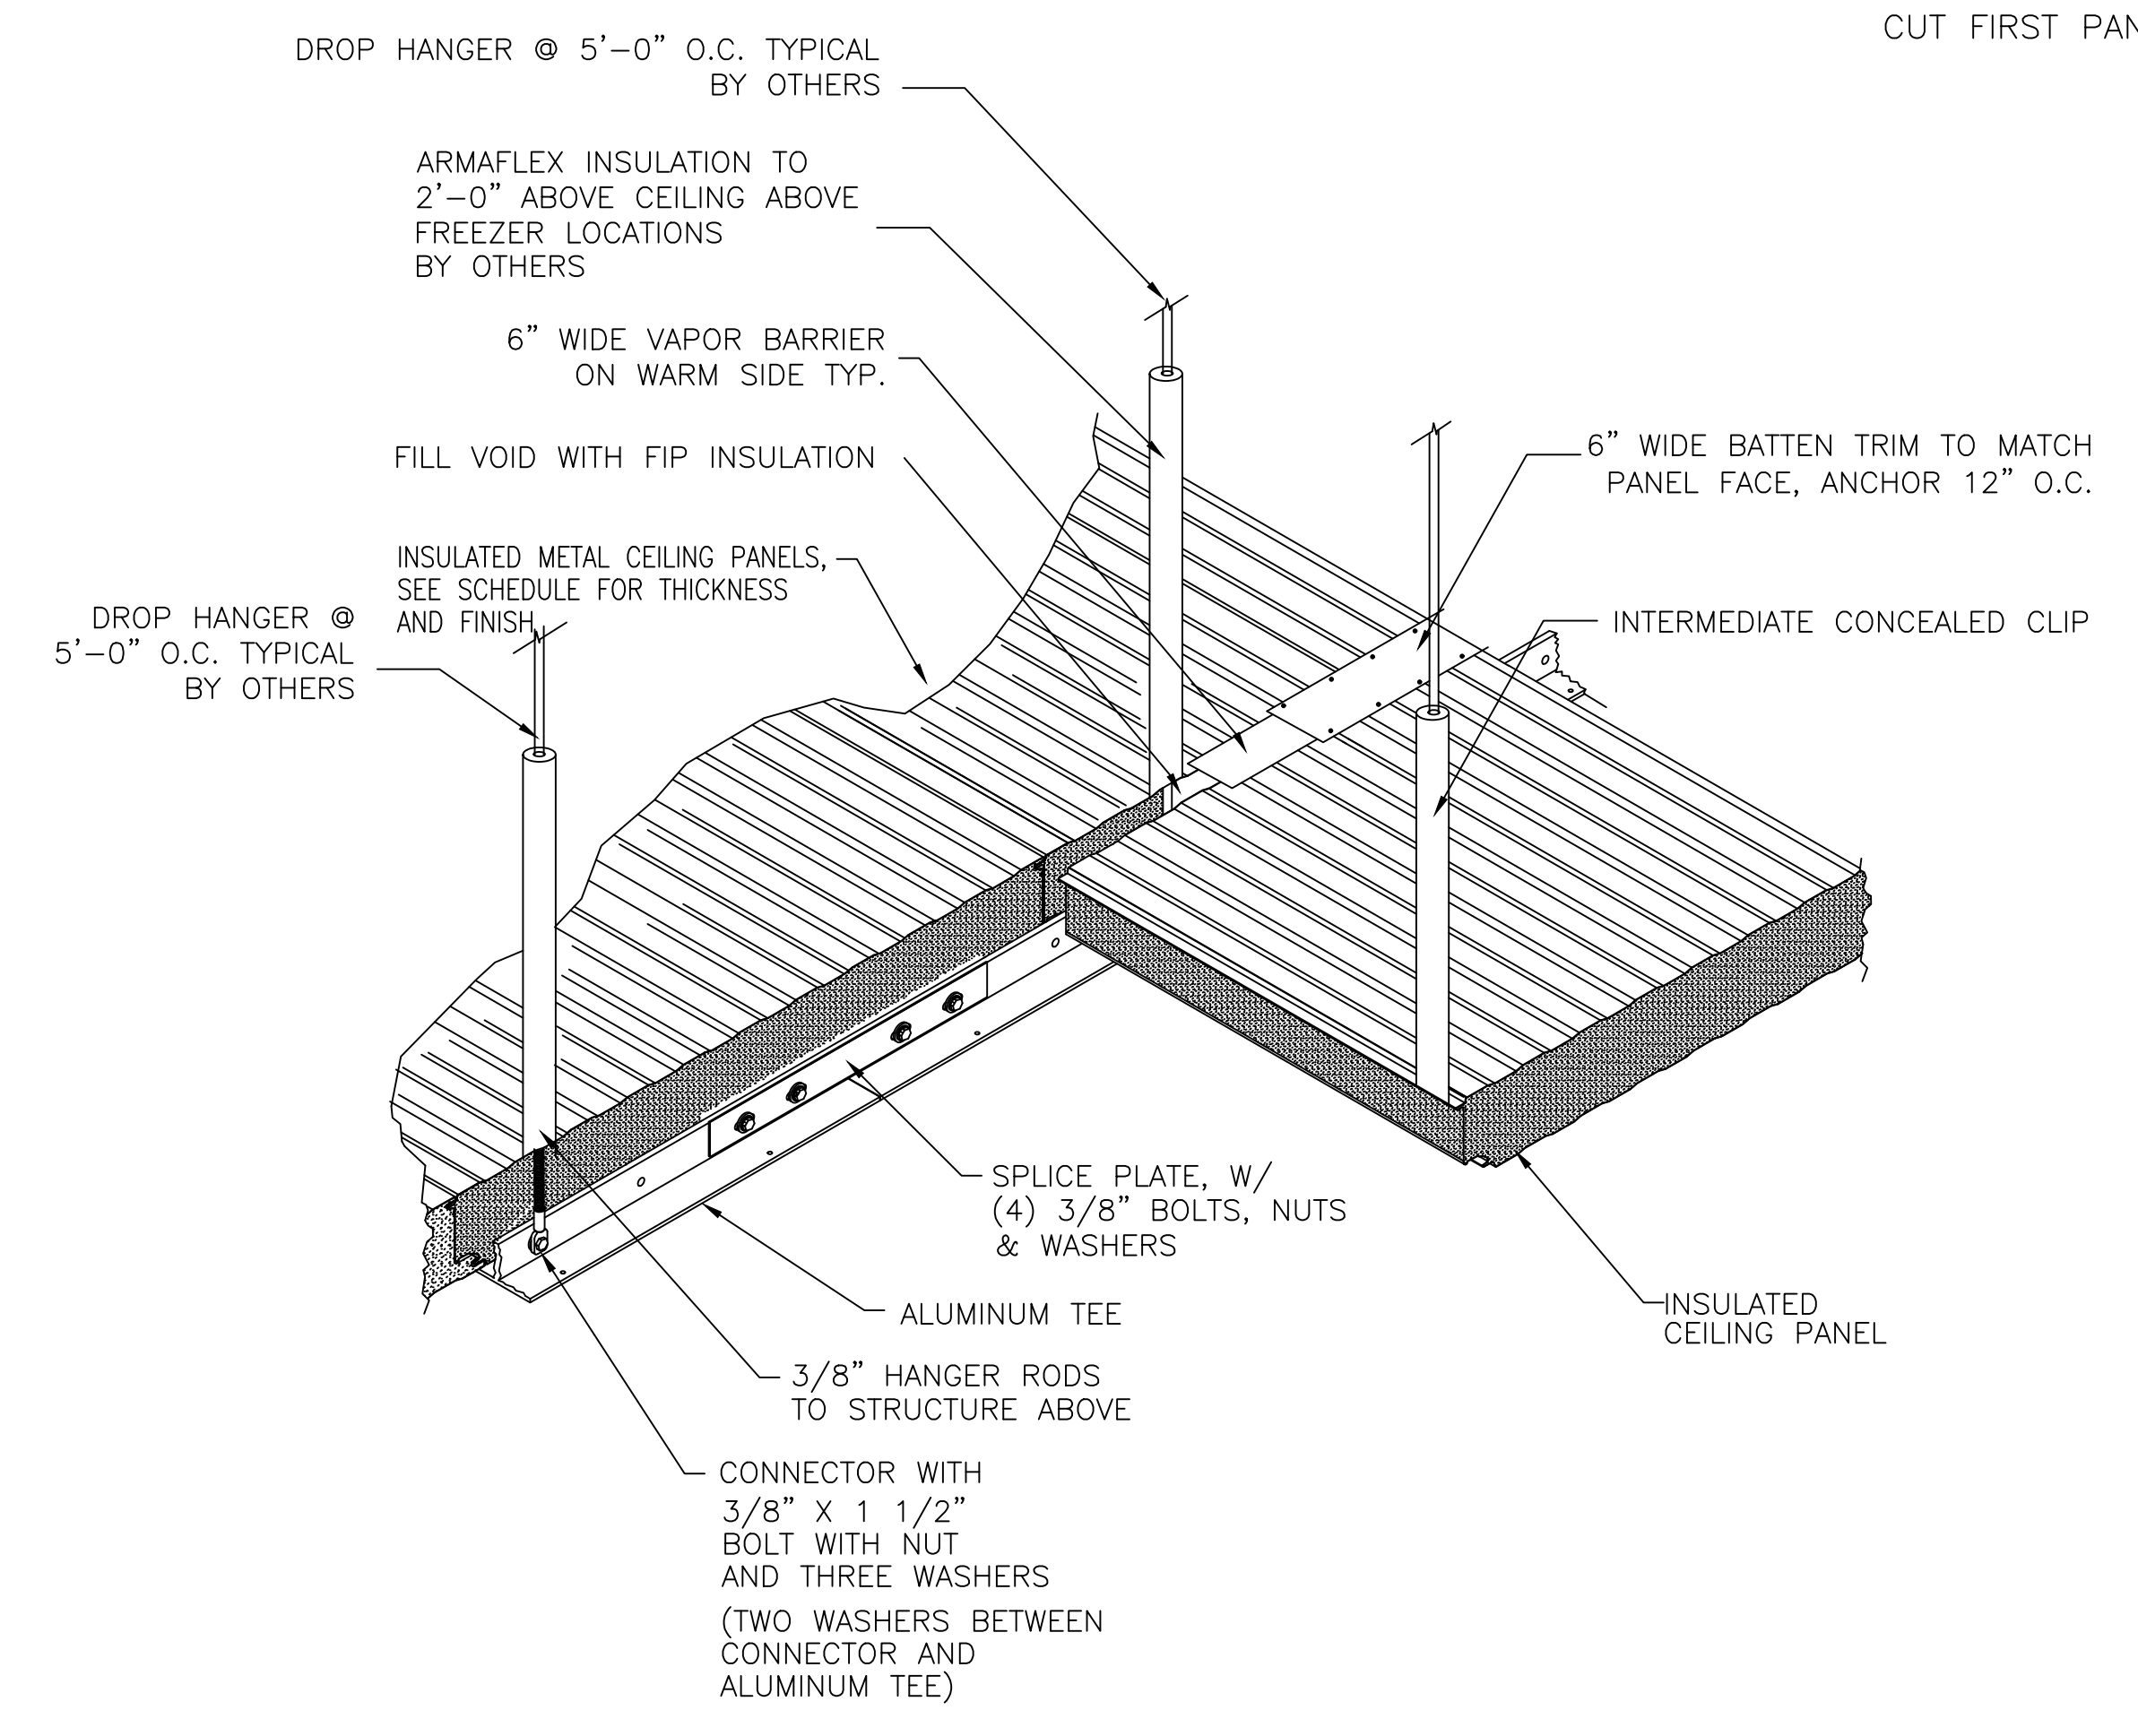

3 CEILING TEE DETAIL  
A100 SCALE: N.T.S.

PANEL SCHEDULE

PANEL DESIG.	PANEL HEIGHT	QTY OF PANELS	PANEL THICK	PANEL SERIES	PANEL COLOR
W-1	16'-0"	48	5"	MESALINE	USDA WHITE
C-2	20'-0"	24	5"	MESALINE	USDA WHITE

NO.	DATE	BY

Barr Inc.  
1423 Planeview Drive  
Oshkosh, WI 54904  
920-231-1711 Phone

40' x 40' x 16'-5"  
Drive-In Freezer









TOLERANCES UNLESS SPECIFIED  
FRACTIONAL X"/X" ± 1/32"  
DECIMAL .XX ± .015  
XXX ± .005  
XXXX ± .001  
ANGLE X° ± 0'30"  
X'XX ± 0'05"

Draftsmen is not responsible for panel heights, verify all dimensions. Contractor to verify all information.

FLOOR PLAN

DR.BY: KRZ  
DATE: 8/1/2023  
SCALE: NTS  
CHECKED BY:  
SHEET NO. A100



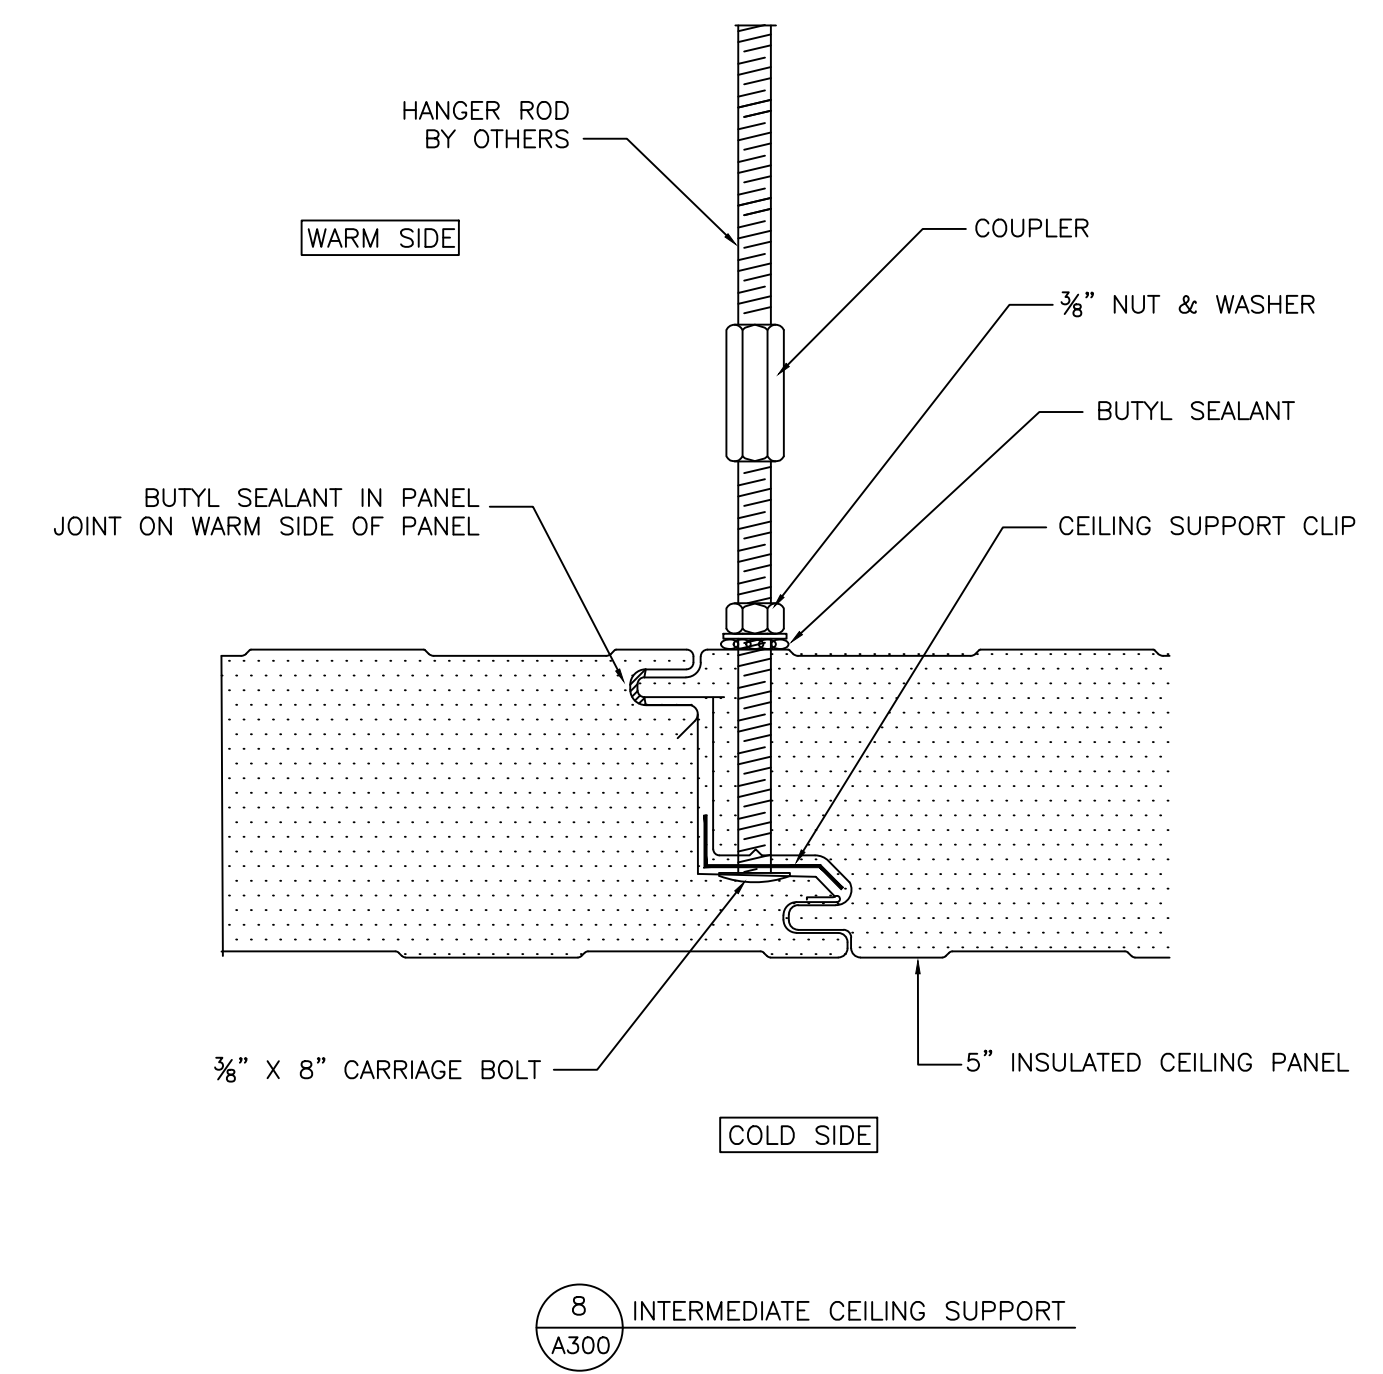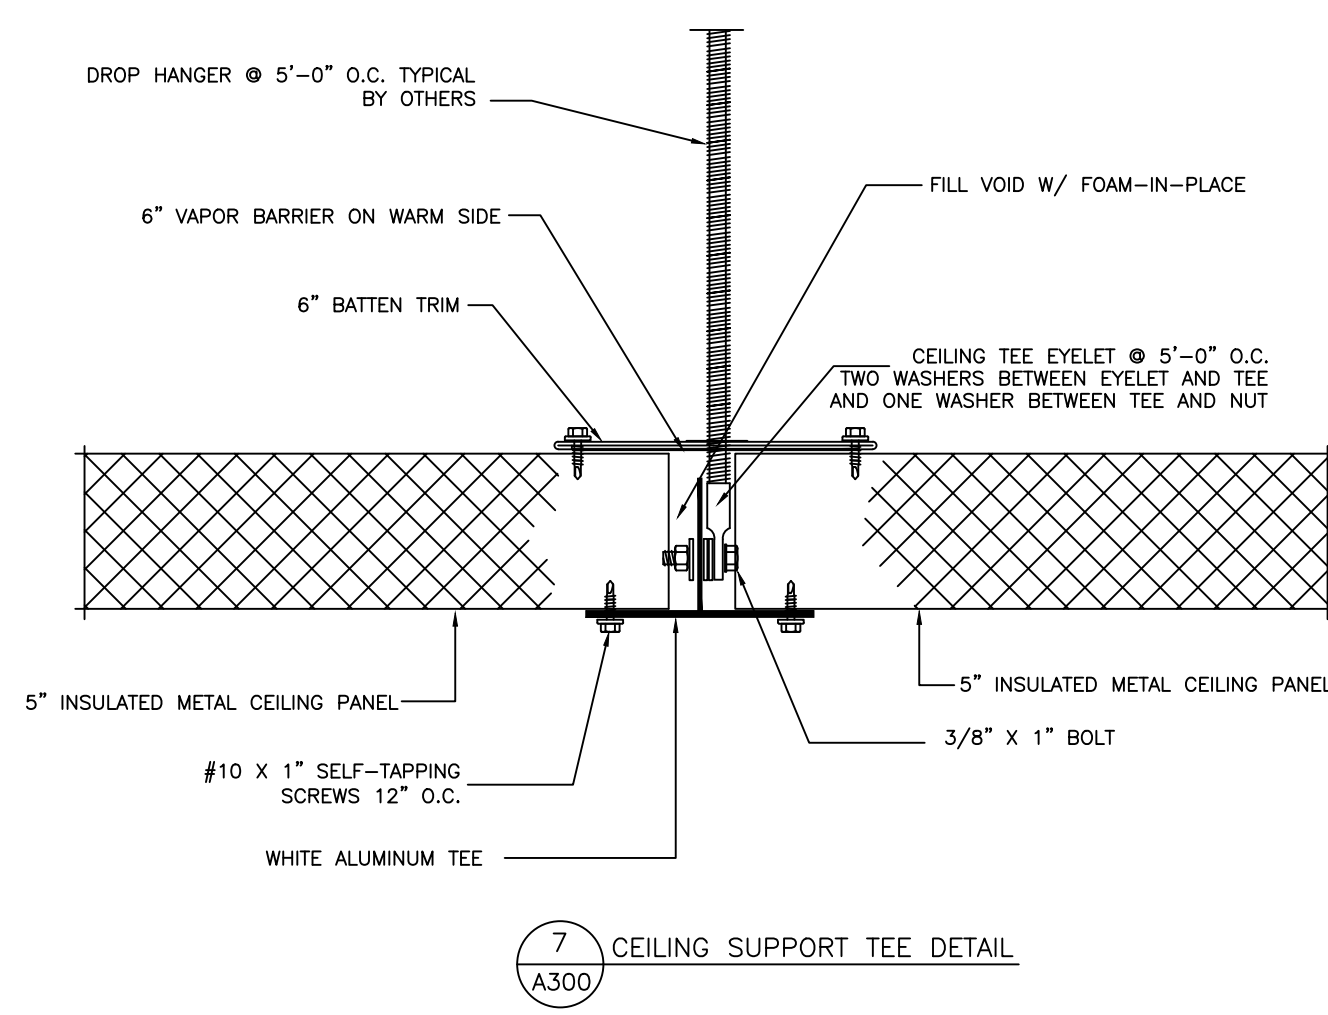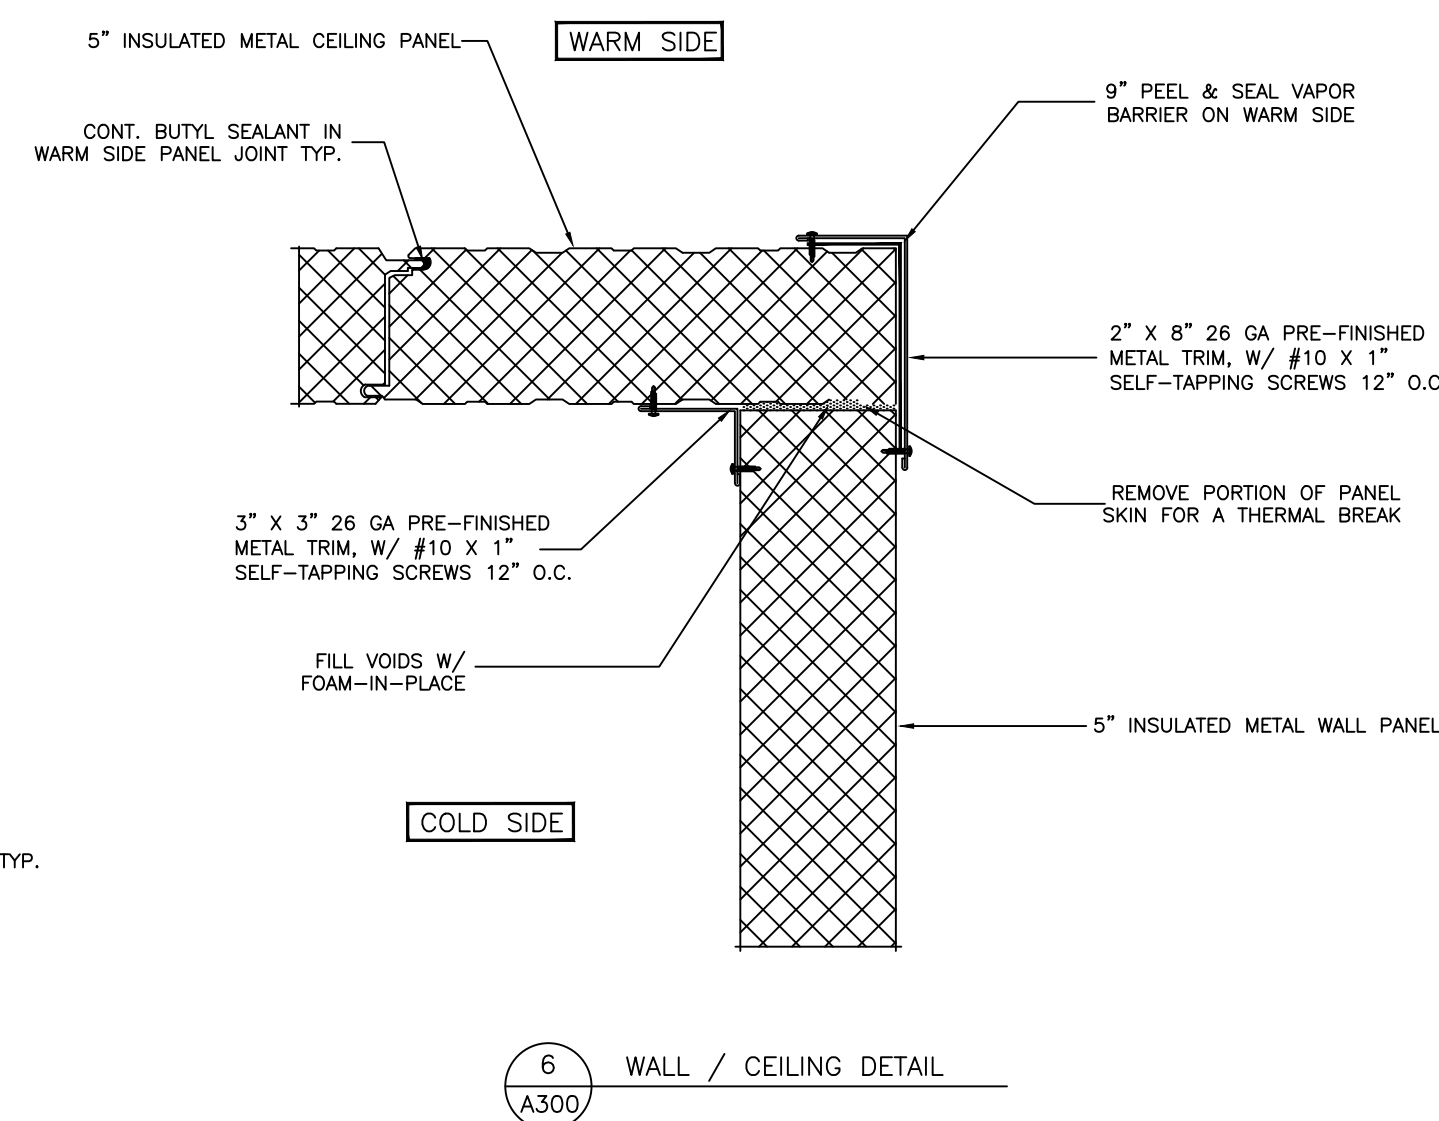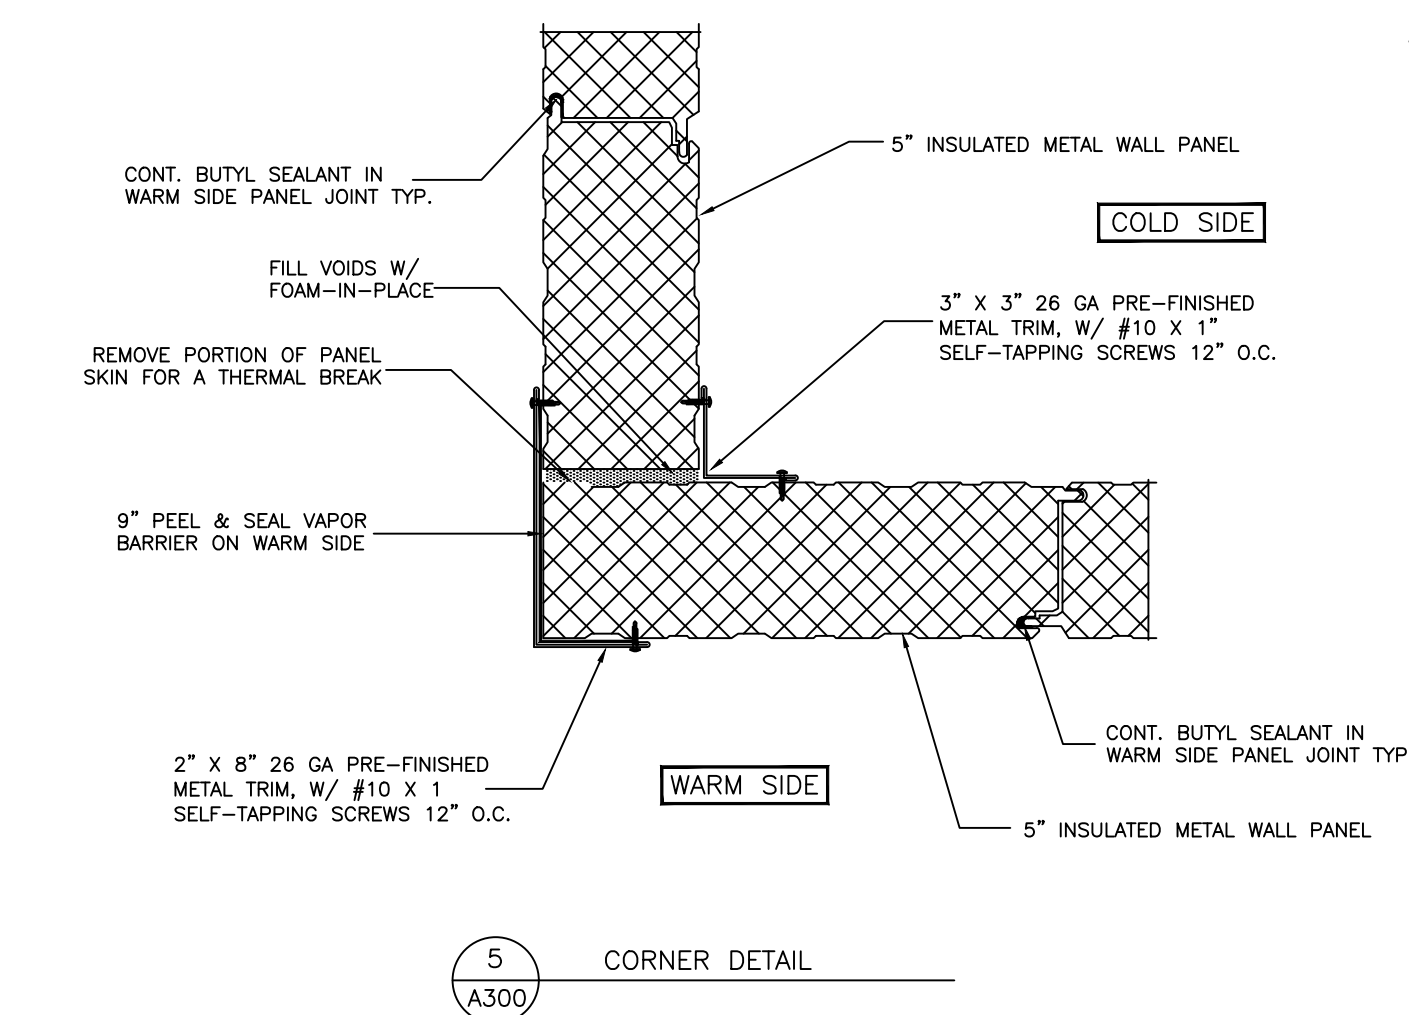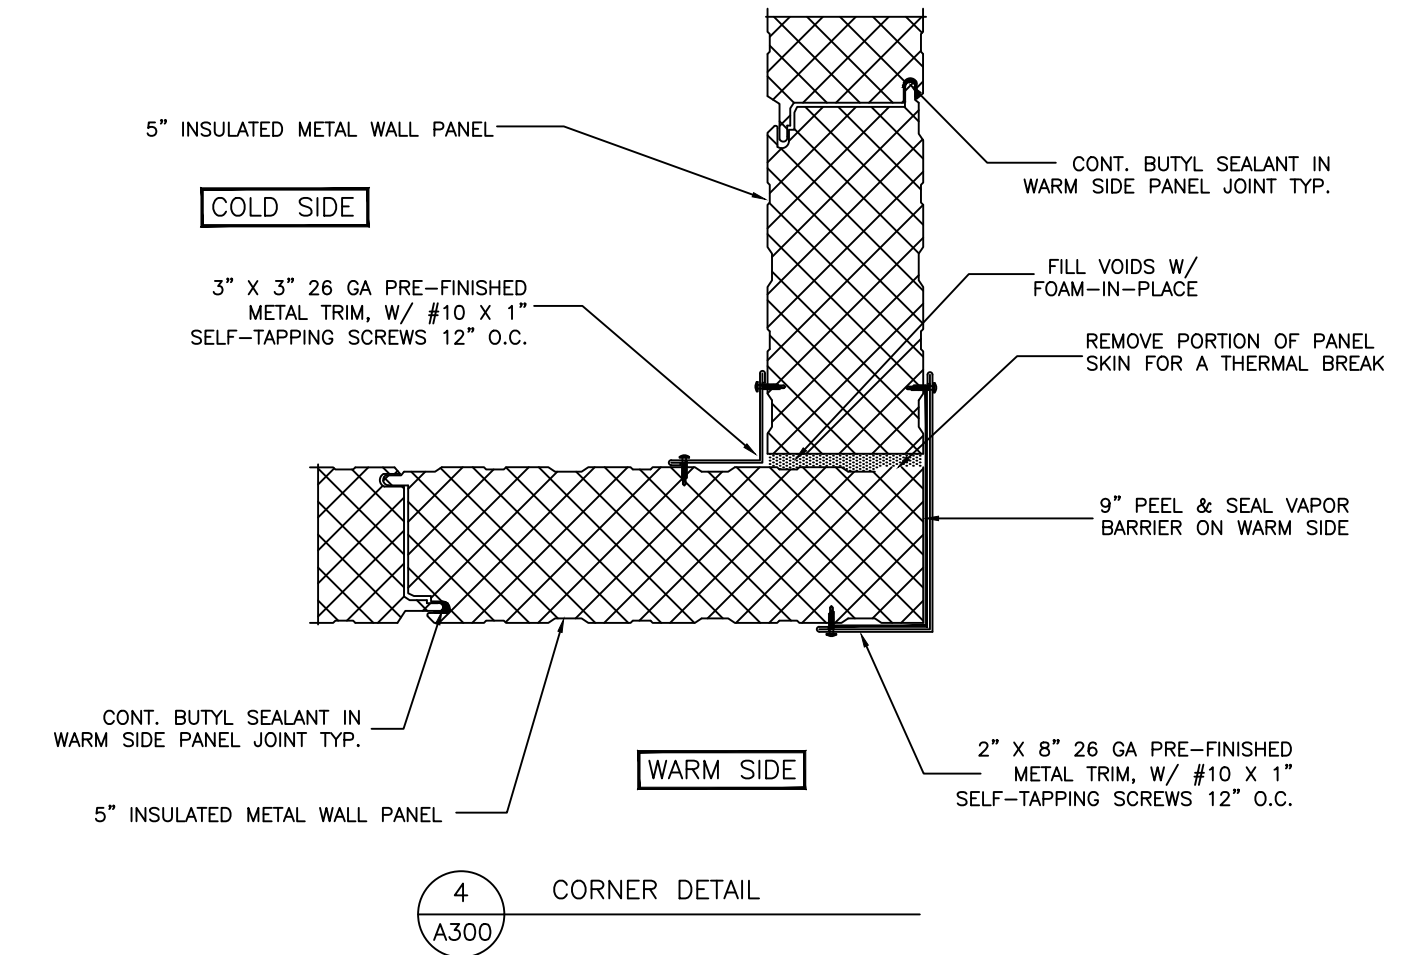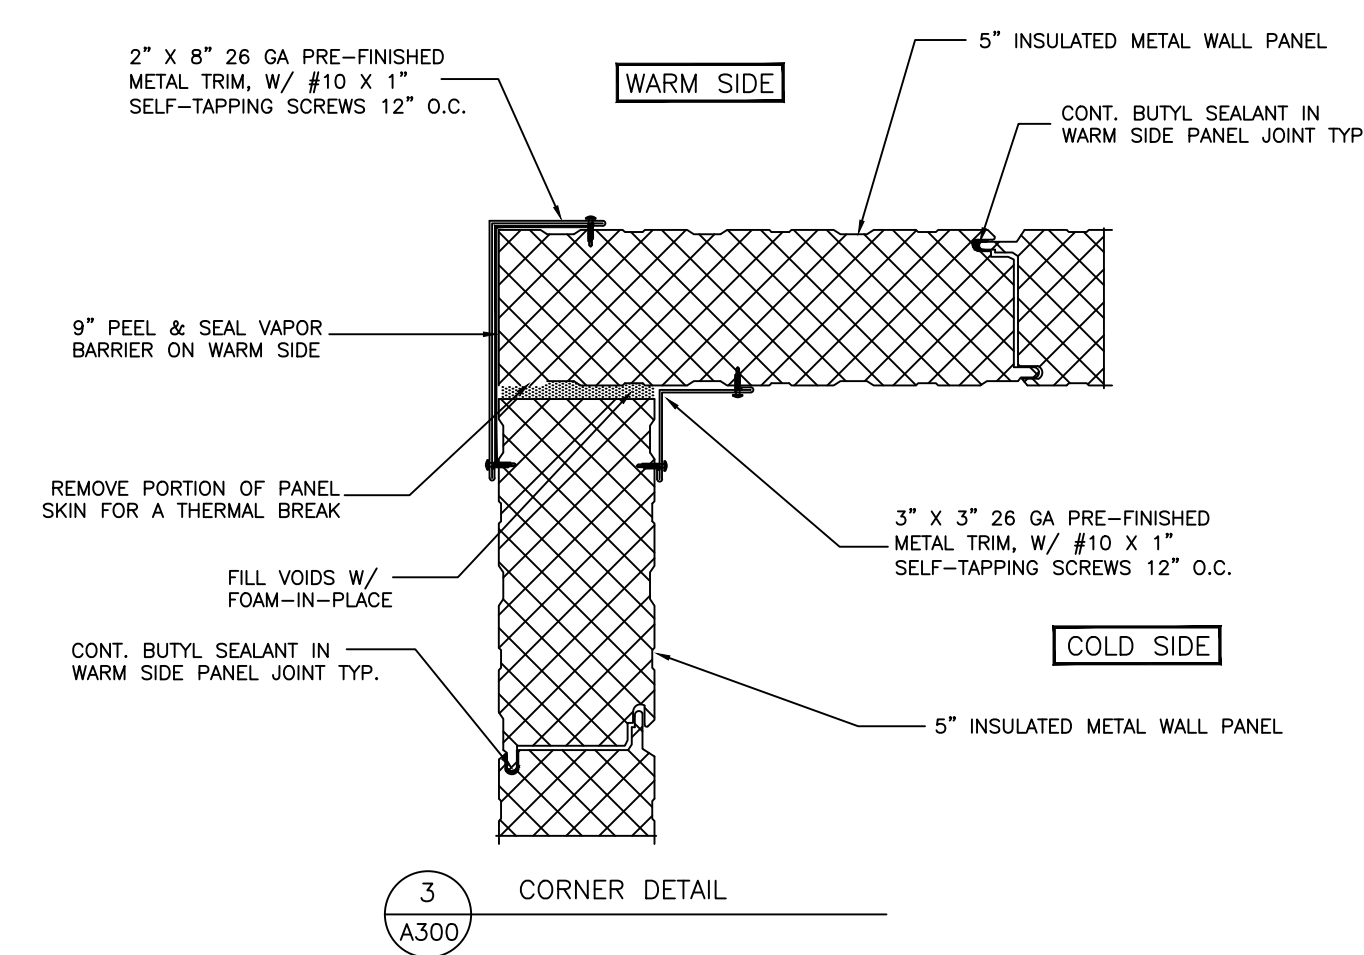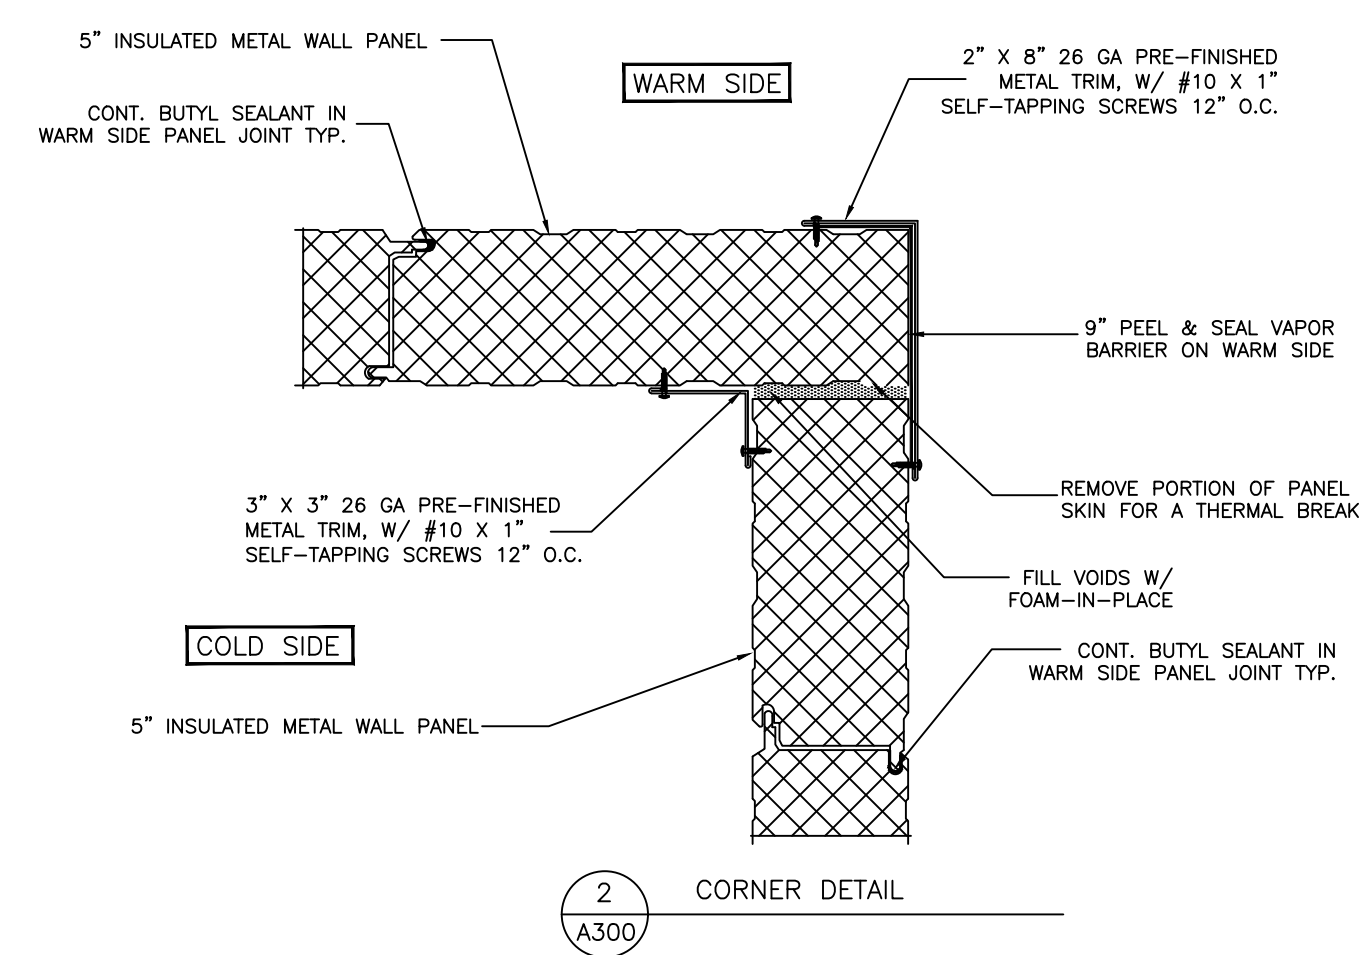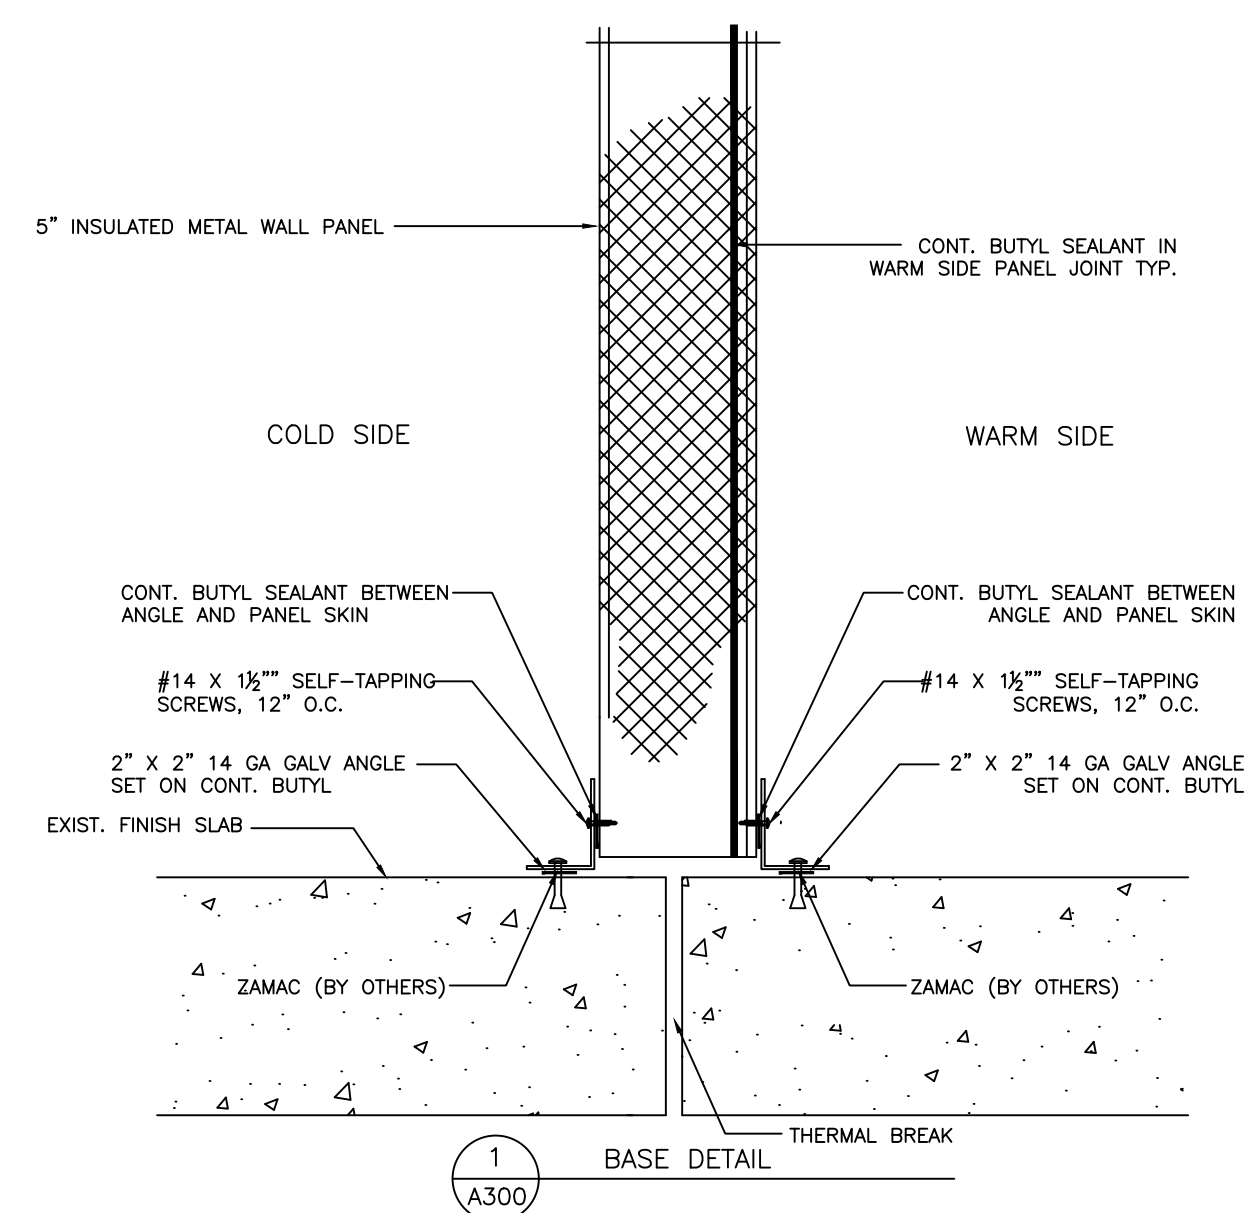

NO.	REVISION	DATE	BY

**Barr Inc.**  
 1423 Planeview Drive  
 Oshkosh, WI 54904  
 920-231-1711 Phone

**40' x 40' x 16'-5"**  
 Drive-In Freezer

TOLERANCES UNLESS SPECIFIED  
 FRACTIONAL DECIMAL ANGLE  
 X/X" ± 1/32" .XX ± .015 X" ± 0'30"  
 .XXX ± .005 X'XX' ± .005'  
 .XXXX ± .001

Draftsmen is not responsible for panel heights, wall heights, dimensions. Contractor to verify all information.

**WALL DETAILS**

DR. BY: KRZ  
 DATE: 8/1/2023  
 SCALE: NTS  
 CHECKED BY:  
 SHEET NO. A300