

Barr Inc.  
1423 Planeview Drive  
Oshkosh, WI 54904  
920-231-1711 Phone

20' x 40' x 8'-4"  
Drive-In Freezer

**DRAWING INDEX**

T.1	TITLE SHEET
A100	FLOOR/CEILING PLAN
A200	INSULATED WALL PANEL ELEVATIONS
A300	INSULATED WALL PANEL DETAILS

REVISION	BY	DATE

Barr Inc.  
1423 Planeview Drive  
Oshkosh, WI 54904  
920-231-1711 Phone

20' x 40' x 8'-4"  
Drive-In Freezer

TOLERANCES UNLESS SPECIFIED  
FRACTIONAL X/X" ± 1/32"  
DECIMAL .XX ± .015  
XXX ± .005  
XXXX ± .001  
X' ± 0'30"  
X" ± 0'05"

Draftsman is not responsible for panel heights, quantities and / or dimensions. Contractor to verify all information.

TITLE

DR.BY: KRZ

DATE: 8/30/2016






SCALE: NTS

CHECKED BY:

SHEET NO.

T.1



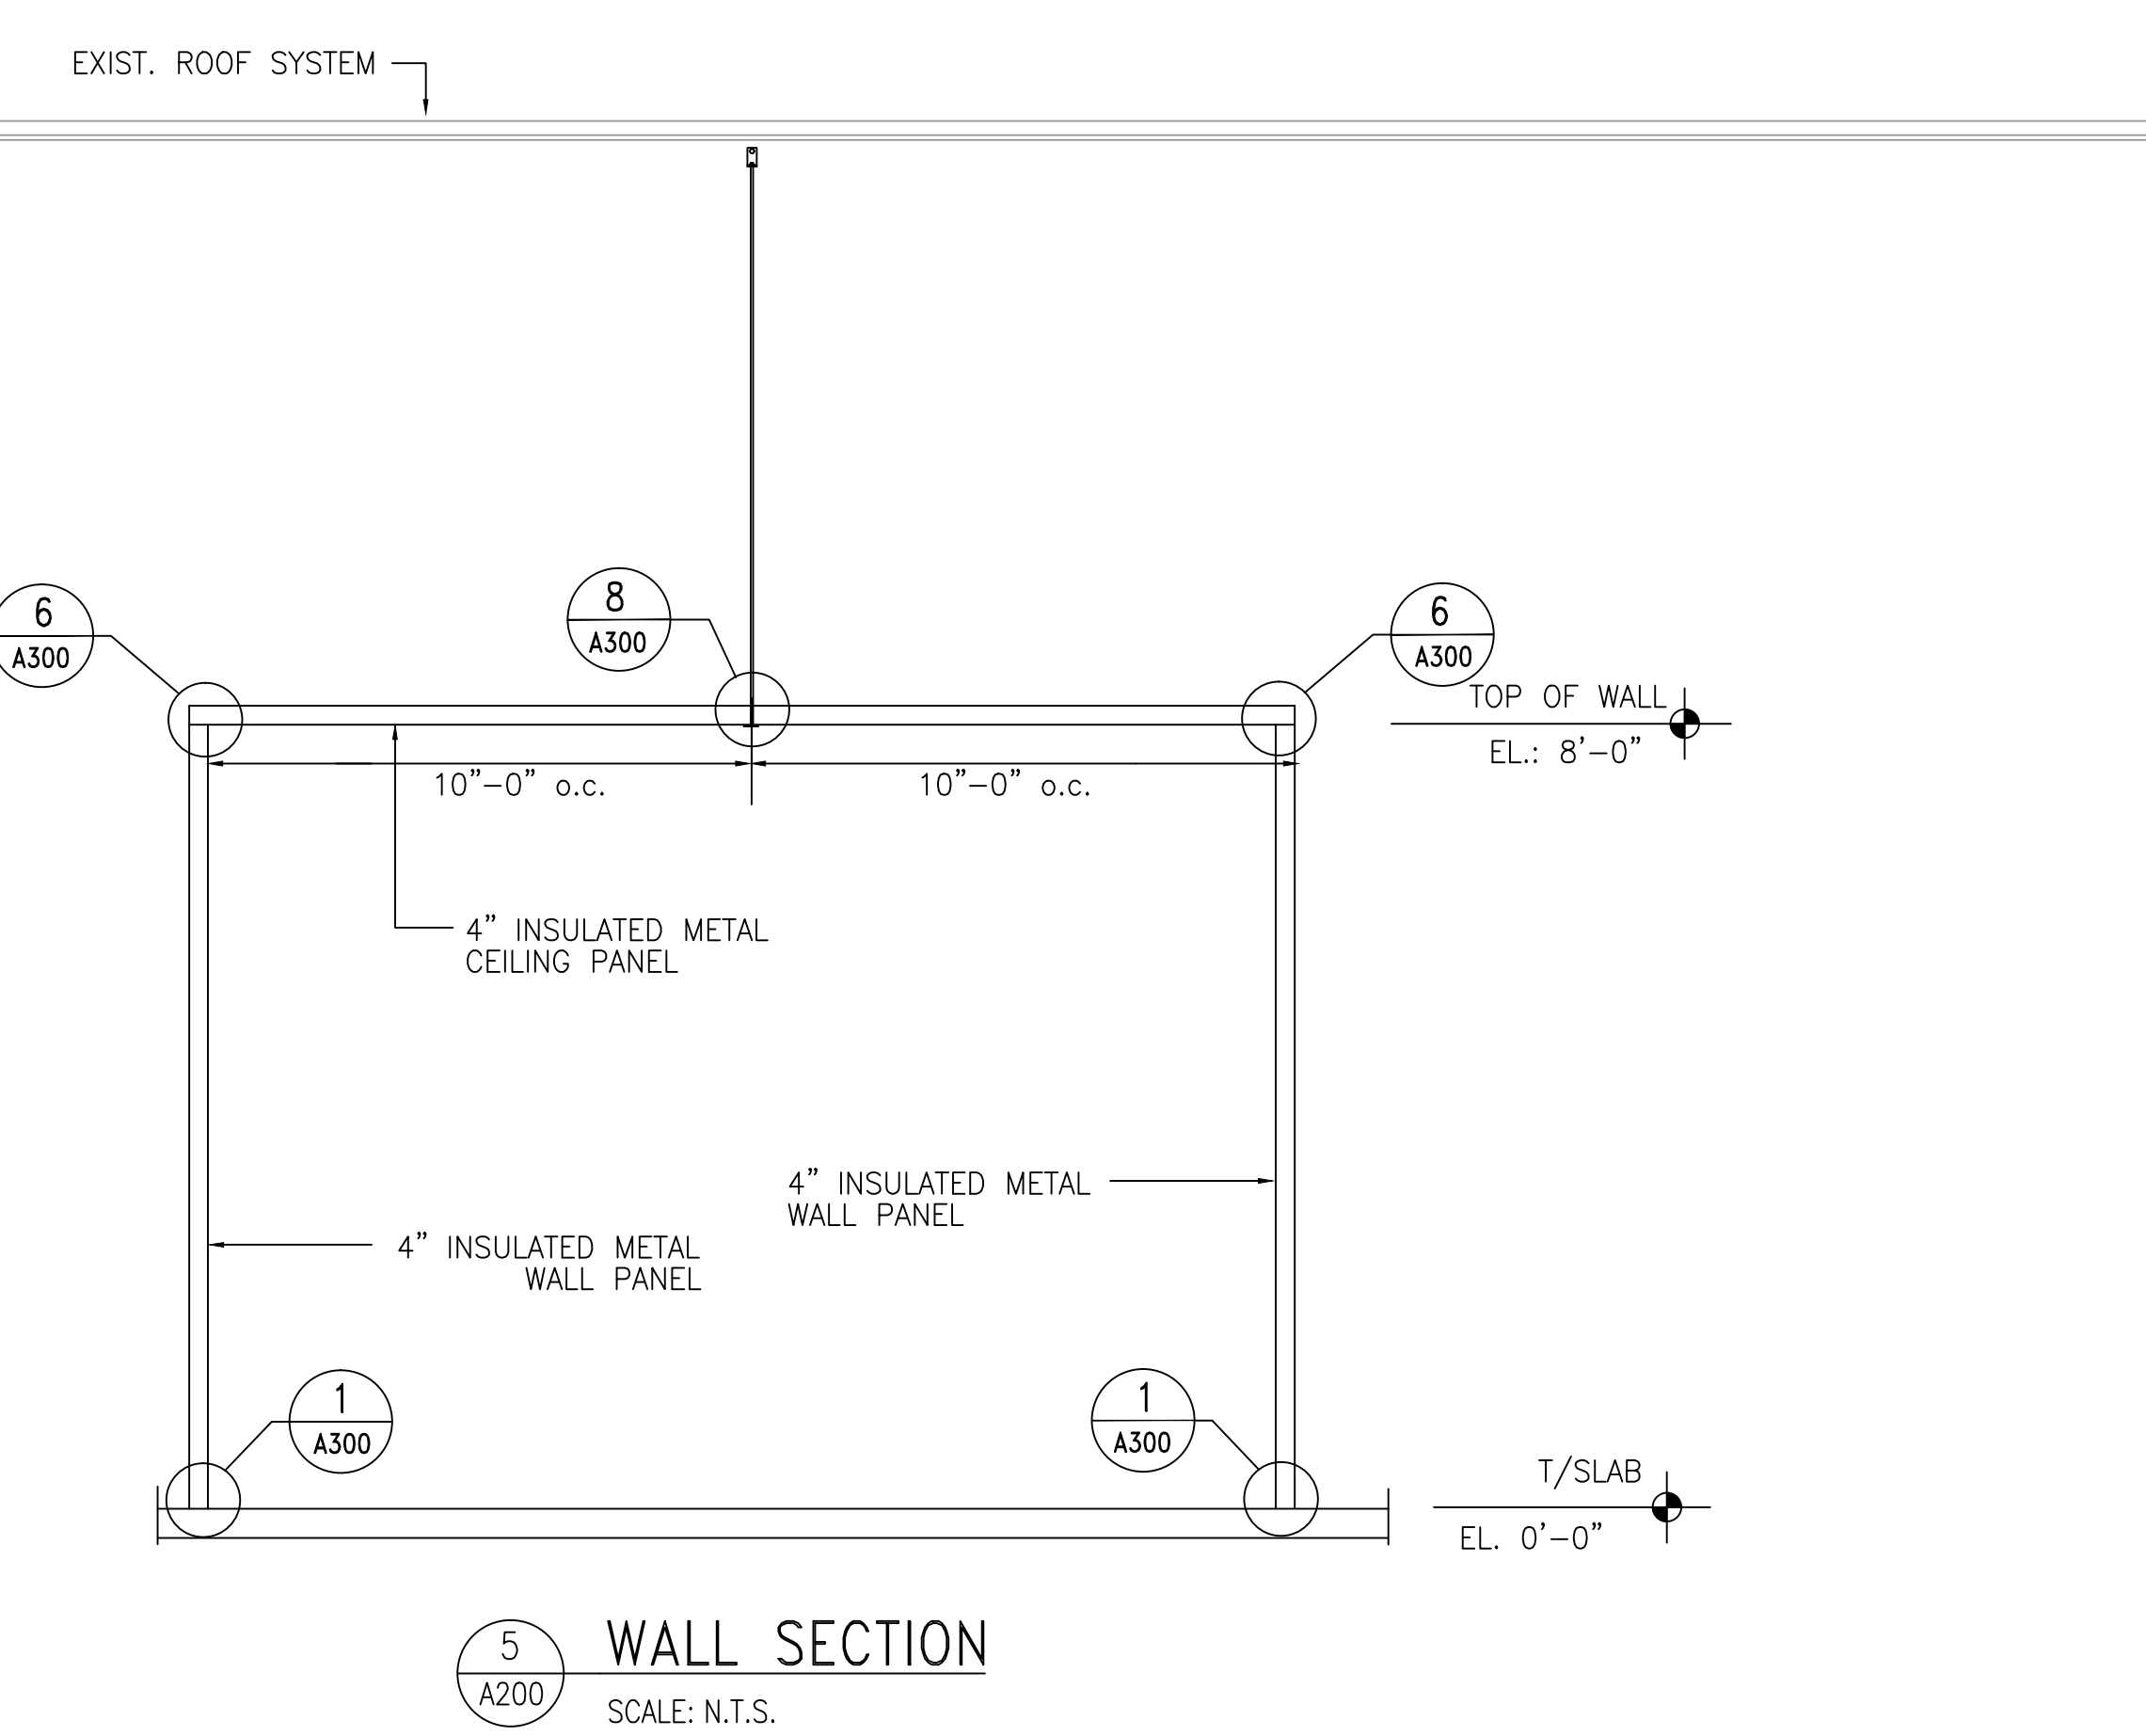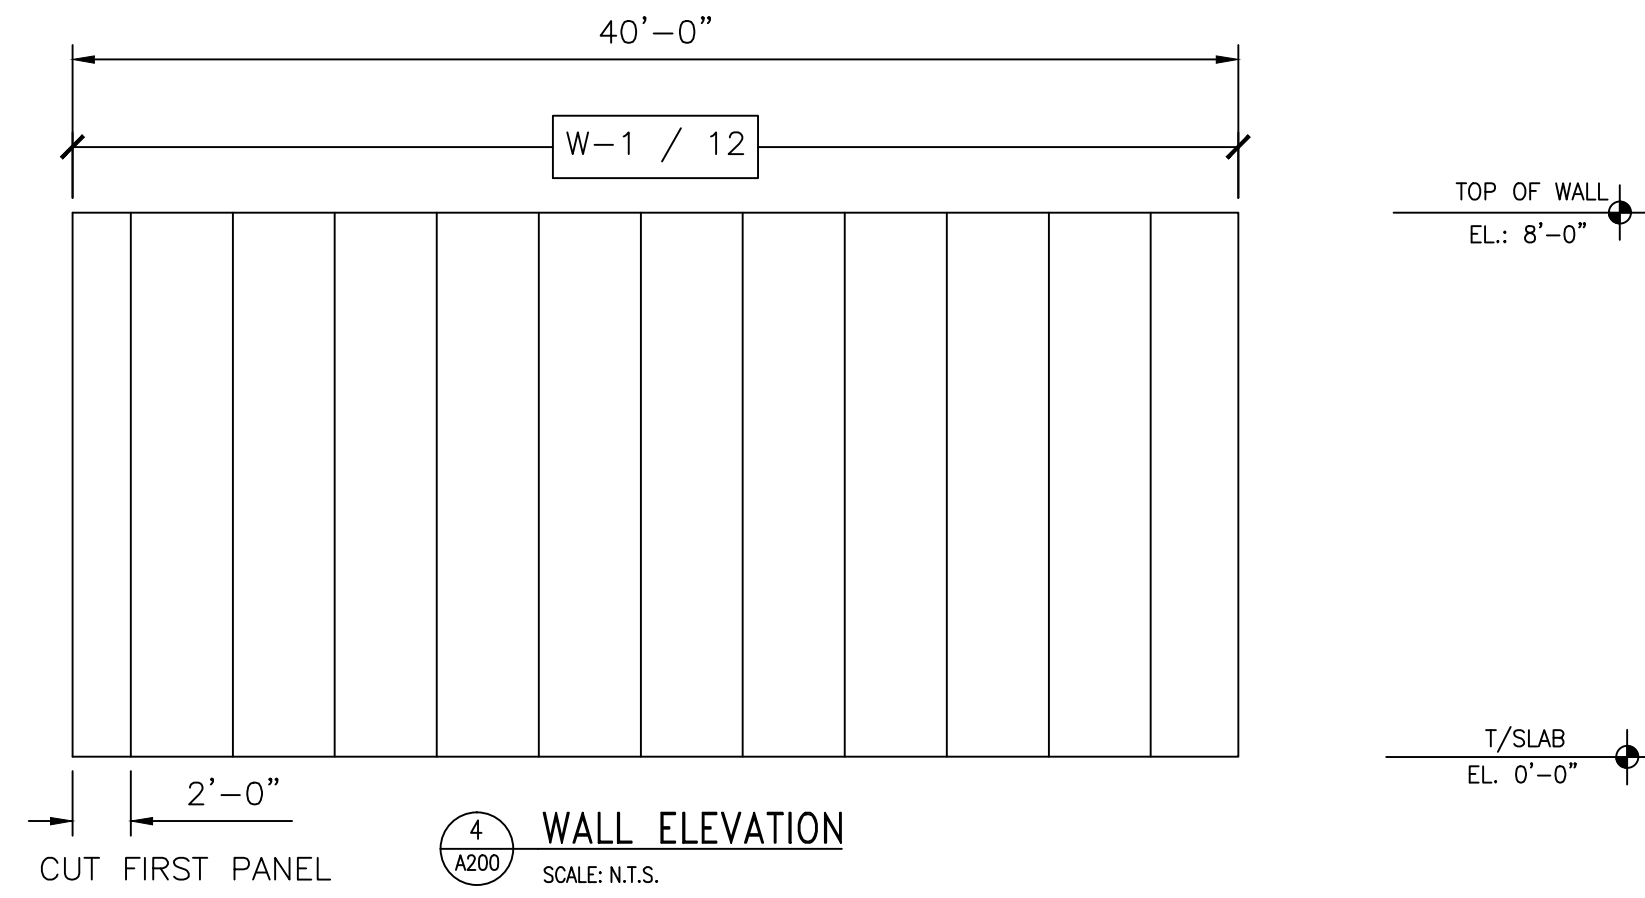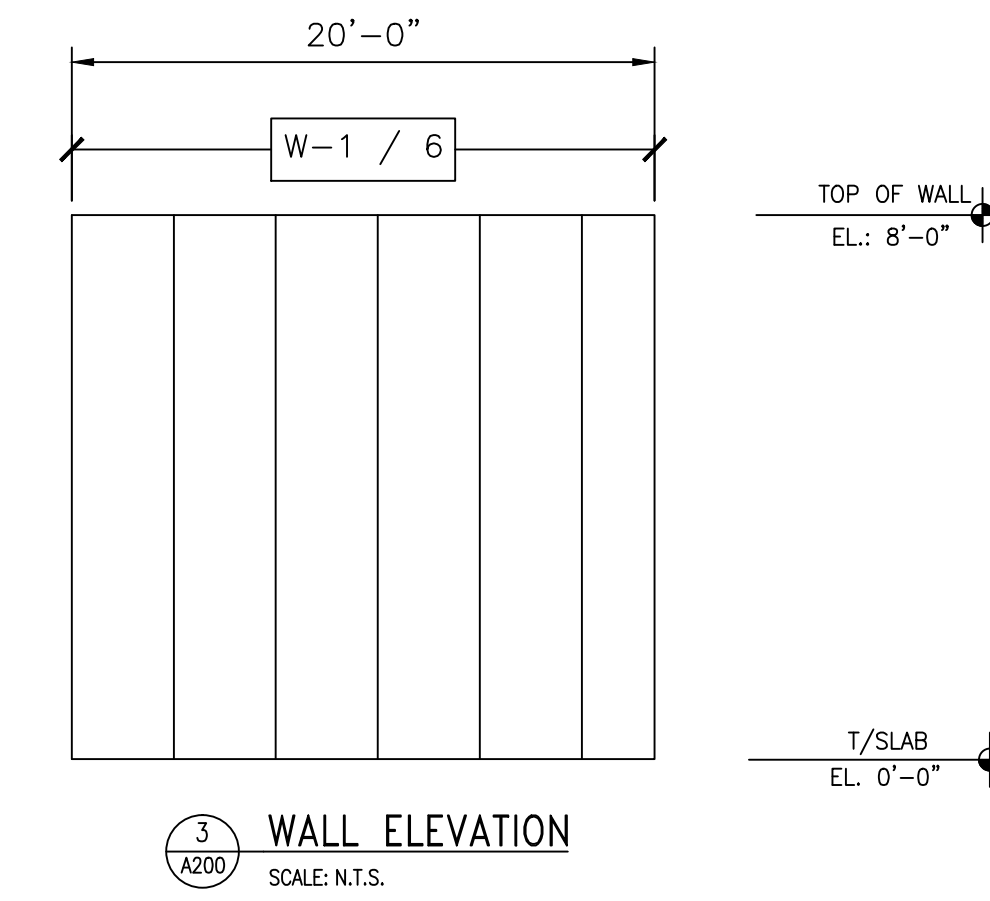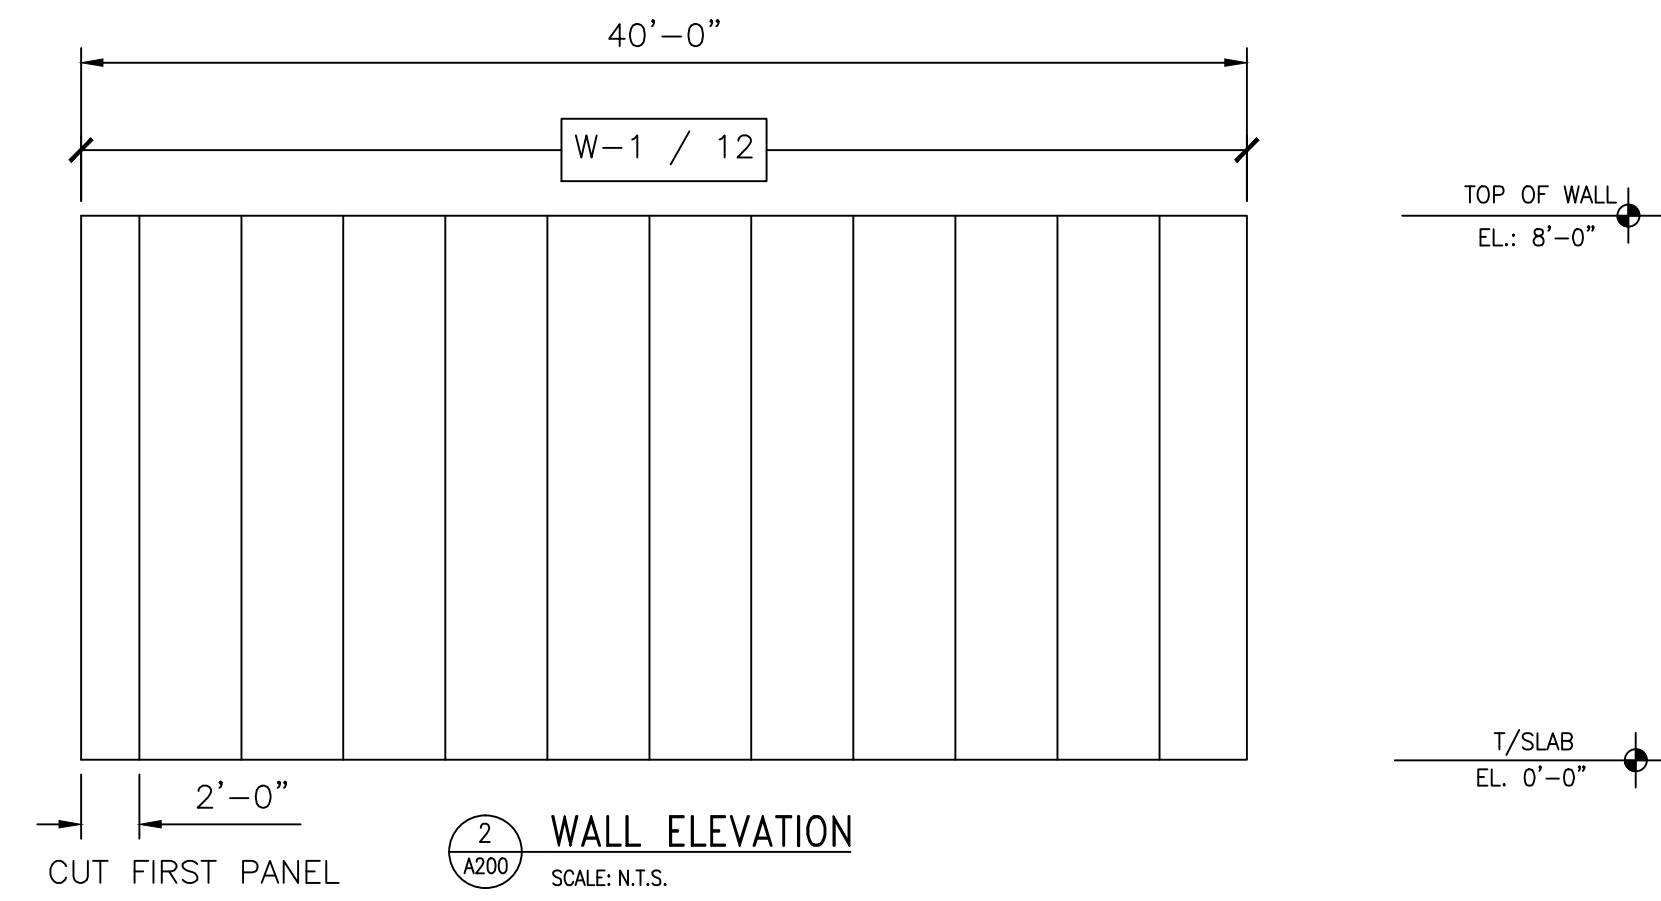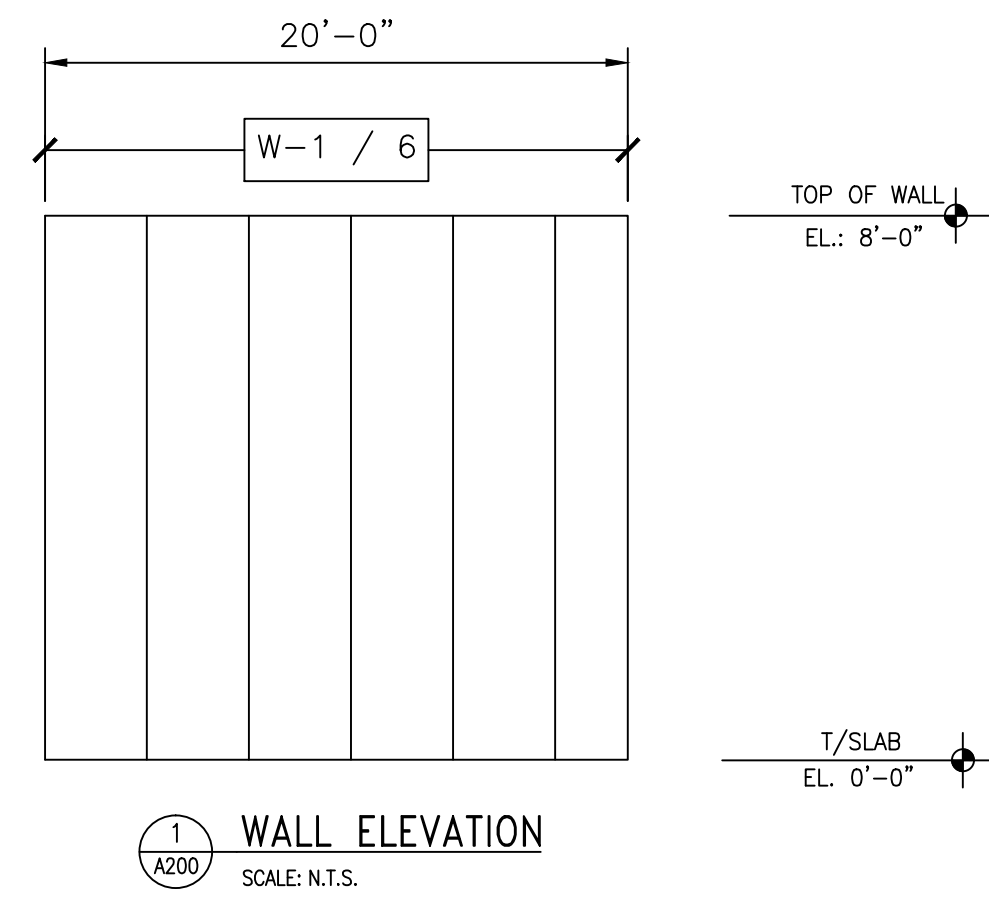

PANEL SCHEDULE

PANEL DESIG.	PANEL HEIGHT	QTY. OF PANELS	PANEL THICK	PANEL SERIES	PANEL COLOR
W-1	8'-0"	36	4"	MESALINE	USDA WHITE
C-2	20'-0"	12	4"	MESALINE	USDA WHITE

NO.	REVISION	BY	DATE


**Barr Inc.**  
1423 Planeview Drive  
Oshkosh, WI 54904  
920-231-1711 Phone

**20' x 40' x 8'-4"**  
Drive-In Freezer


TOLERANCES UNLESS SPECIFIED  
FRACTIONAL .XX ± 1/32" .XXX ± .005" .XXXX ± .001"  
DECIMAL .015 ± 0'030" .05 ± 0'05"  
ANGLE X'X" ± 1'00" X'XX' ± 0'05"  
DRAFTSMAN IS NOT RESPONSIBLE FOR PANEL HEIGHTS, QUANTITIES AND/OR DIMENSIONS. CONTRACTOR TO VERIFY ALL INFORMATION.

**WALL ELEVATIONS**


DR. BY: KRZ  
DATE: 8/30/2016  
SCALE: NTS  
CHECKED BY:  
SHEET NO. A200

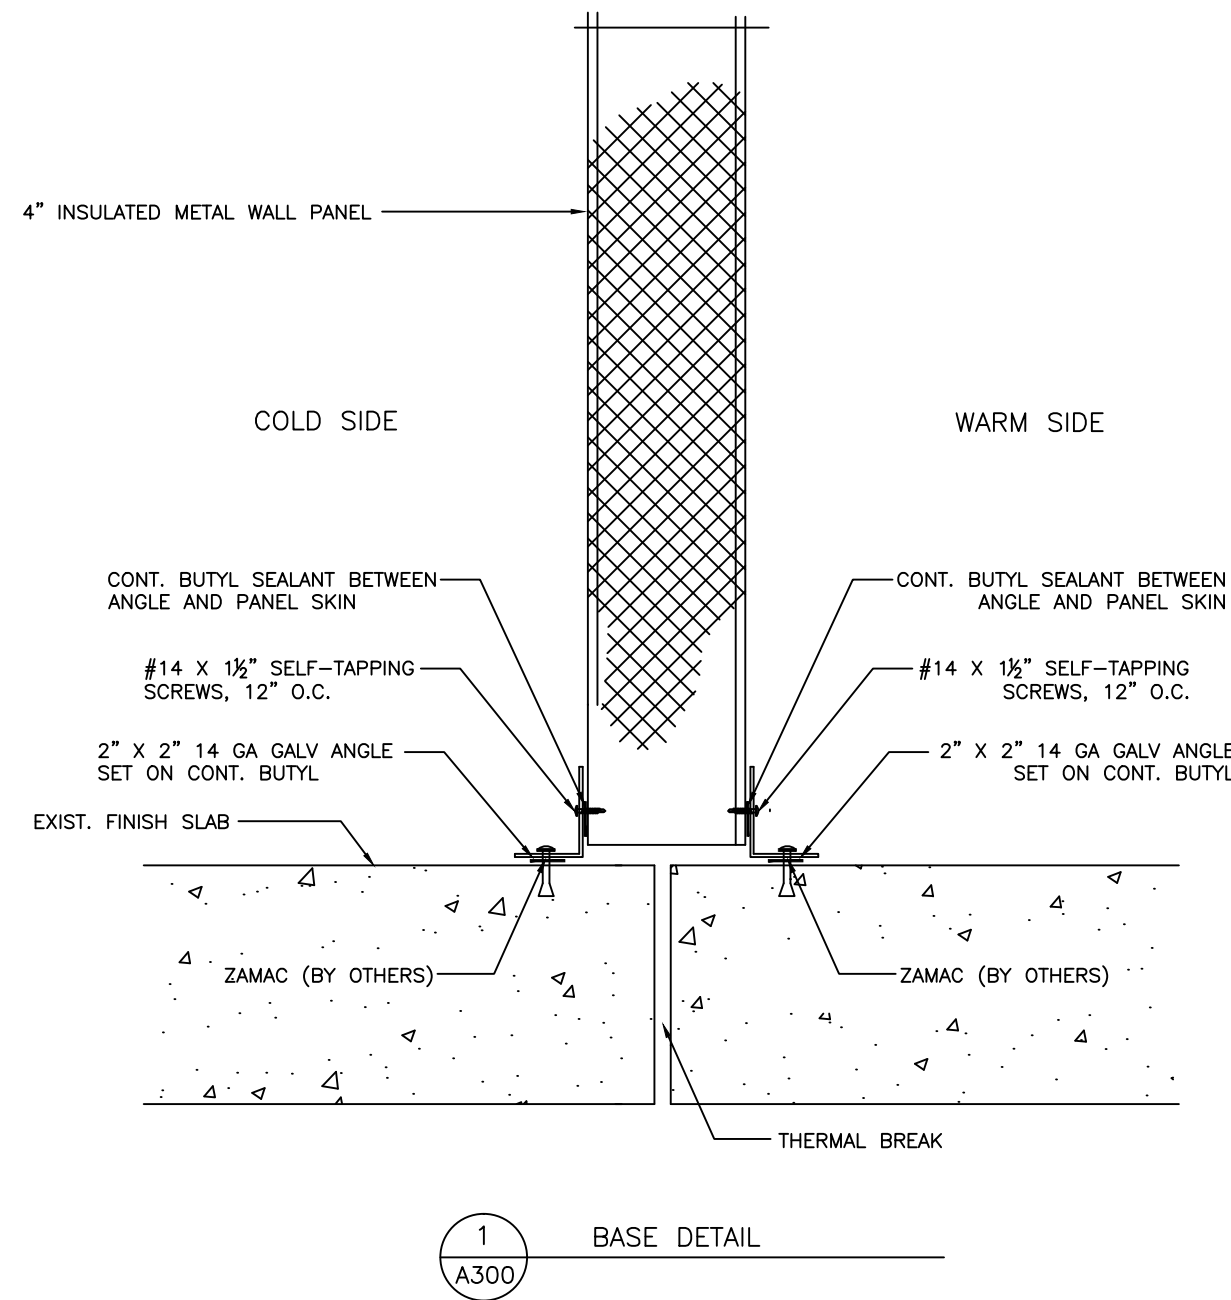


1 BASE DETAIL  
A300

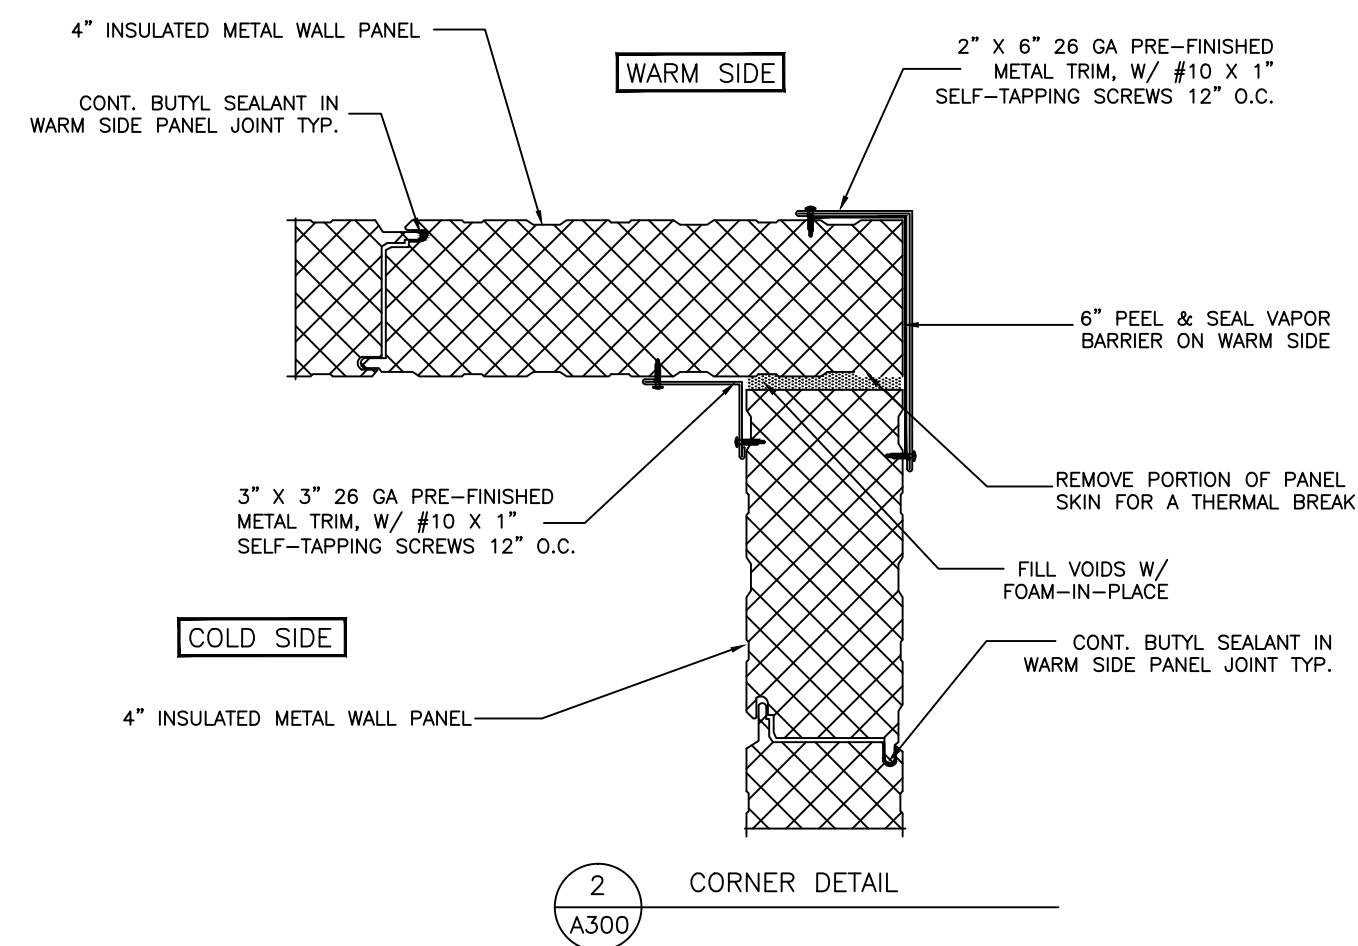


2 CORNER DETAIL  
A300

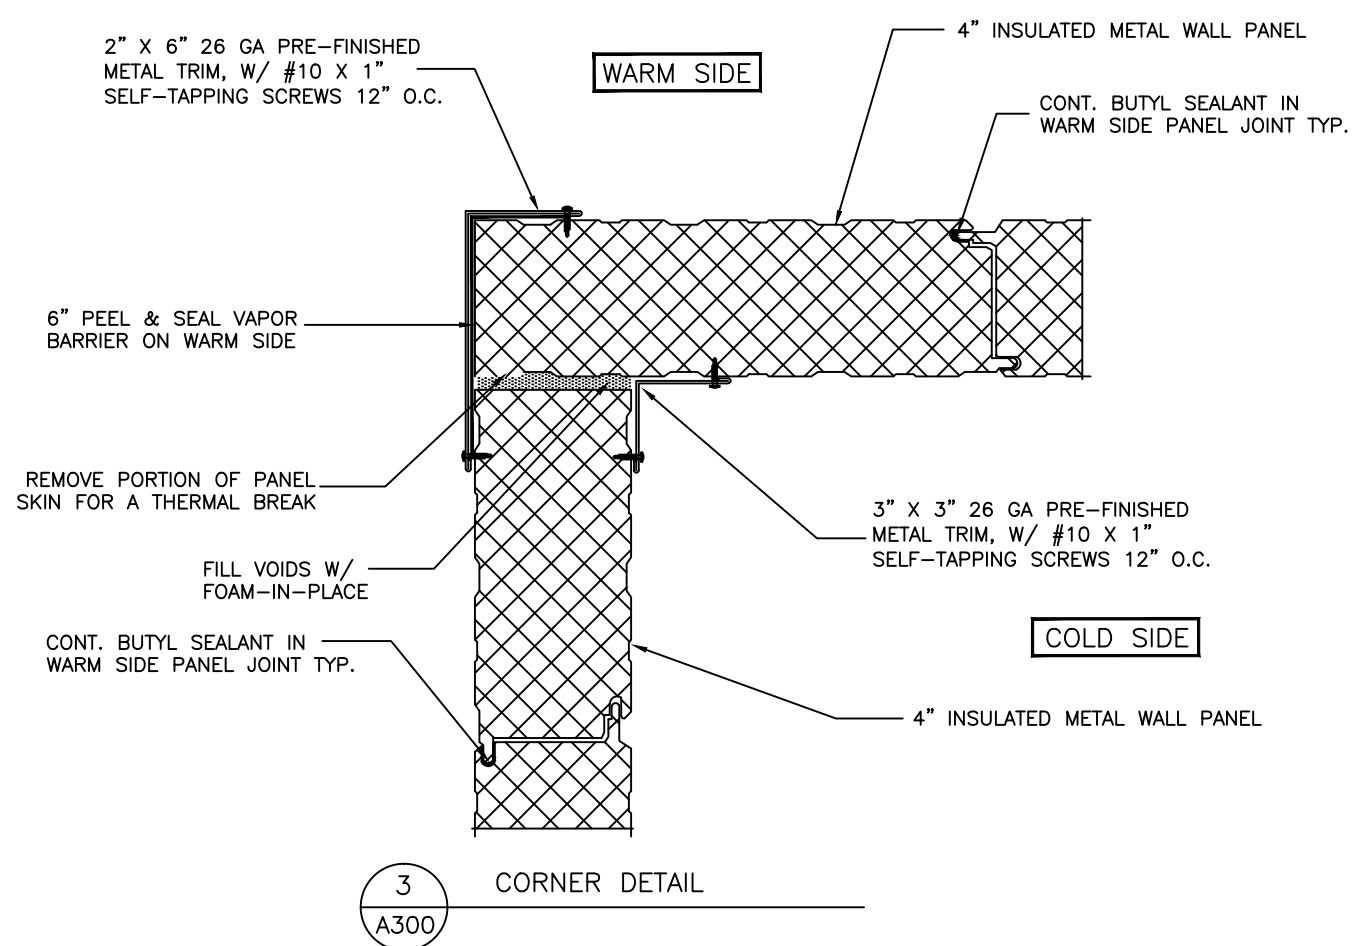


3 CORNER DETAIL  
A300

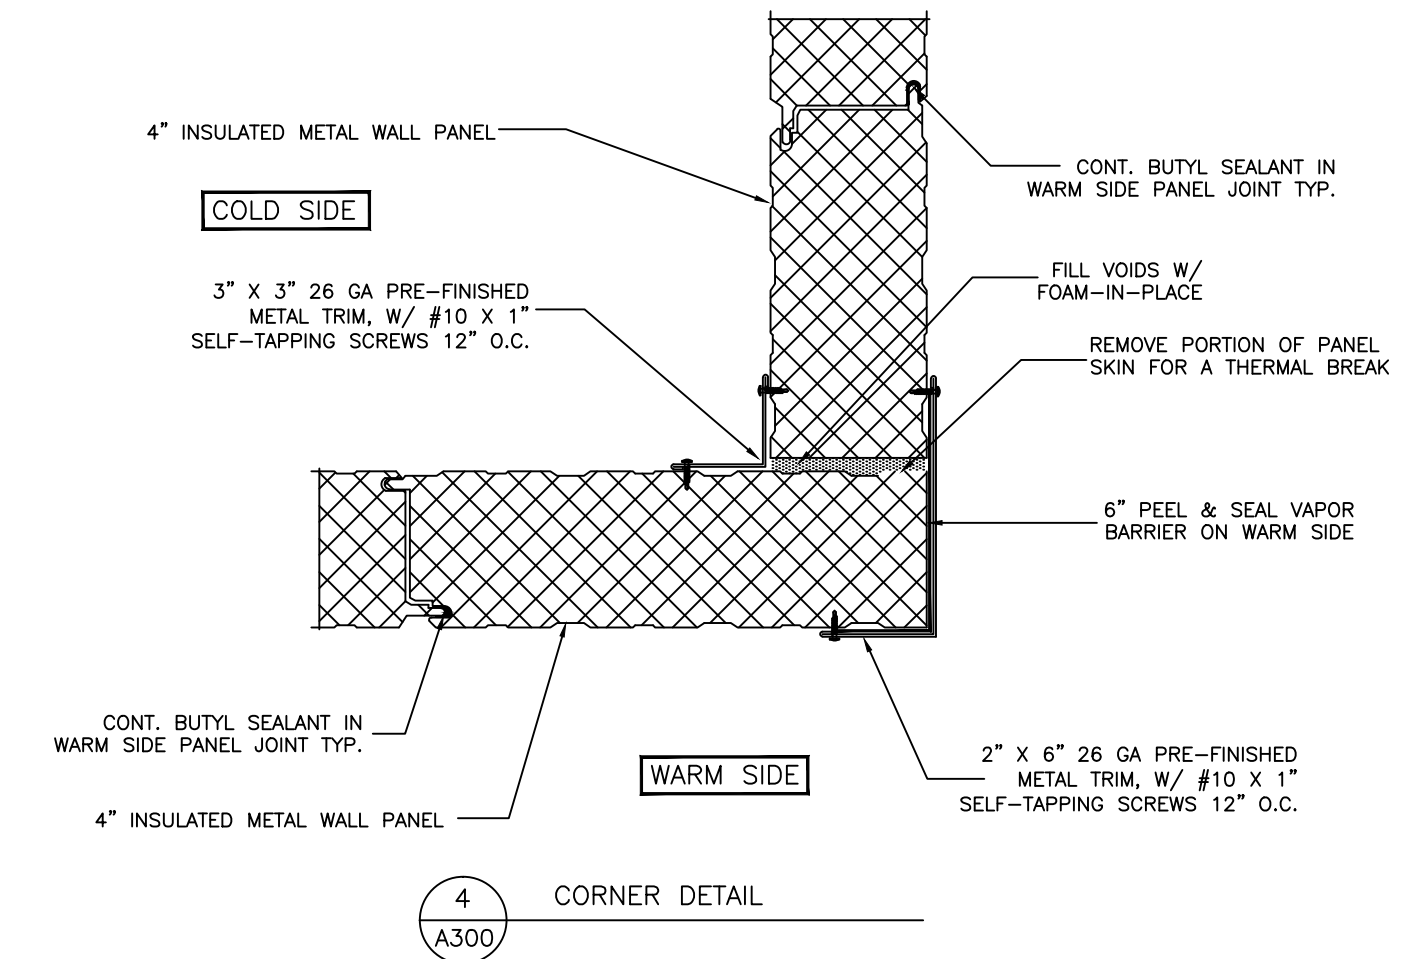

4 CORNER DETAIL  
A300

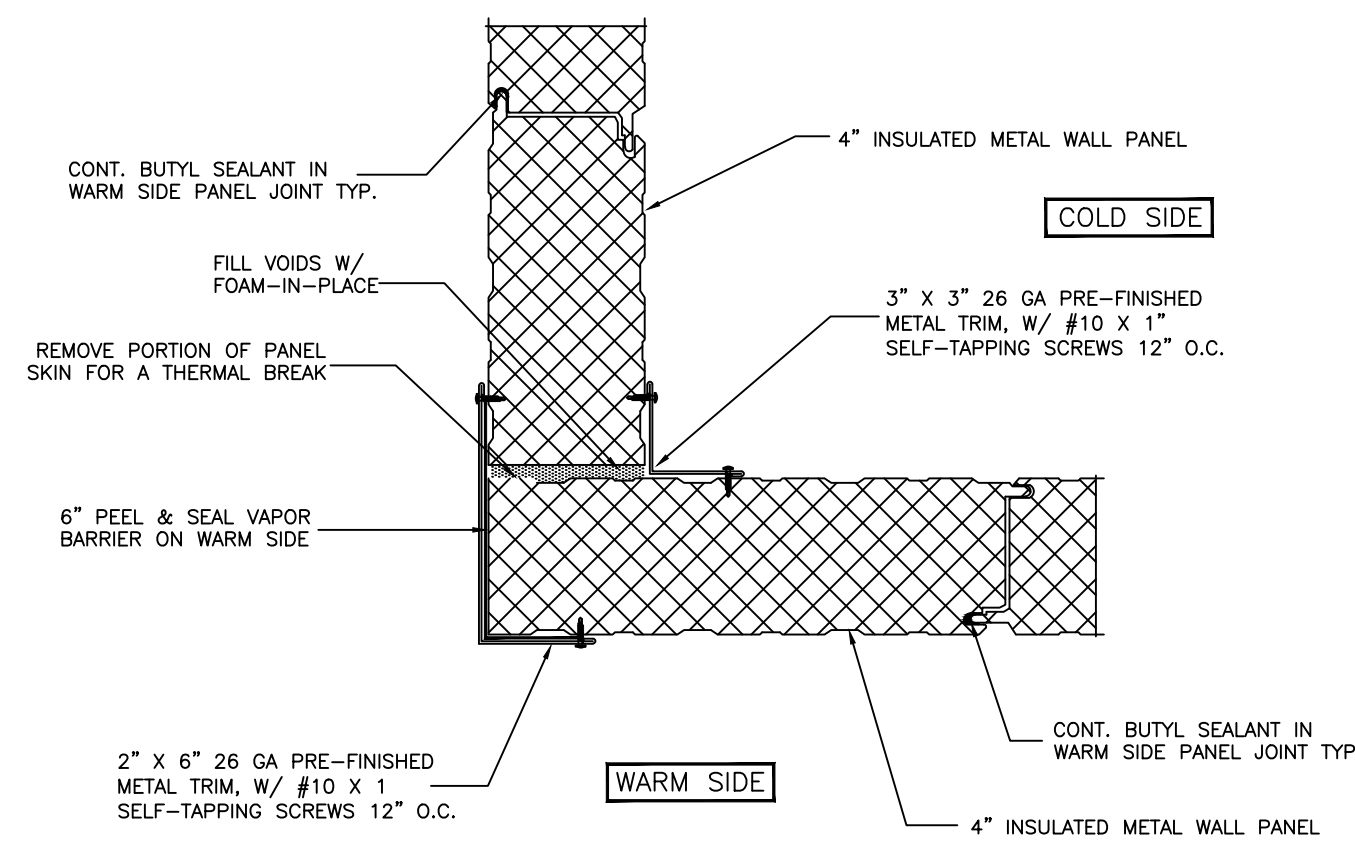


5 CORNER DETAIL  
A300

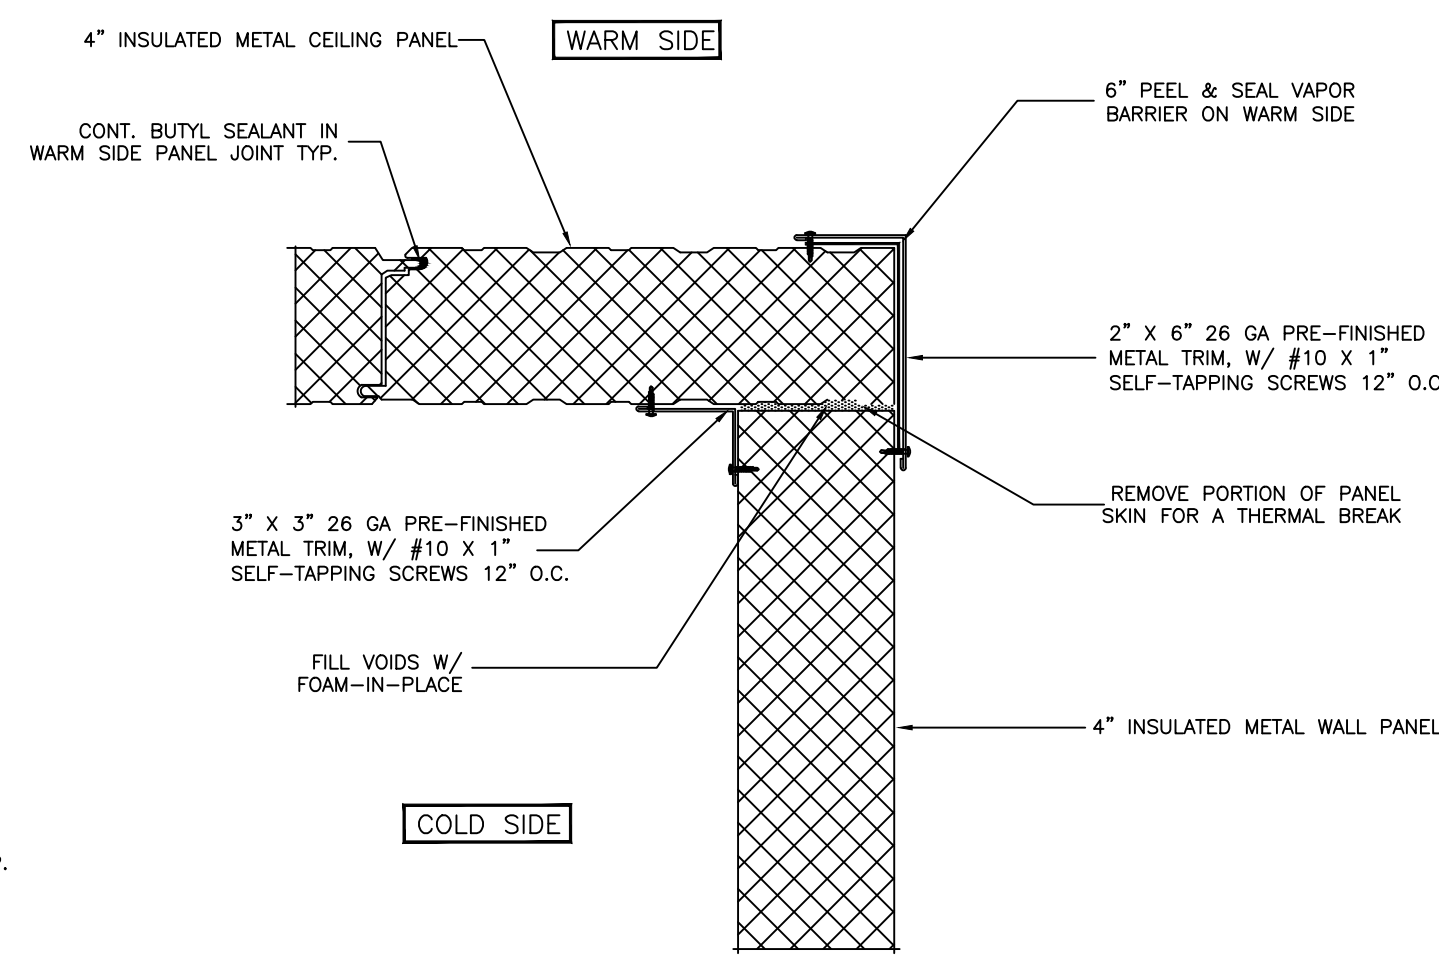

6 WALL / CEILING DETAIL  
A300

7 NOT USED  
A300

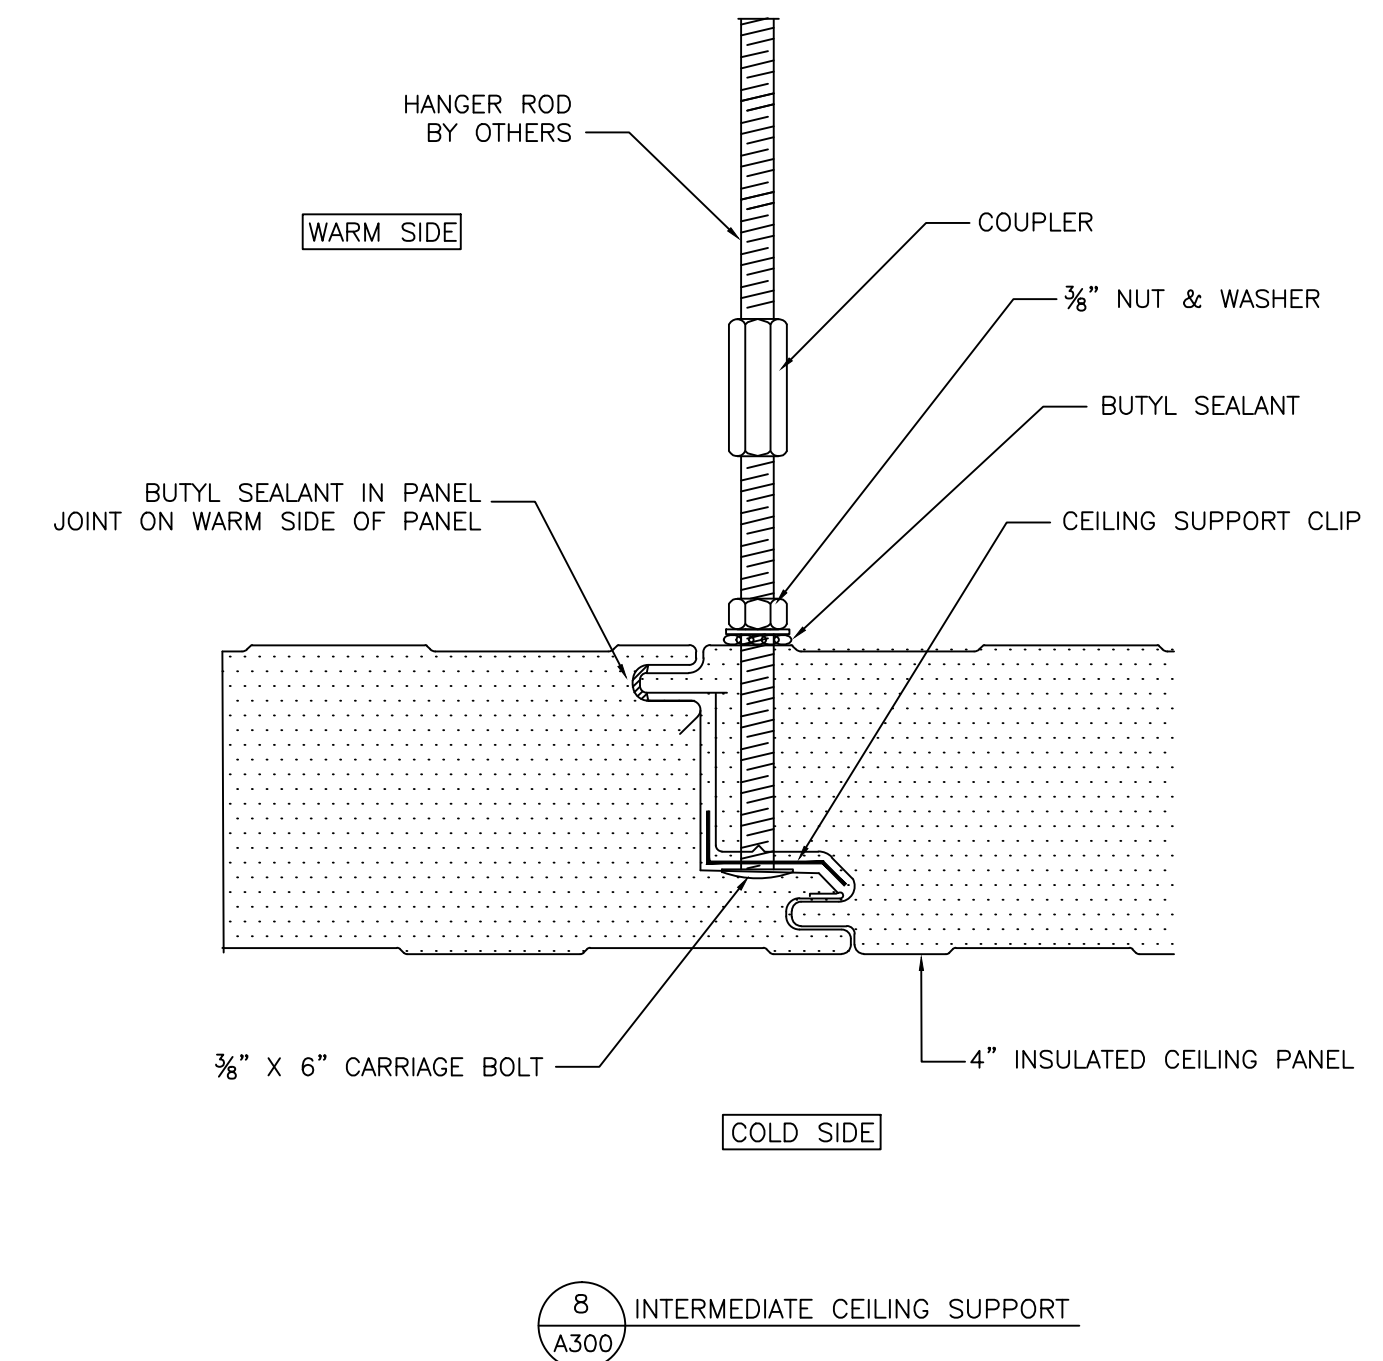

8 INTERMEDIATE CEILING SUPPORT  
A300

NO.	DATE	BY

Barr Inc.  
1423 Planeview Drive  
Oshkosh, WI 54904  
920-231-1711 Phone

20' x 40' x 8'-4"  
Drive-In Freezer

TOLERANCES UNLESS SPECIFIED  
FRACTIONAL DECIMAL .015 X .030' ANGLE  
X/X" ± 1/32" .XX ± .015 X .XX ± 0'05"  
    .XXX ± .005 X'X' ± 0'05"  
    .XXXX ± .001

Draftsman is not responsible for panel heights, quantities and/or dimensions. Contractor to verify all information.

WALL DETAILS

DR. BY: KRZ  
DATE: 8/30/2016  
SCALE: NTS  
CHECKED BY:  
SHEET NO. A300