

# Barr Inc.

1423 Planeview Drive  
Oshkosh, WI 54904  
920-231-1711 Phone






## 20' x 30' x 10'-4" Drive-In Cooler

### DRAWING INDEX

T.1	TITLE SHEET
A100	FLOOR/CEILING PLAN
A200	INSULATED WALL PANEL ELEVATIONS
A300	INSULATED WALL PANEL DETAILS

Barr Inc. 1423 Planeview Drive Oshkosh, WI 54904 920-231-1711 Phone		20' x 30' x 10'-4" Drive-In Cooler		<small>TOLERANCES UNLESS SPECIFIED</small> <small>FRACTIONAL</small> 1/32" ± 1/32"    .015" ± .015"    .005" ± .005"    .001" ± .001" <small>DECIMAL</small> .XX ± .015"    .XXX ± .005"    .XXX ± .005"    .XXX ± .005" <small>ANGLE</small> X ± 0°30'    XXX ± 0°05'    XXX ± 0°05'	
TITLE		TITLE		<small>Draftsman is not responsible for panel heights, quantities and / or dimensions. Contractor to verify all information.</small>	
DR.BY: KRZ		DATE: 8/30/2016		SCALE: NTS	
SHEET NO. T.1		CHECKED BY:		BY	
				DATE	



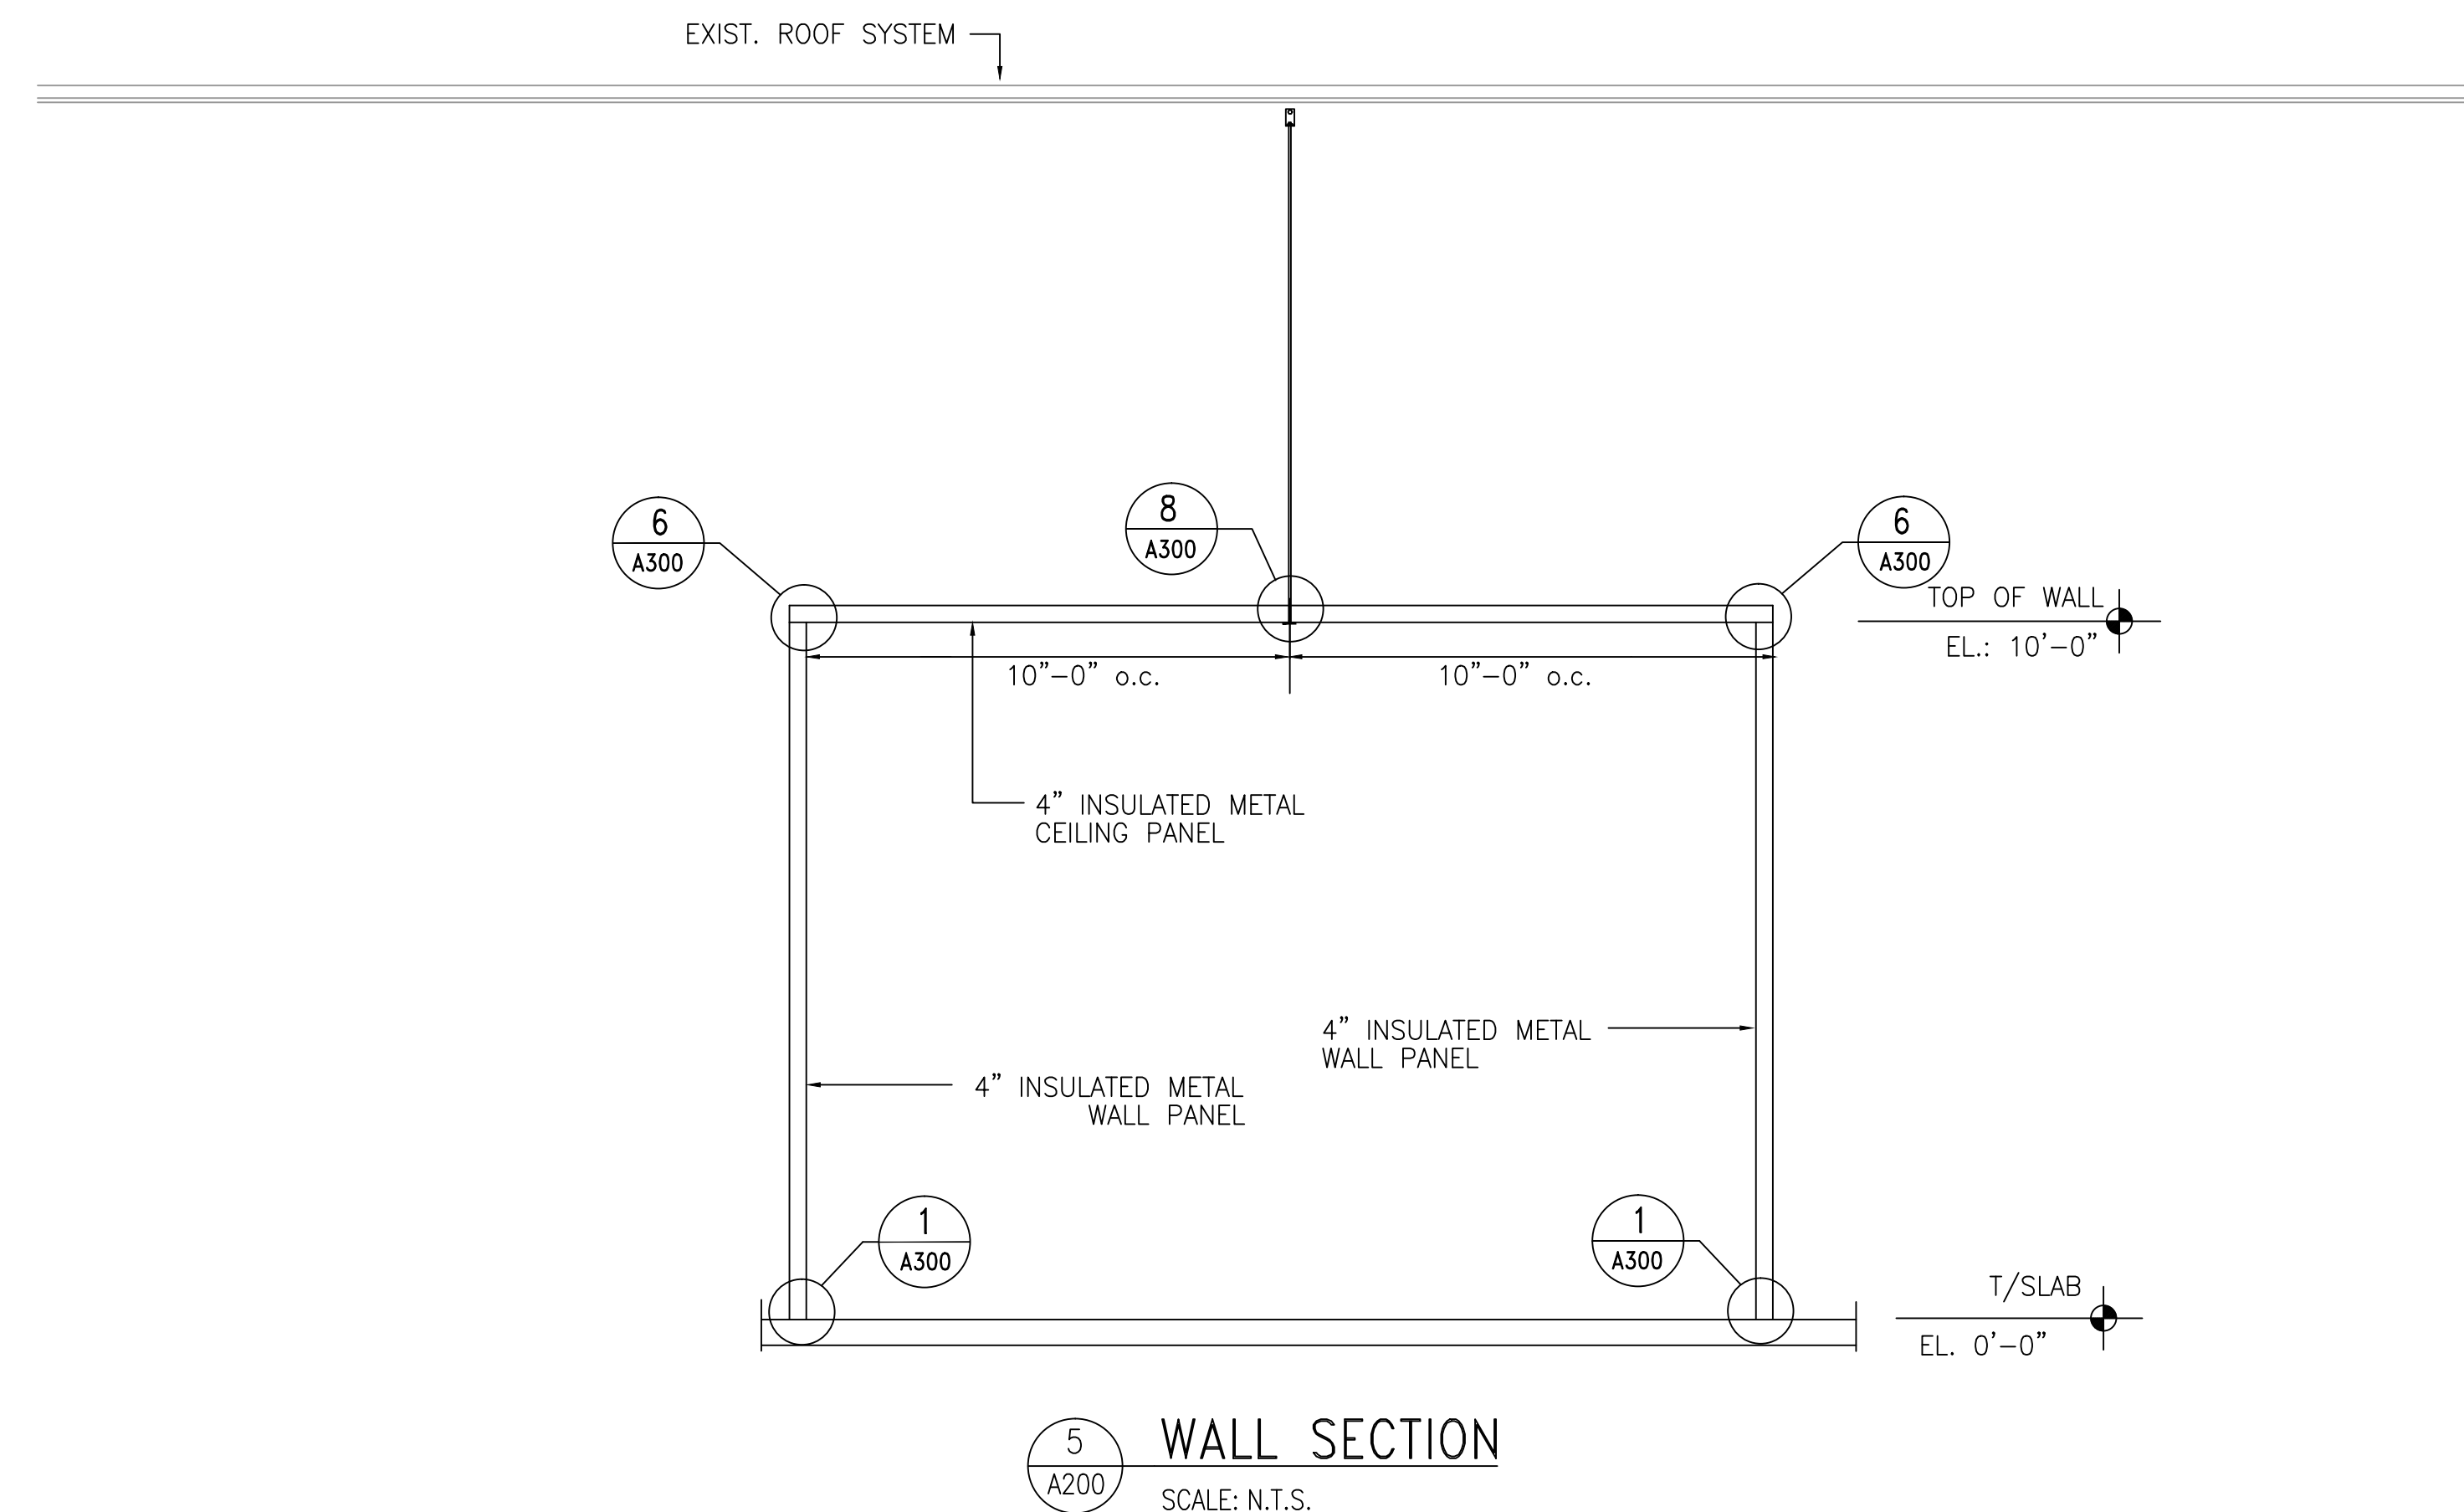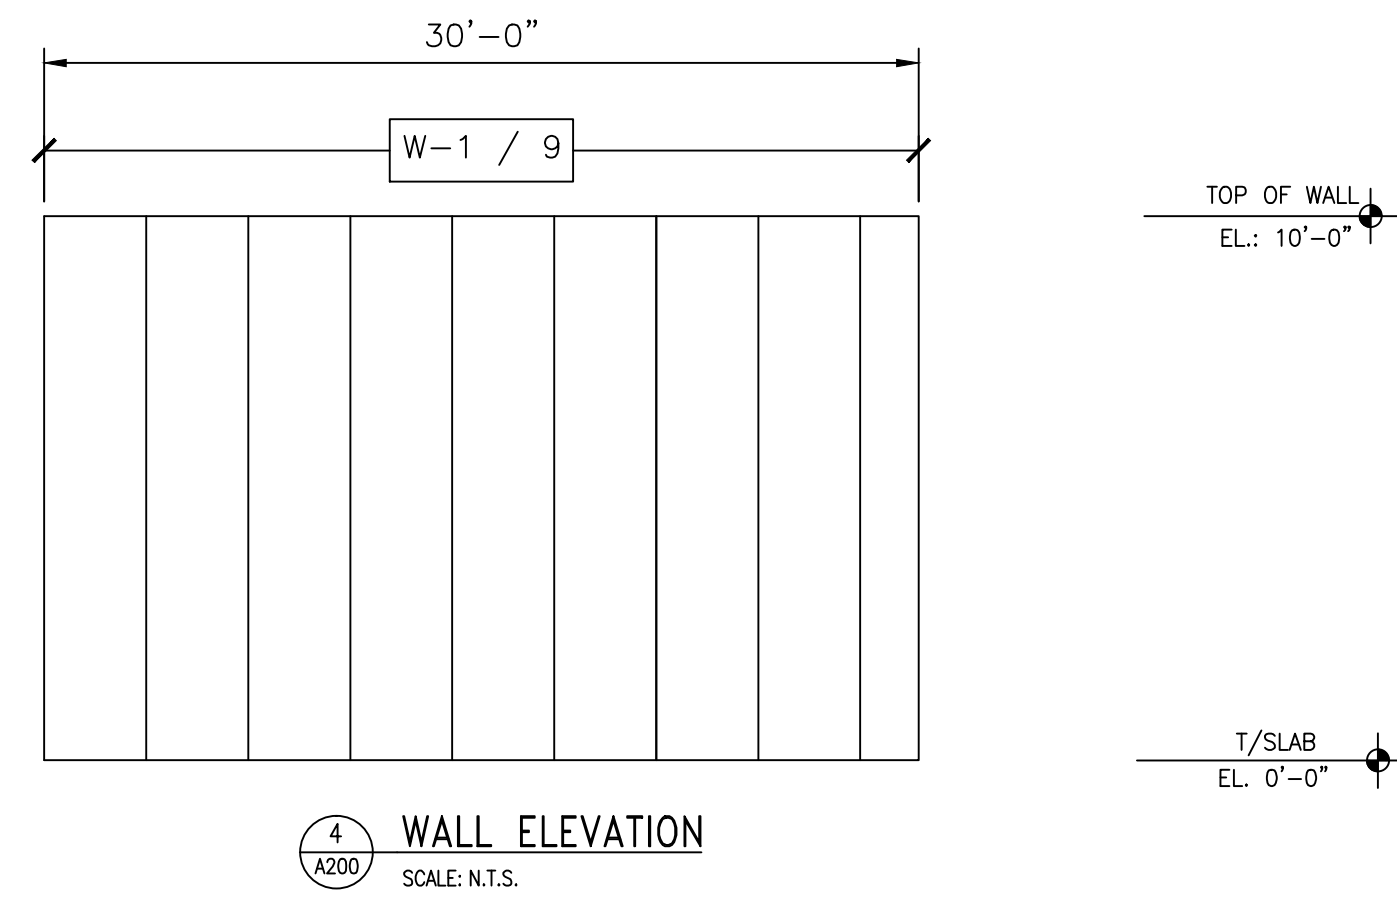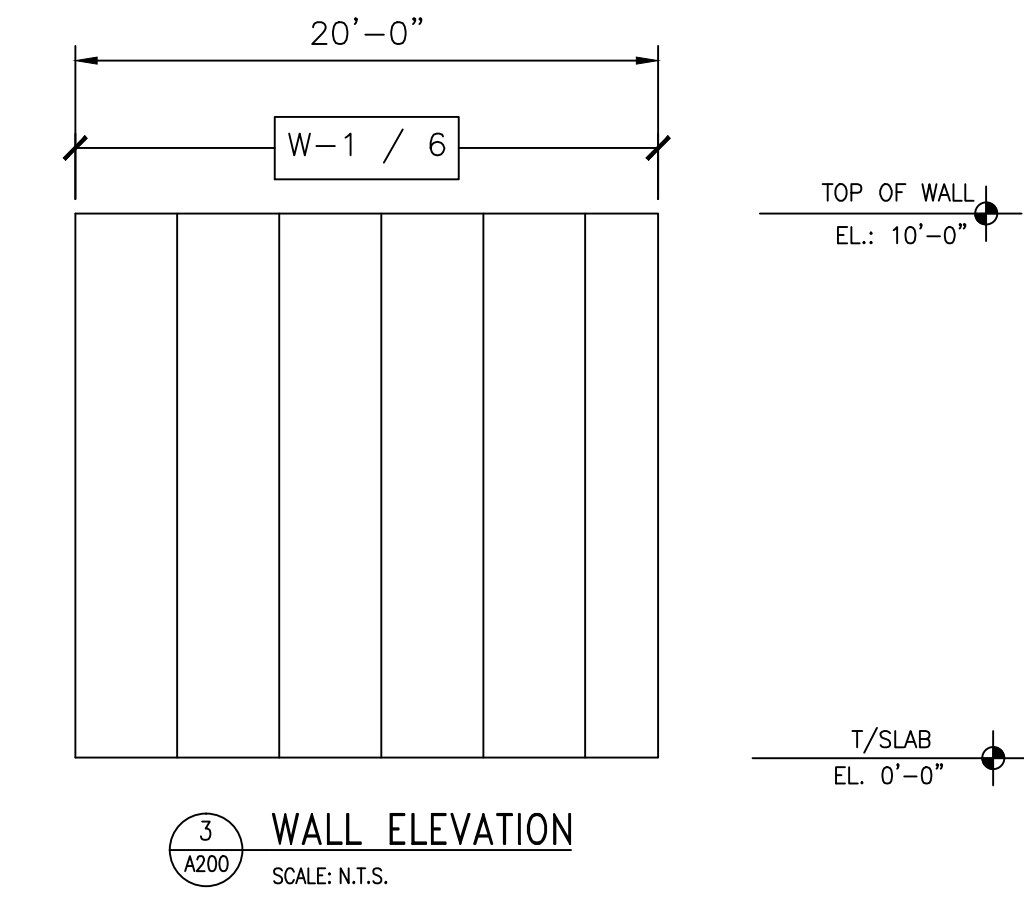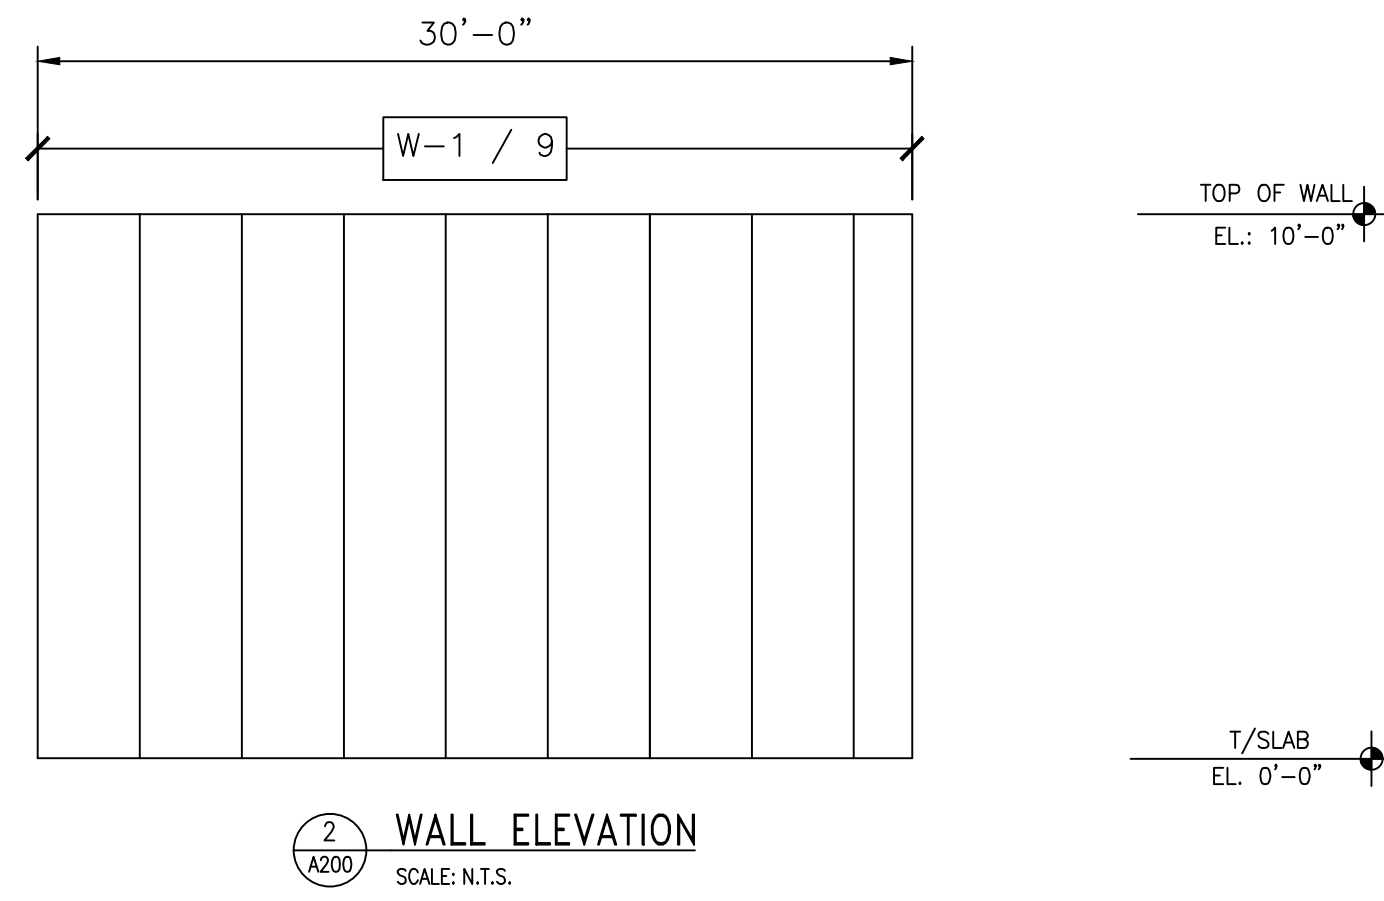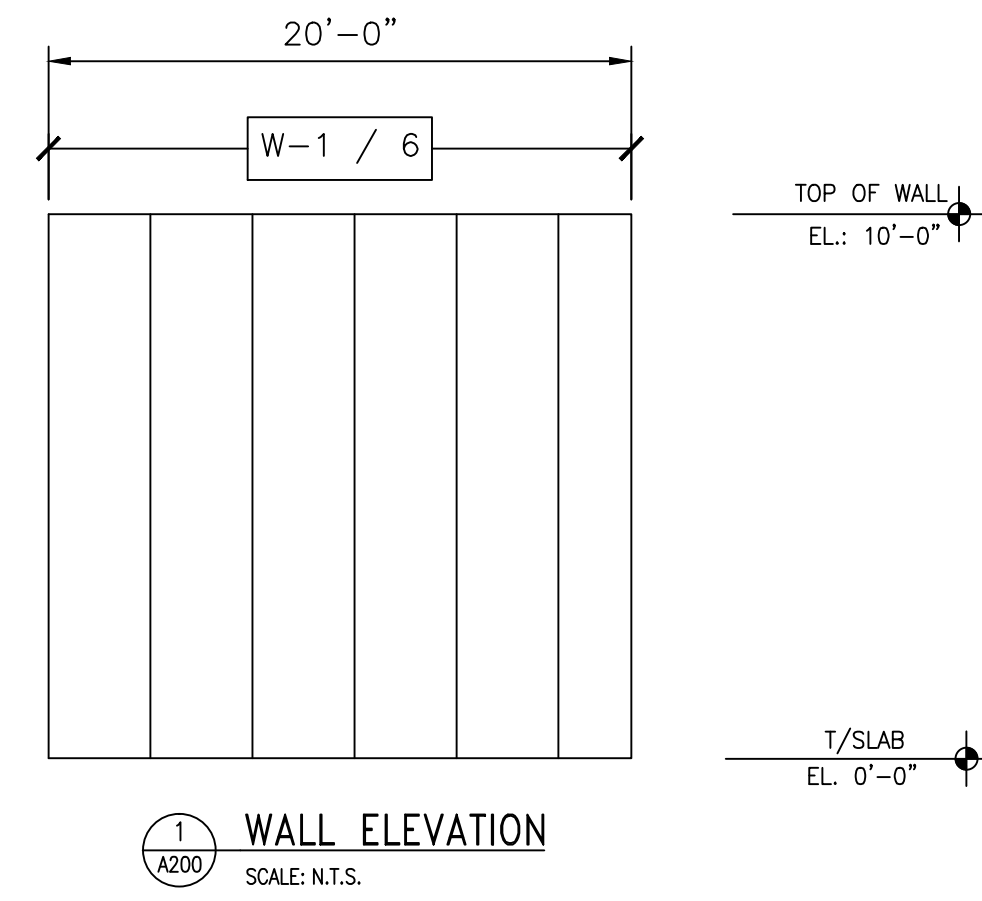

PANEL SCHEDULE

PANEL DESIG.	PANEL HEIGHT	QTY. OF PANELS	PANEL THICK	PANEL SERIES	PANEL COLOR
W-1	10'-0"	30	4"	MESALINE	USDA WHITE
C-2	20'-0"	9	4"	MESALINE	USDA WHITE

NO.	REVISION	BY	DATE

Barr Inc.  
1423 Planeview Drive  
Oshkosh, WI 54904  
920-231-1711 Phone


 






20' x 30' x 10'-4"  
Drive-In Cooler

TOLERANCES UNLESS SPECIFIED  
FRACTIONAL .XX ± 1/32" .XXX ± .005" .XXXX ± .001"  
DECIMAL .015 ± 0'03" .05 ± 0'05"  
ANGLE ° ± 1' ± 1'

Draftsman is not responsible for panel heights, quantities and/or dimensions. Contractor to verify all information.

WALL ELEVATIONS

DR. BY: KRZ  
DATE: 8/30/2016  
SCALE: NTS  
CHECKED BY:  
SHEET NO. A200

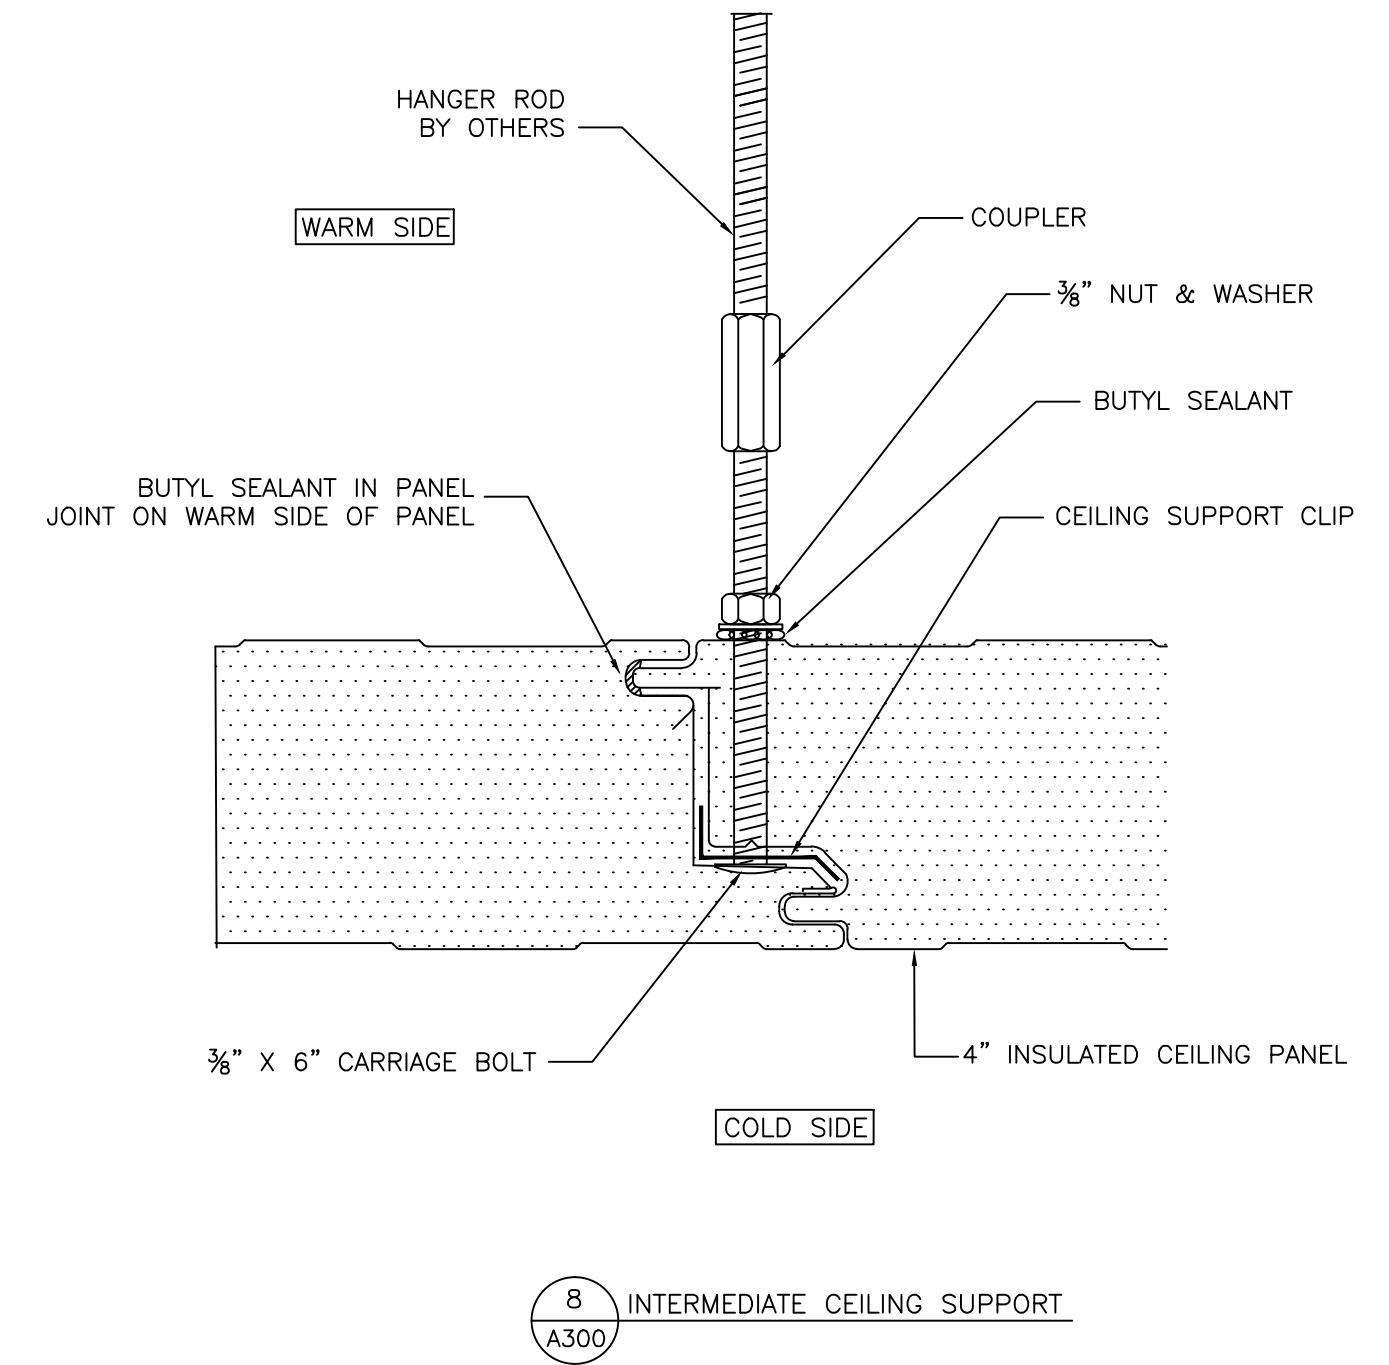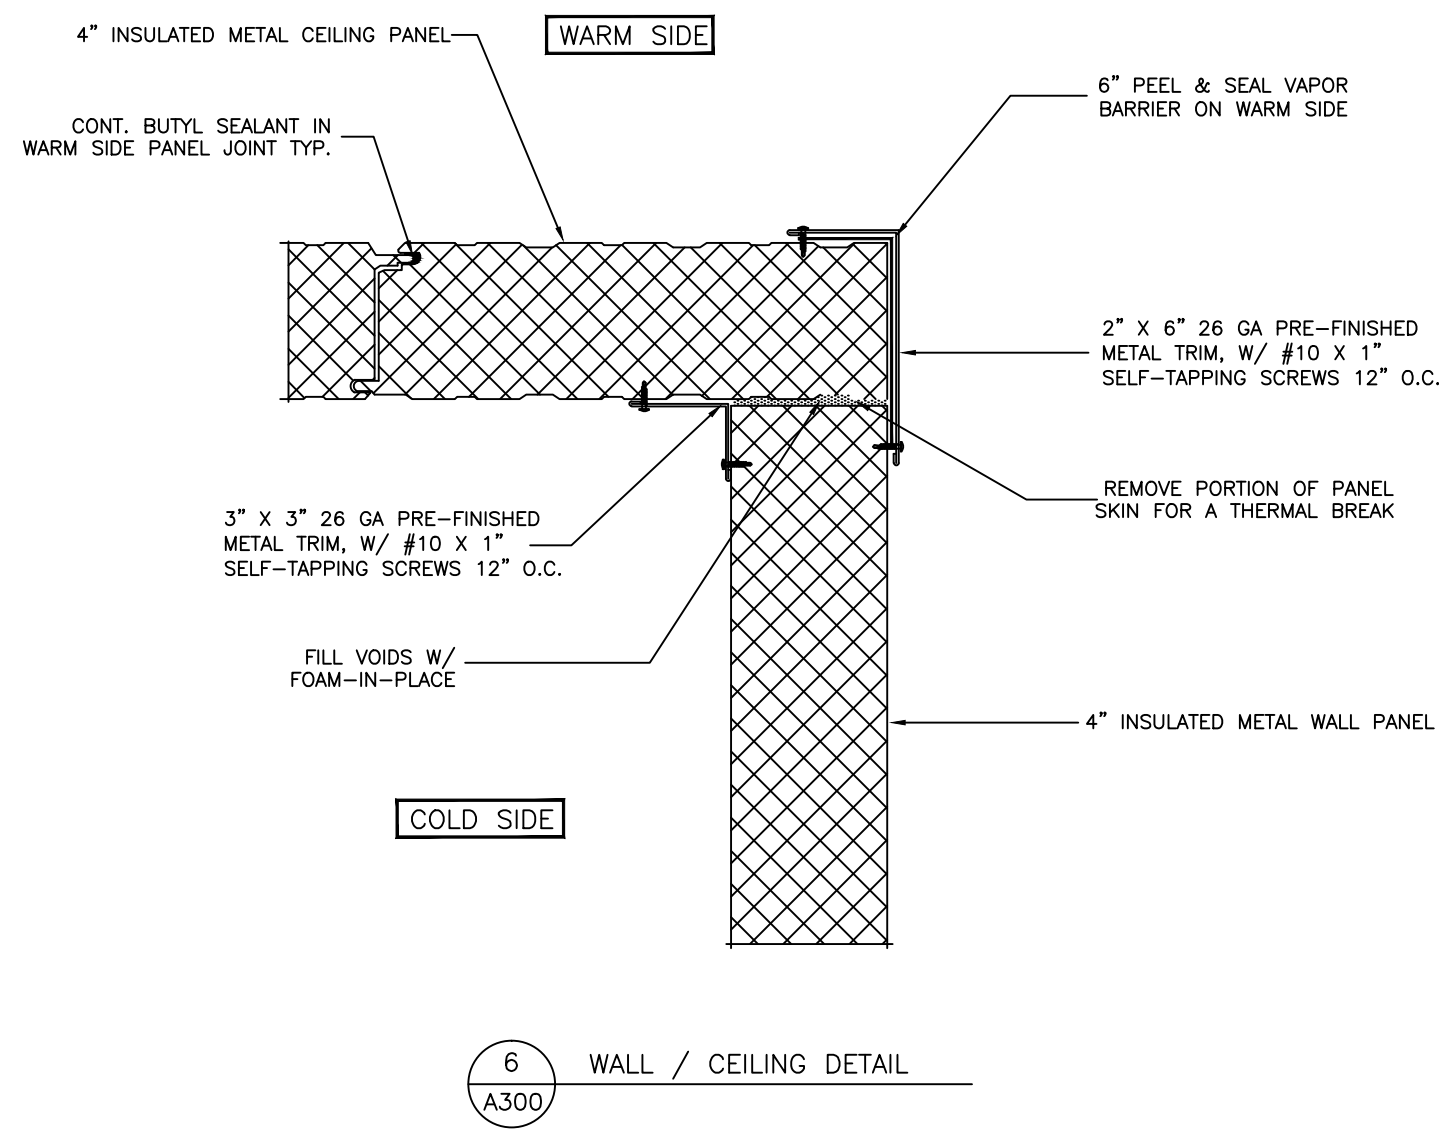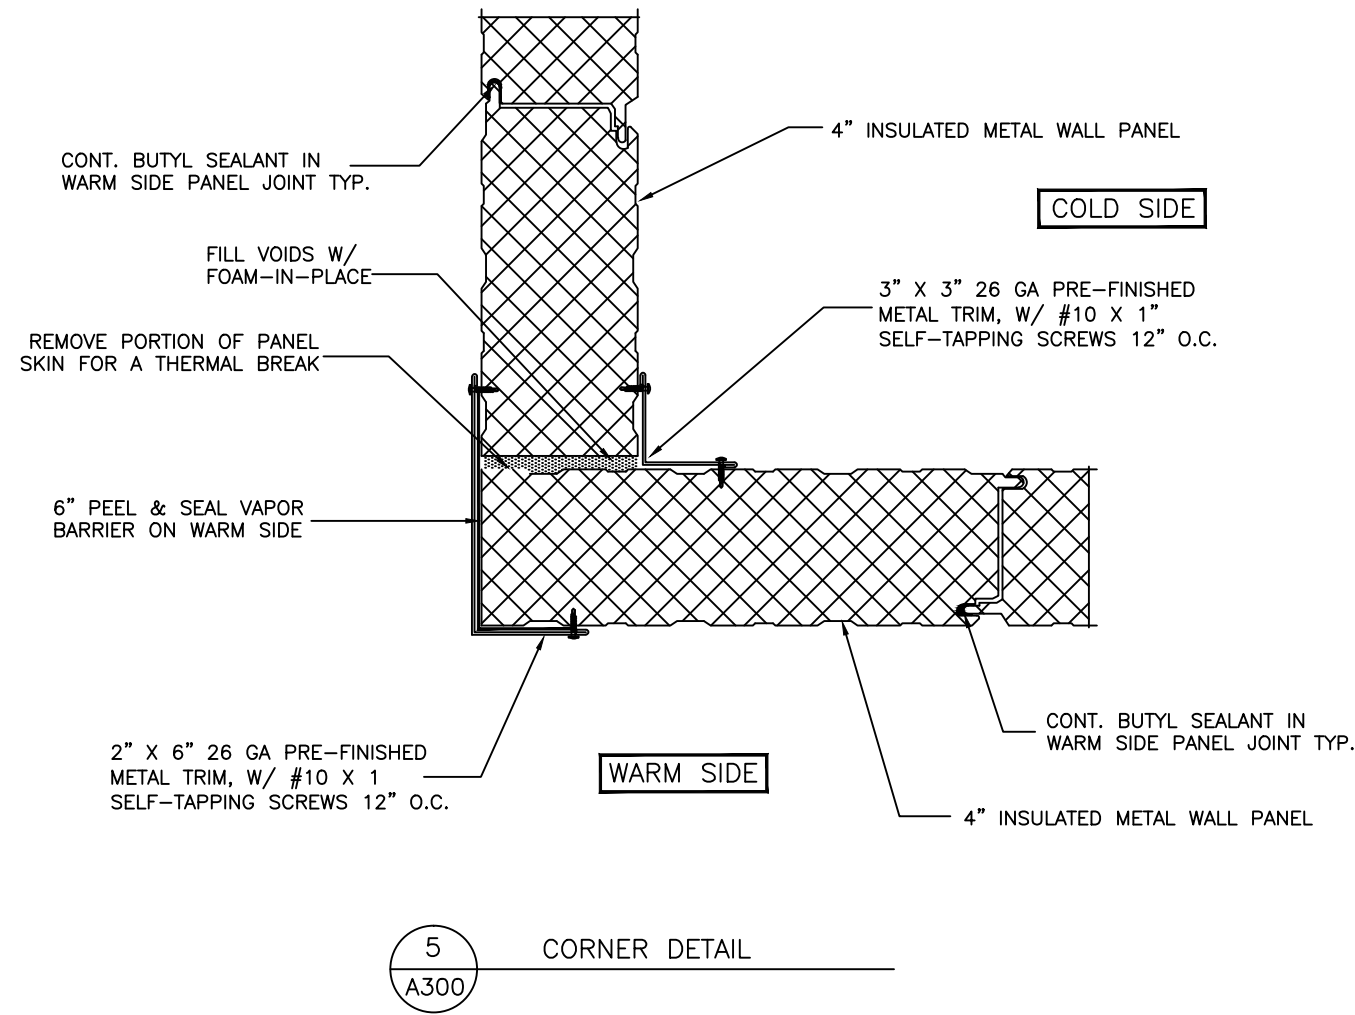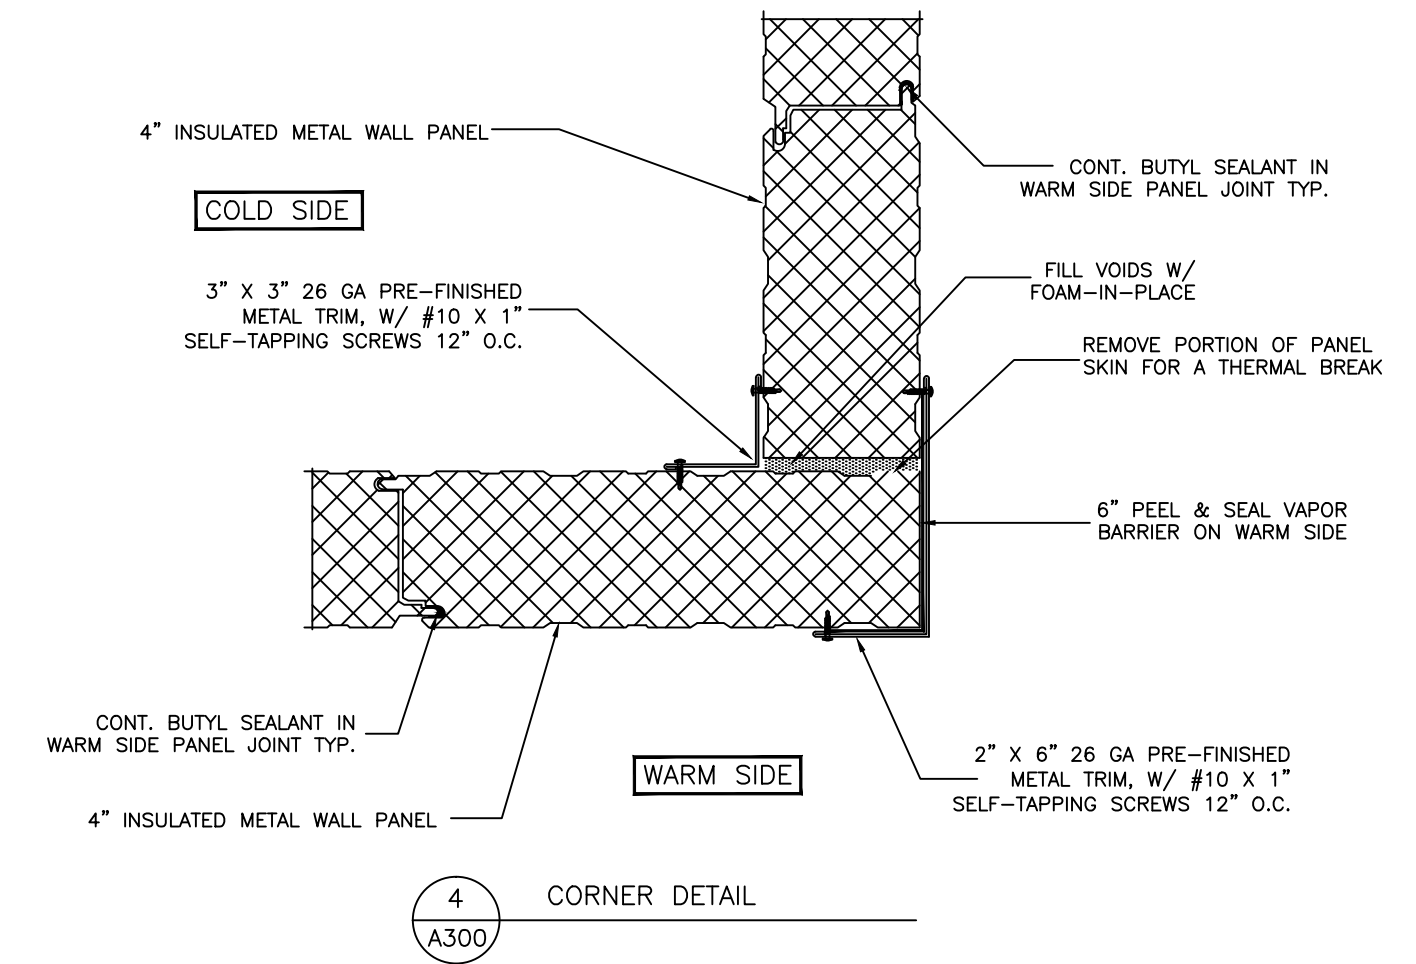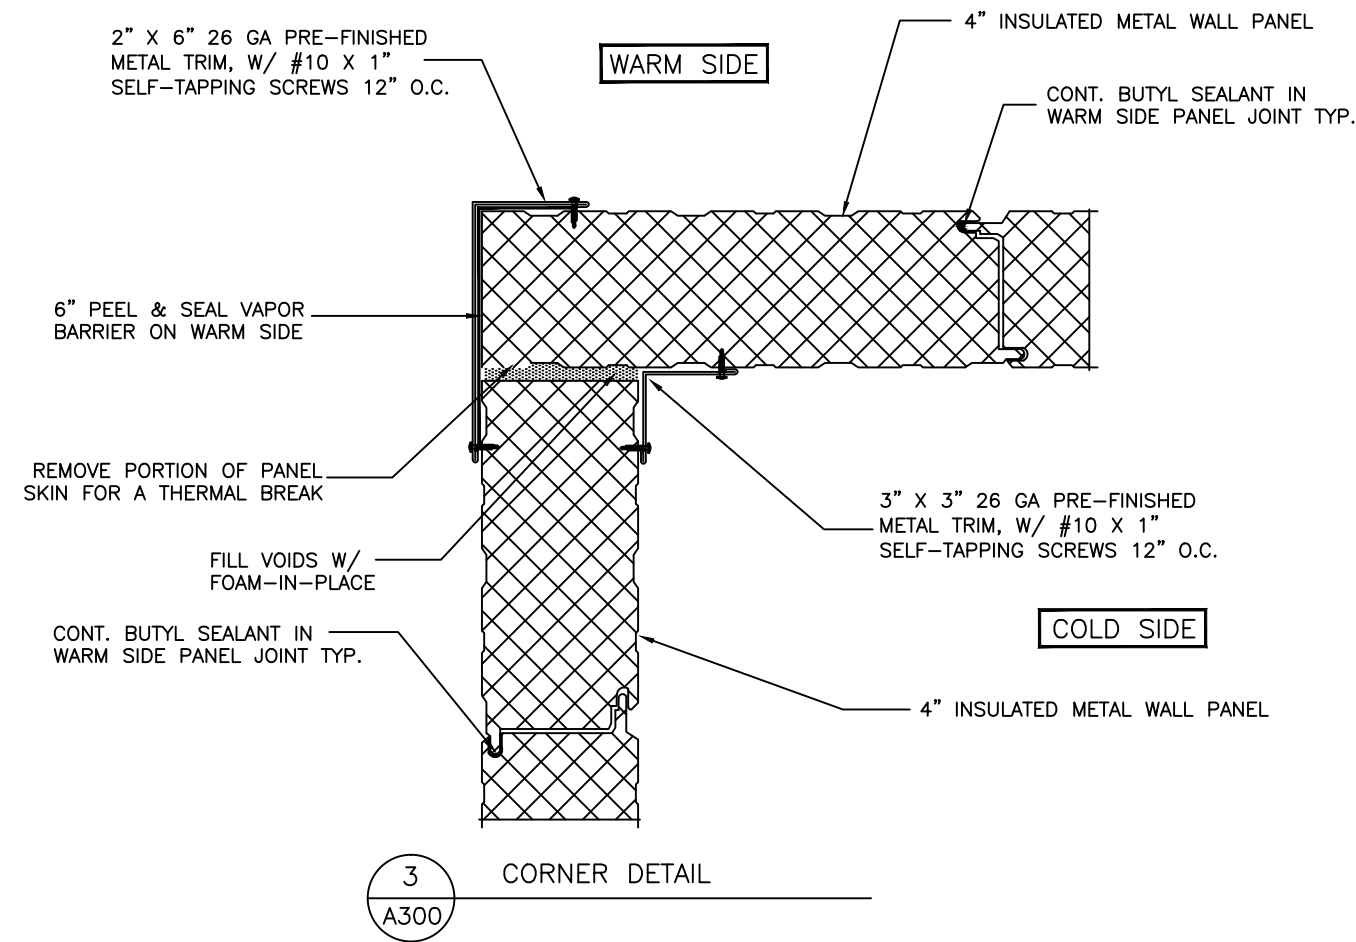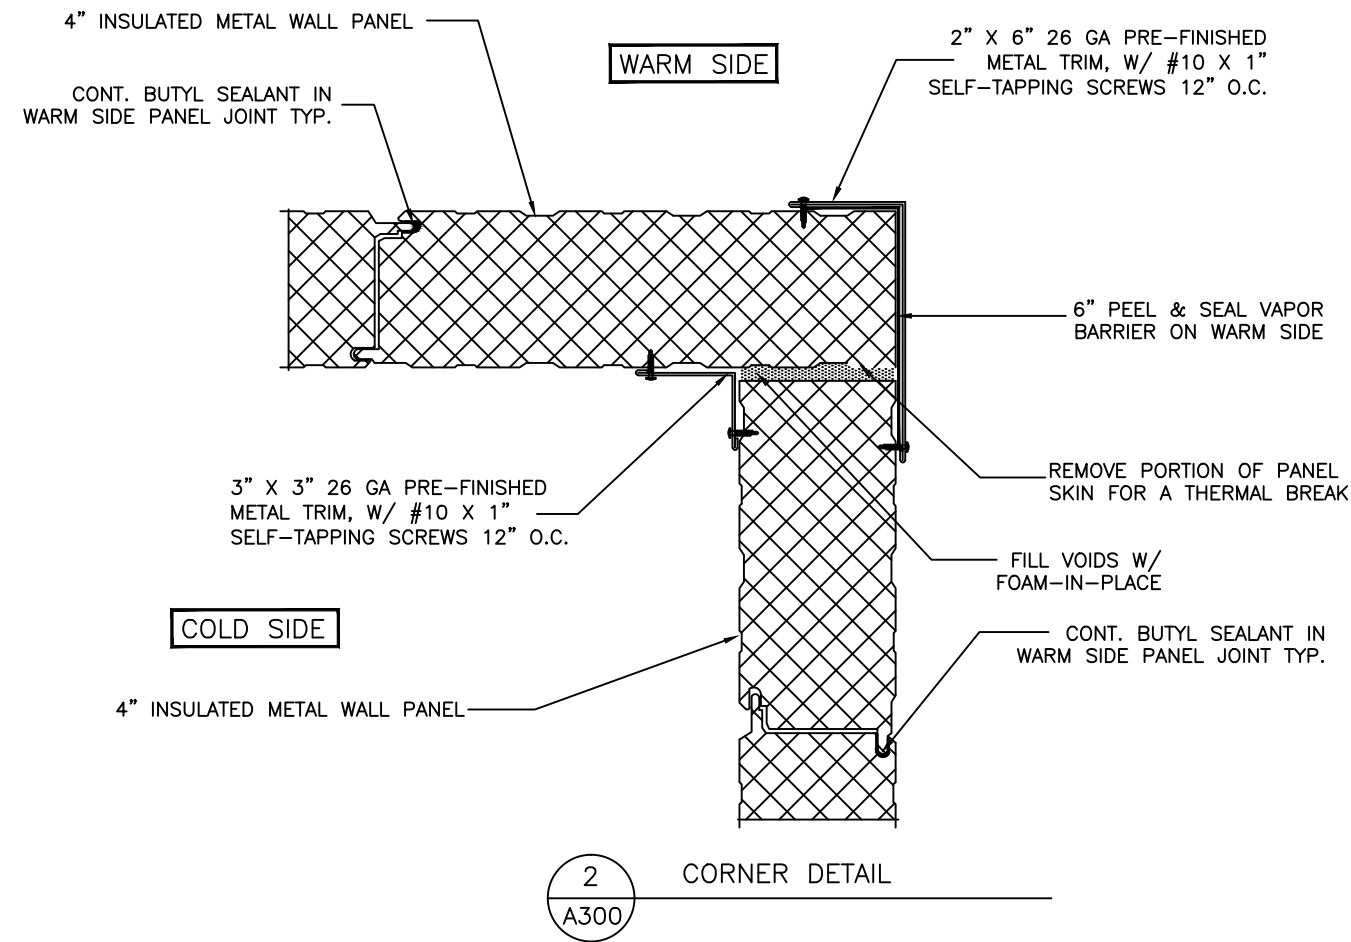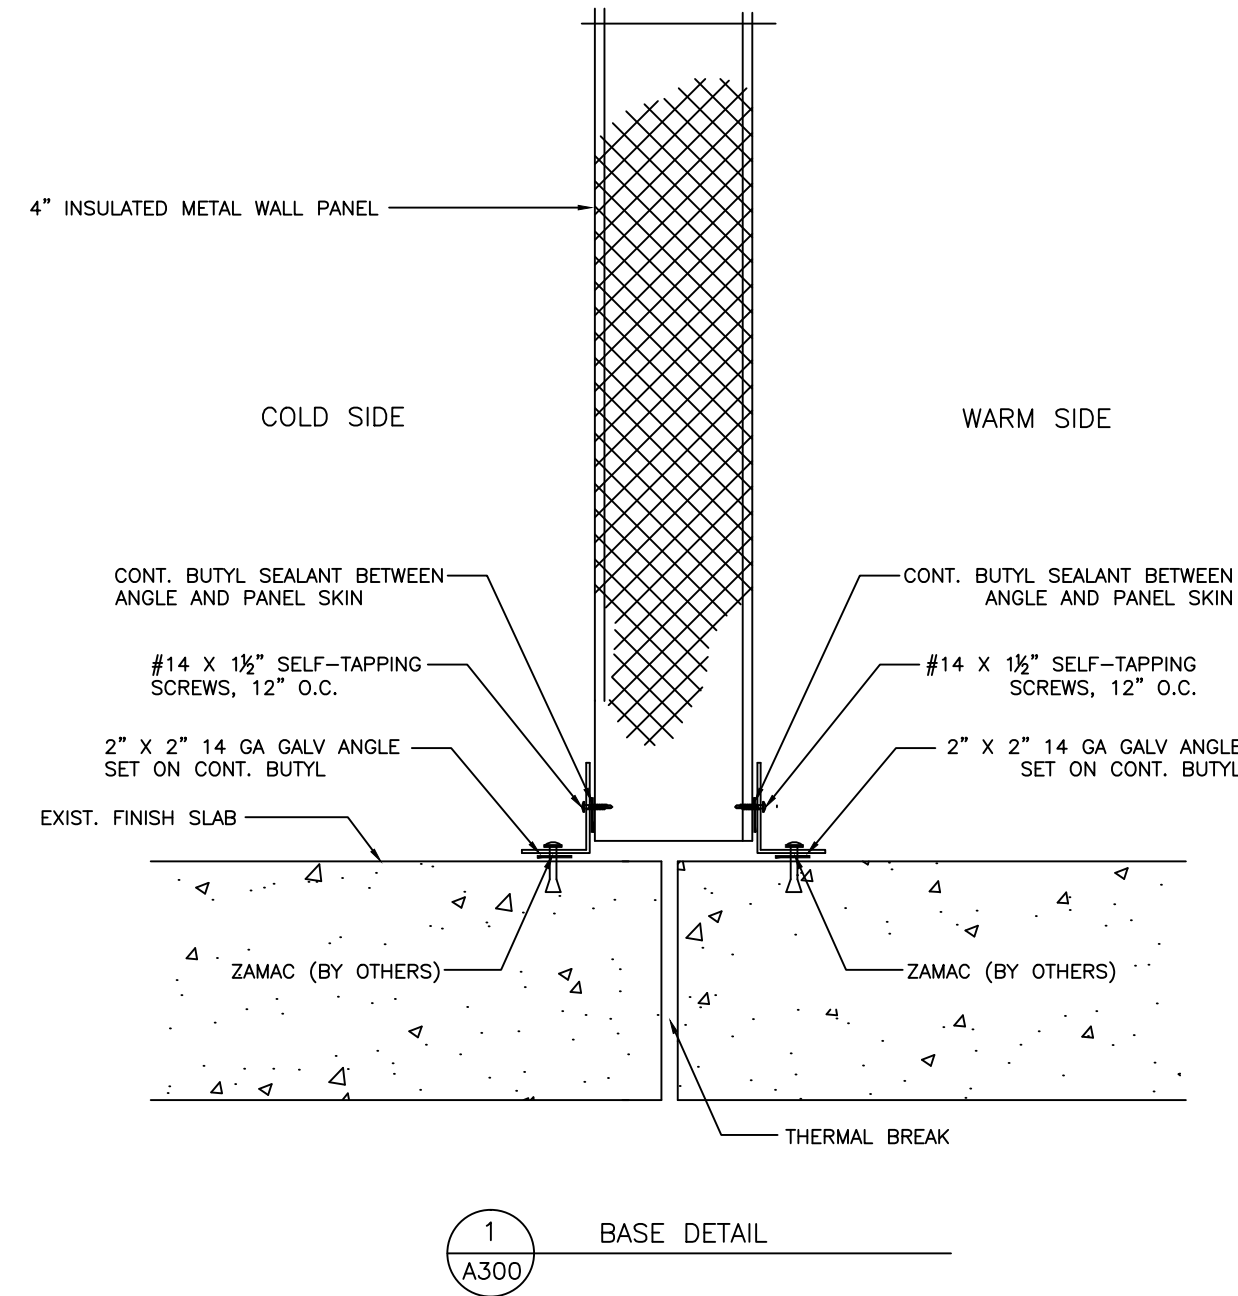

Barr Inc.  
1423 Planeview Drive  
Oshkosh, WI 54904  
920-231-1711 Phone

20' x 30' x 10'-4"  
Drive-In Cooler

TOLERANCES UNLESS SPECIFIED  
FRACTIONAL DECIMAL .015 X" ± 0'30" ANGLE  
X/X" ± 1/32" .XXX ± .005 X'X' ± 0'05"  
.XXXX ± .001

Draftsman is not responsible for panel heights, quantities and / or dimensions. Contractor to verify all information.

WALL DETAILS

DR. BY: KRZ  
DATE: 8/30/2016  
SCALE: NTS  
CHECKED BY:  
SHEET NO. A300

REVISION	BY	DATE