


Barr Inc.
1423 Planeview Drive
Oshkosh, WI 54904
920-231-1711 Phone

20' x 40' x 10'-4"
Drive-In Freezer


DRAWING INDEX

T.1	TITLE SHEET
A100	FLOOR/CEILING PLAN
A200	INSULATED WALL PANEL ELEVATIONS
A300	INSULATED WALL PANEL DETAILS

Barr Inc. 1423 Planeview Drive Oshkosh, WI 54904 920-231-1711 Phone	
20' x 40' x 10'-4" Drive-In Freezer	
<small>TOLERANCES UNLESS SPECIFIED FRACTIONAL .XX ± 1/32" DECIMAL .XXX ± .005" .XXXX ± .001"</small>	<small>ANGLE X' ± 0'30" XX' ± 0'05"</small>
<small>Draftsman is not responsible for panel heights, quantities and / or dimensions. Contractor to verify all information.</small>	
TITLE	
DR.BY: KRZ	
DATE: 8/30/2016	
SCALE: NTS	
CHECKED BY:	
SHEET NO. T.1	
REVISION	BY DATE

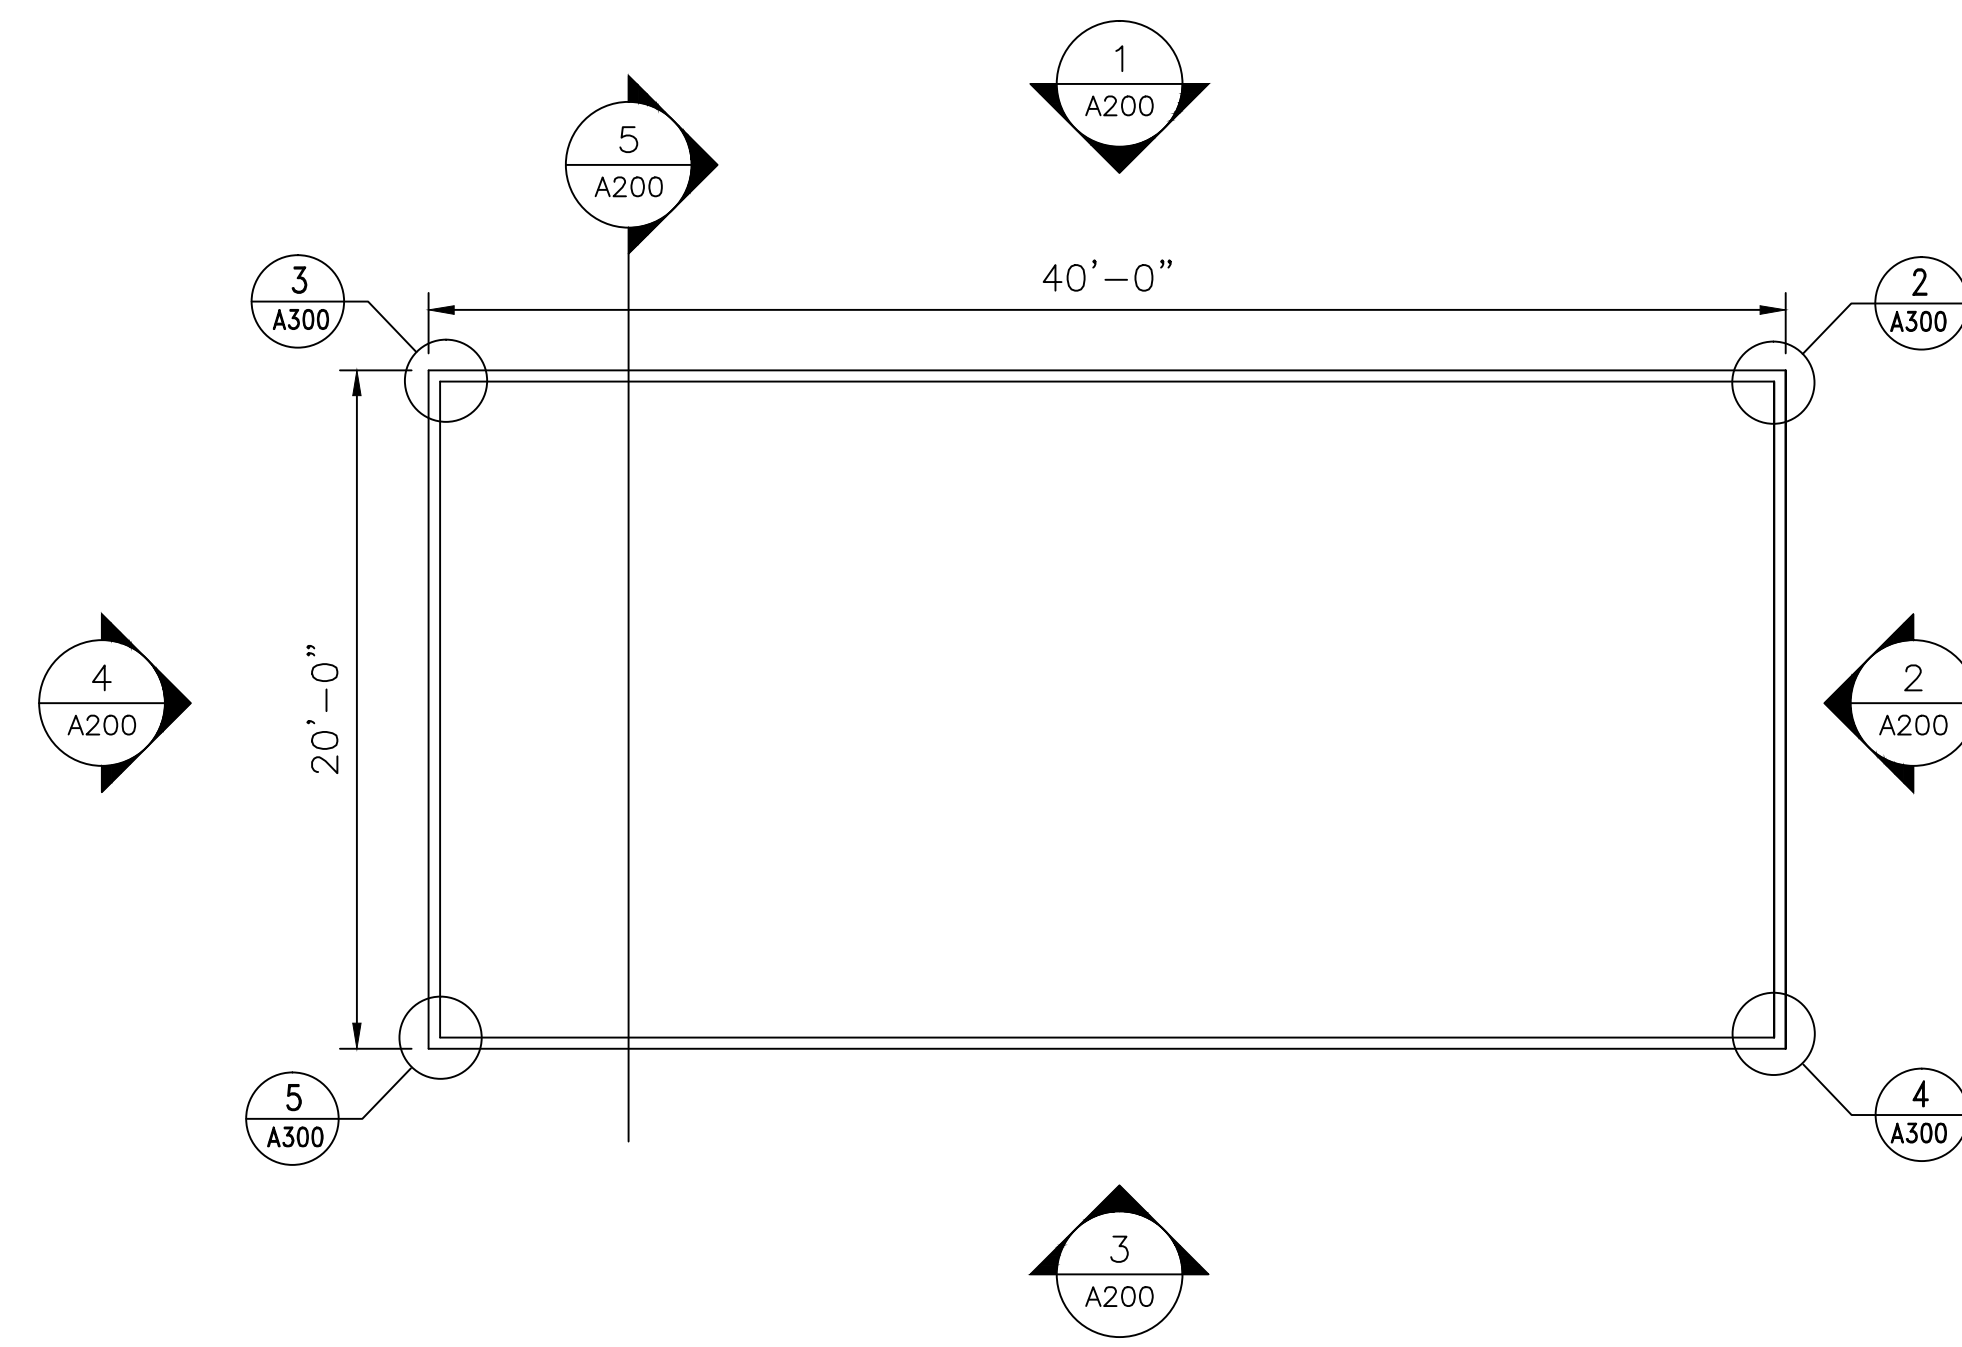

1 FLOOR PLAN
SCALE: N.T.S.

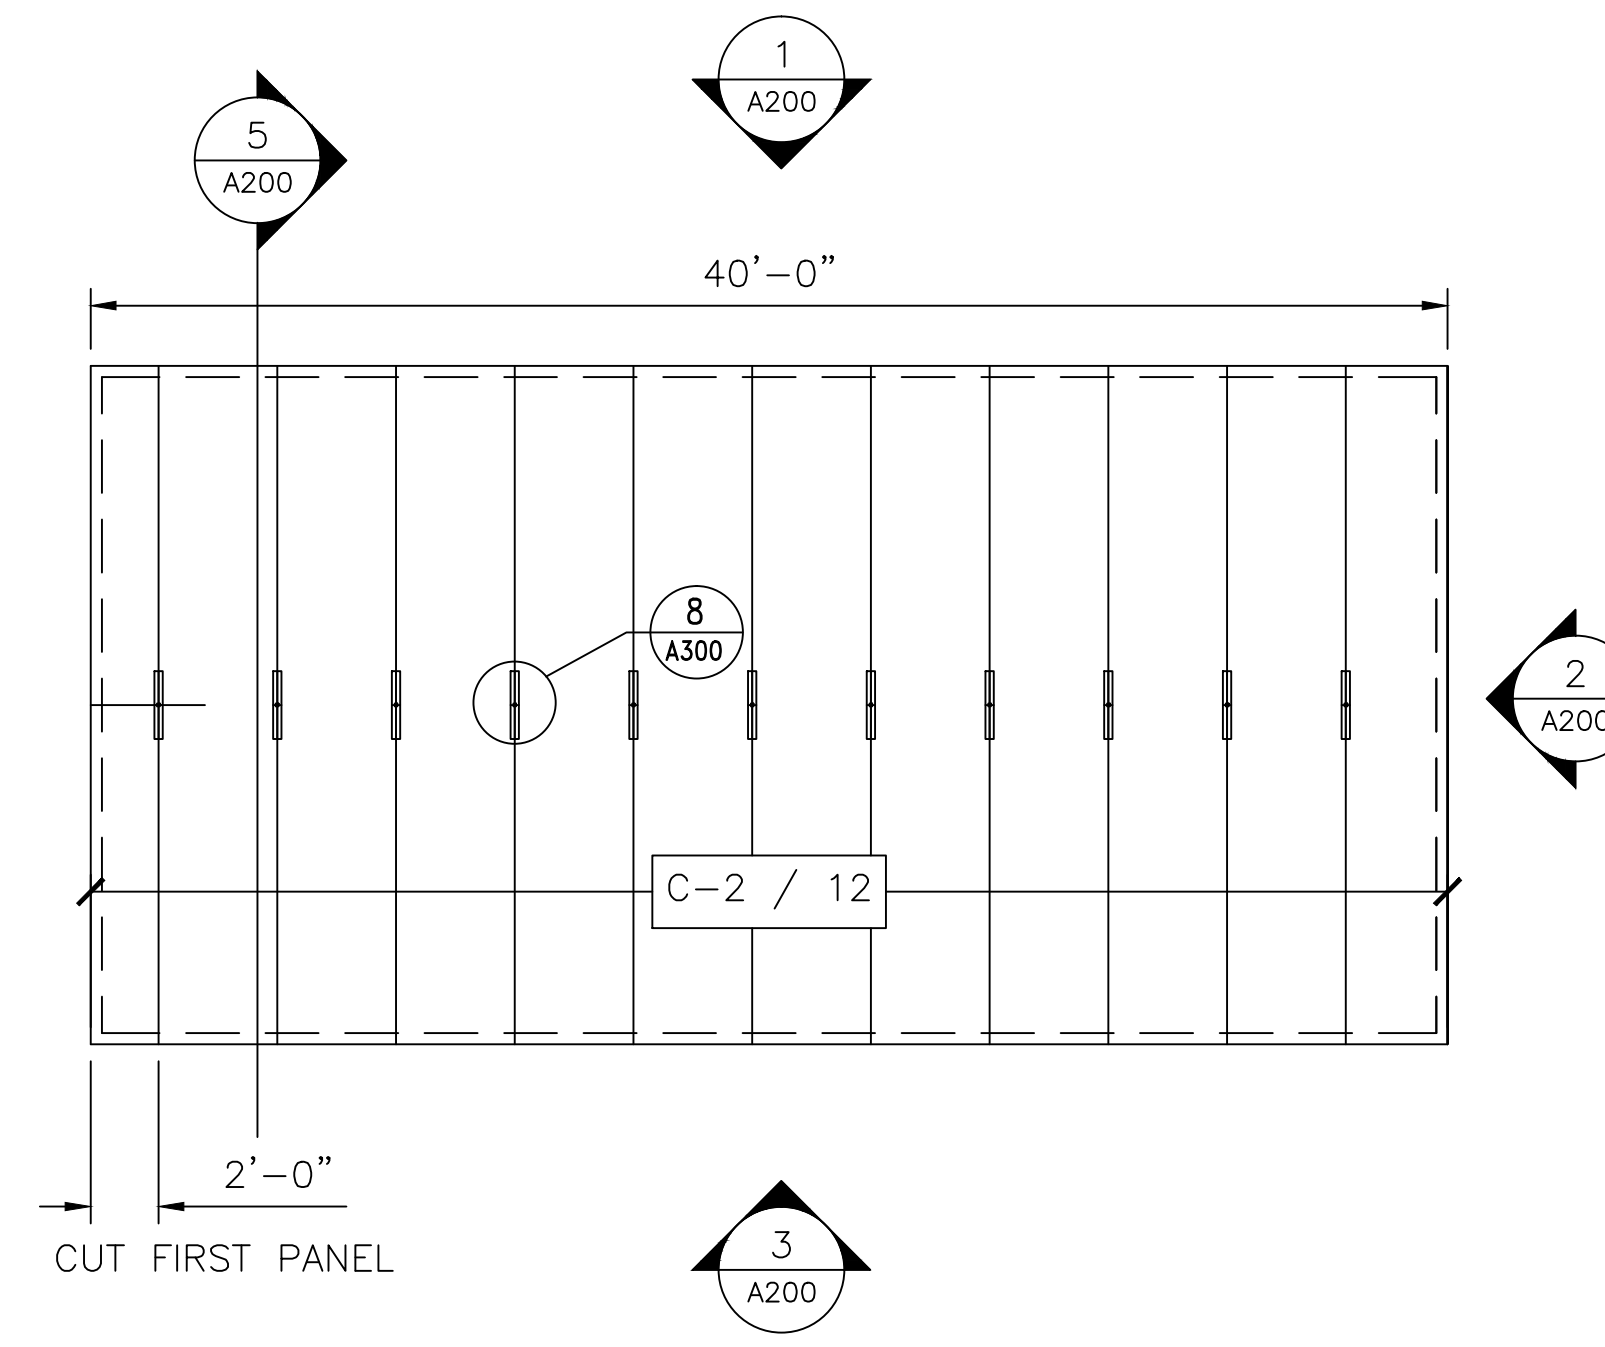

2 CEILING PLAN
SCALE: N.T.S.

PANEL SCHEDULE

PANEL DESIG.	PANEL HEIGHT	QTY OF PANELS	PANEL THICK	PANEL SERIES	PANEL COLOR
W-1	10'-0"	36	4"	MESALINE	USDA WHITE
C-2	20'-0"	12	4"	MESALINE	USDA WHITE

TOLERANCES UNLESS SPECIFIED
FRACTIONAL X/X" ± 1/32"
DECIMAL .XX ± .015
X" ± 0.30"
ANGLE .XXX ± .005
XXXX ± .001
Contractor is not responsible for panel heights, quantities and/or dimensions. Contractor to verify all information.






FLOOR PLAN

DR.BY: KRZ
DATE: 8/30/2016
SCALE: NTS
CHECKED BY:
SHEET NO. A100

Barr Inc.
1423 Planeview Drive
Oshkosh, WI 54904
920-231-1711 Phone

20' x 40' x 10'-4"
Drive-In Freezer

NO.	REVISION	BY	DATE

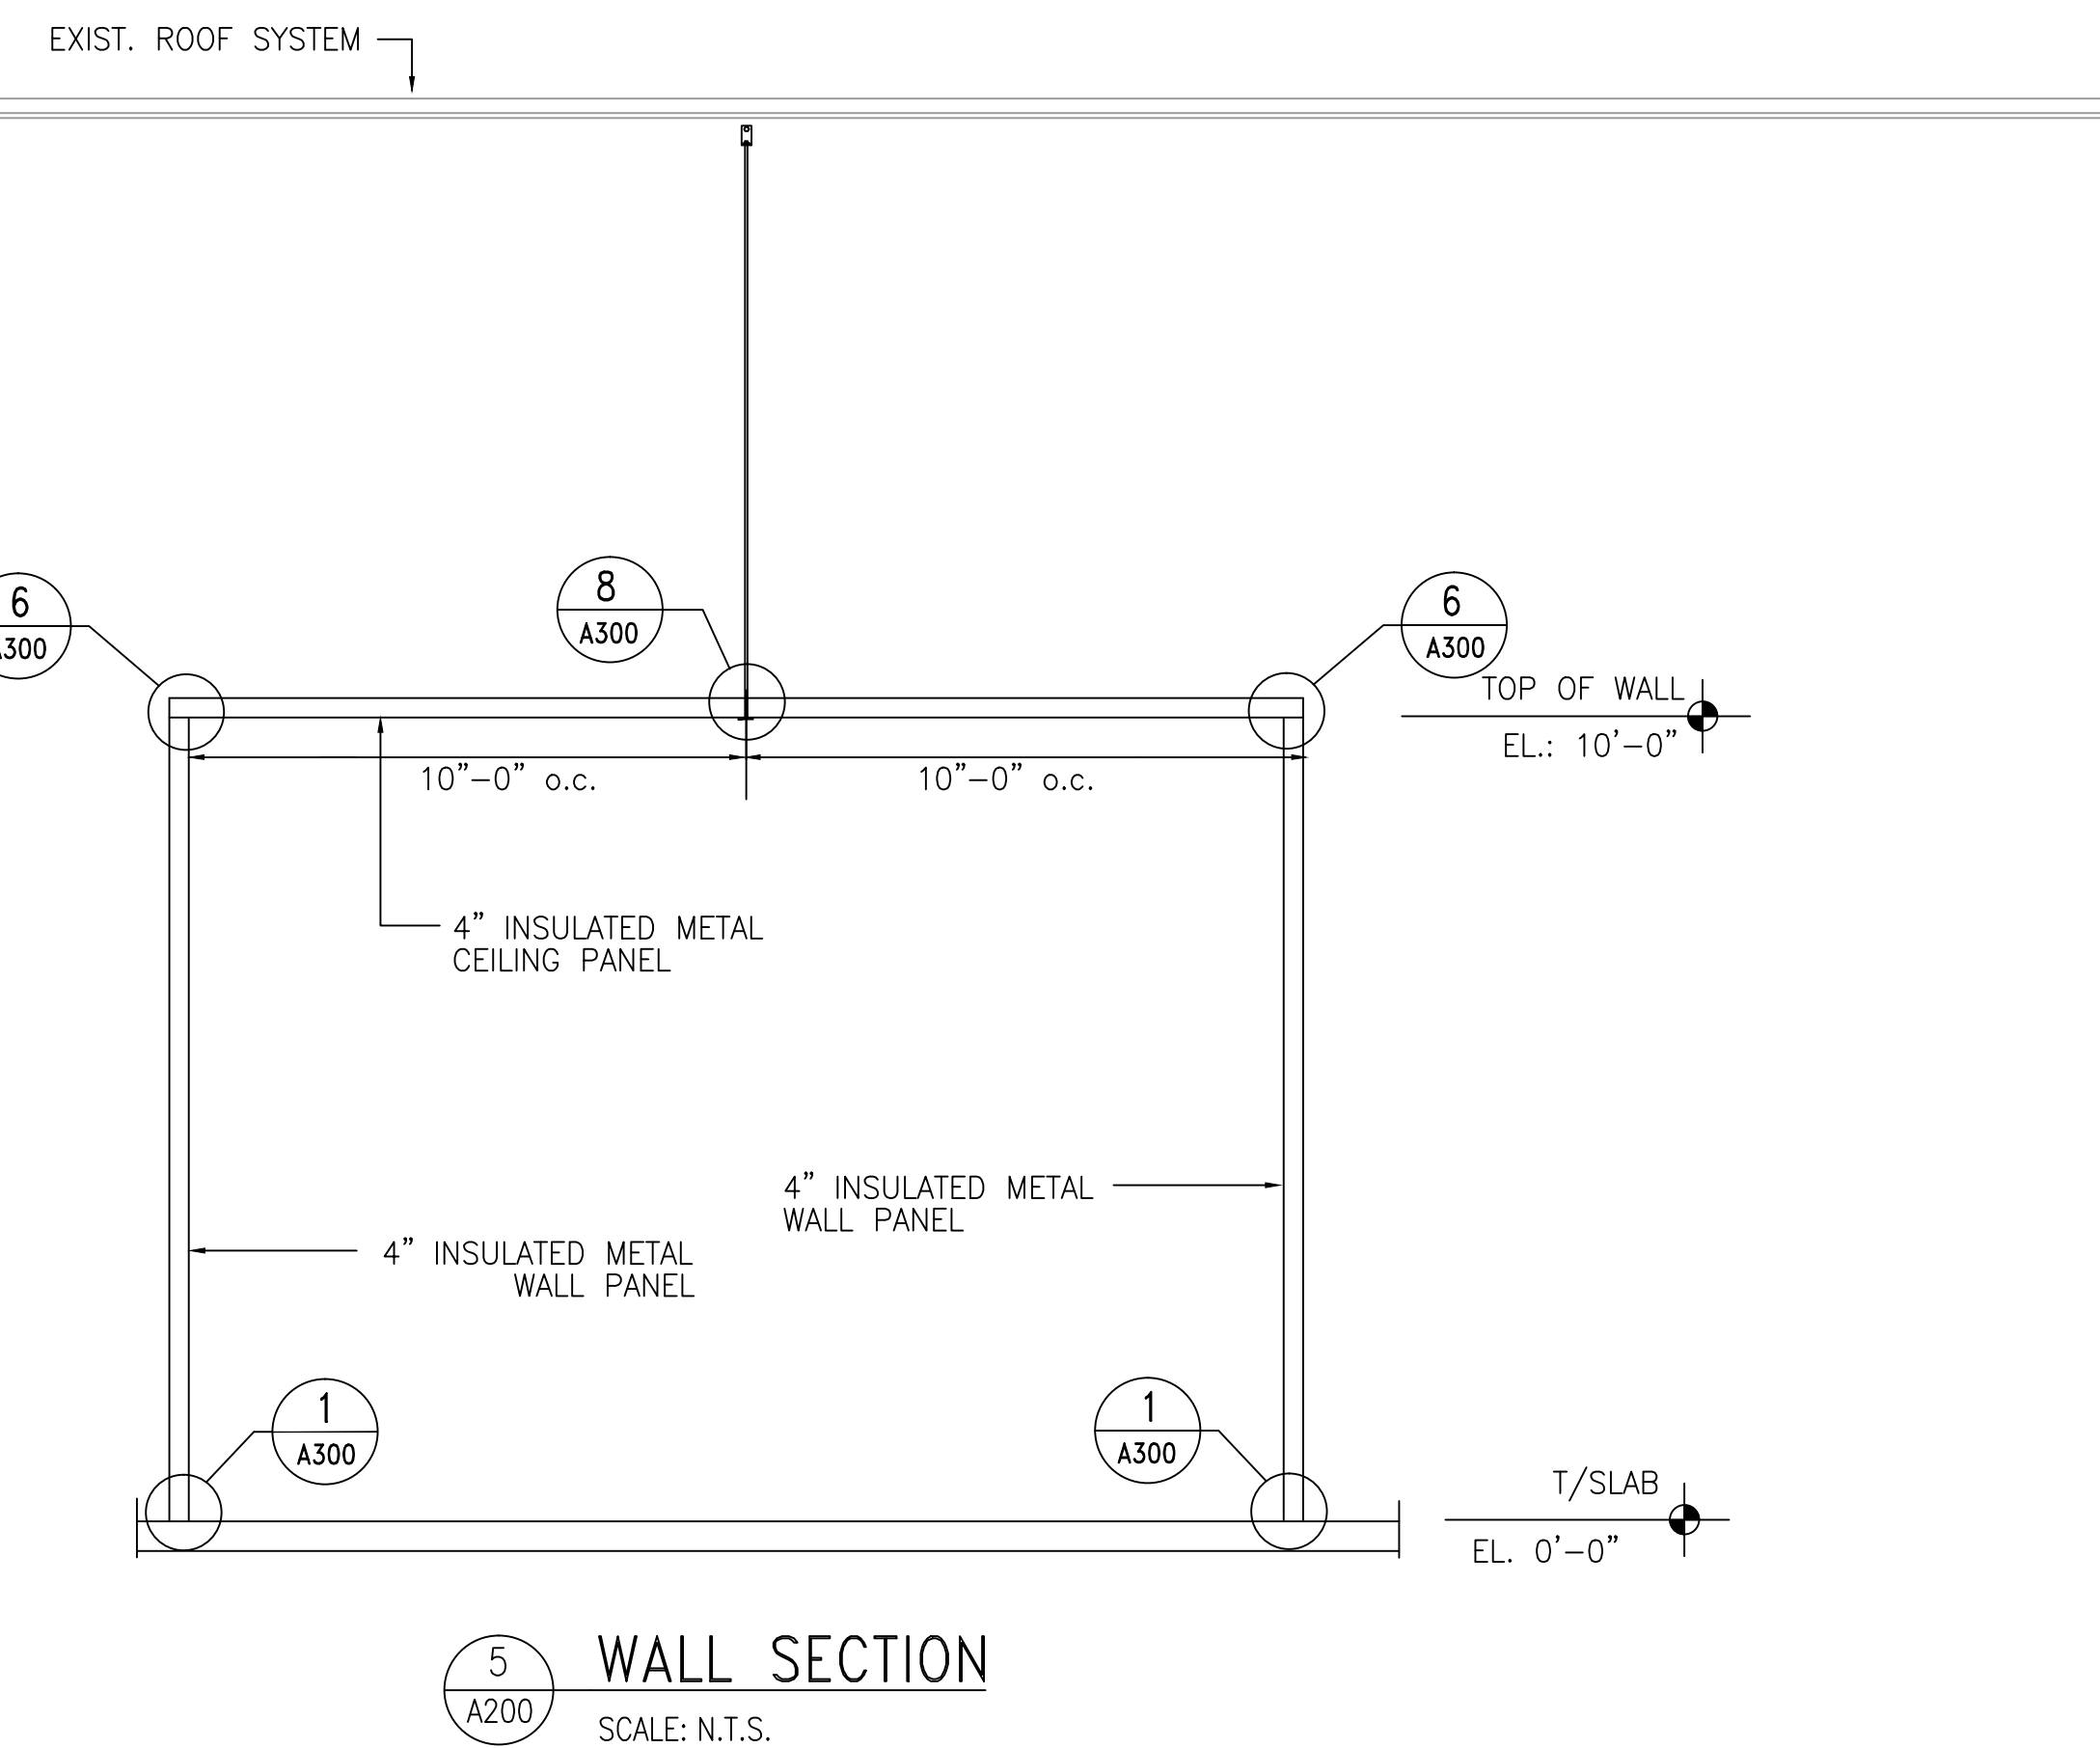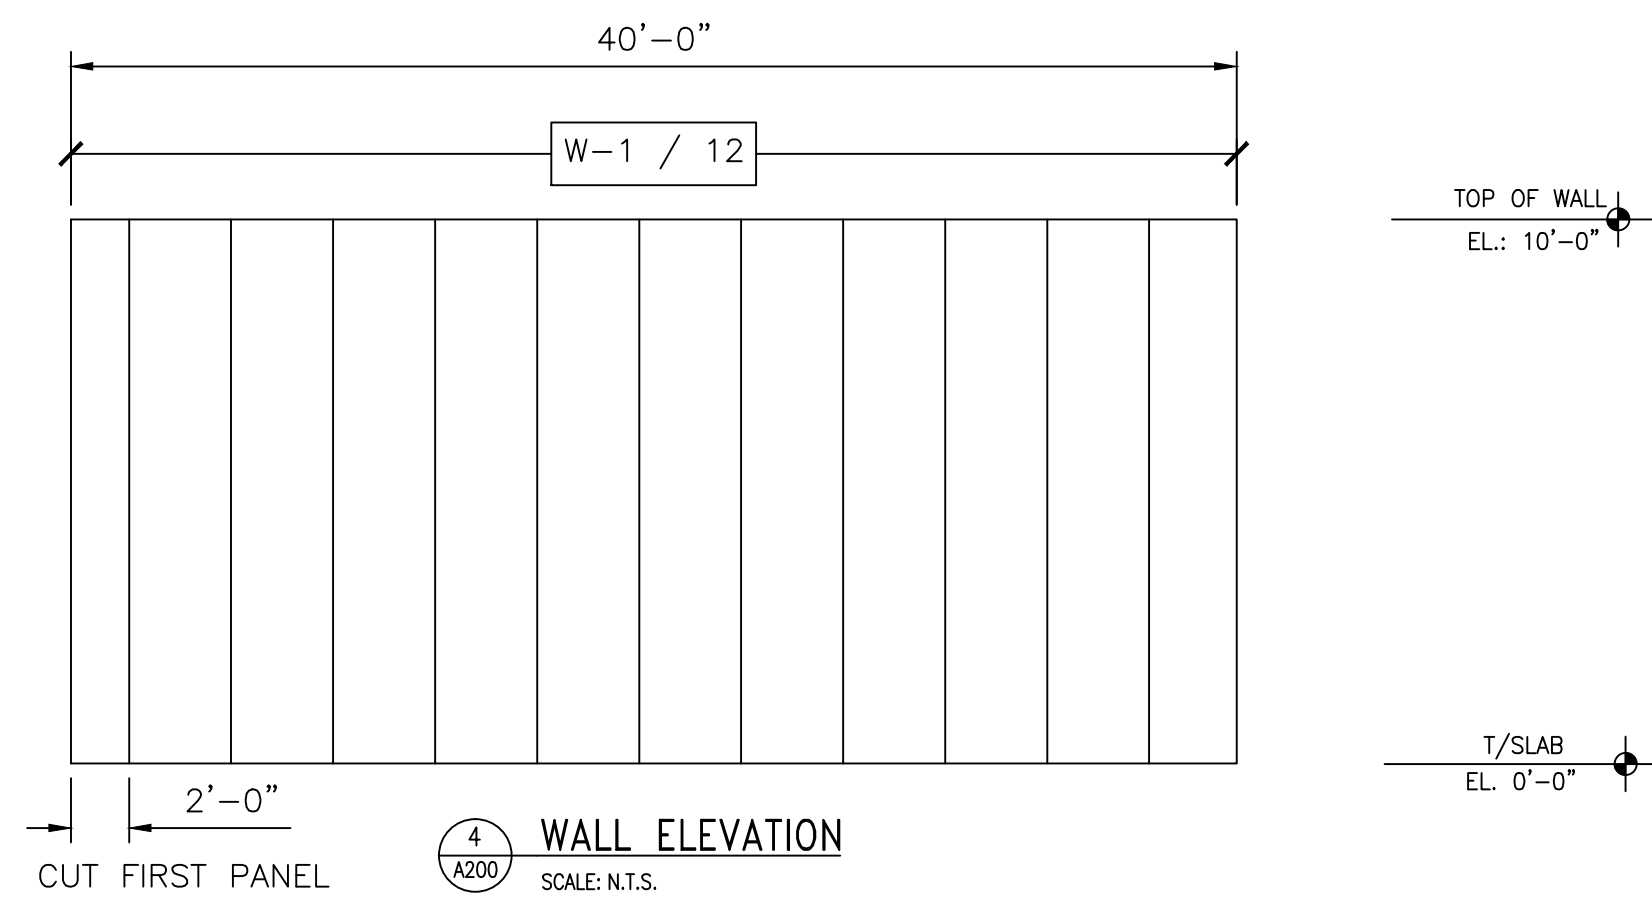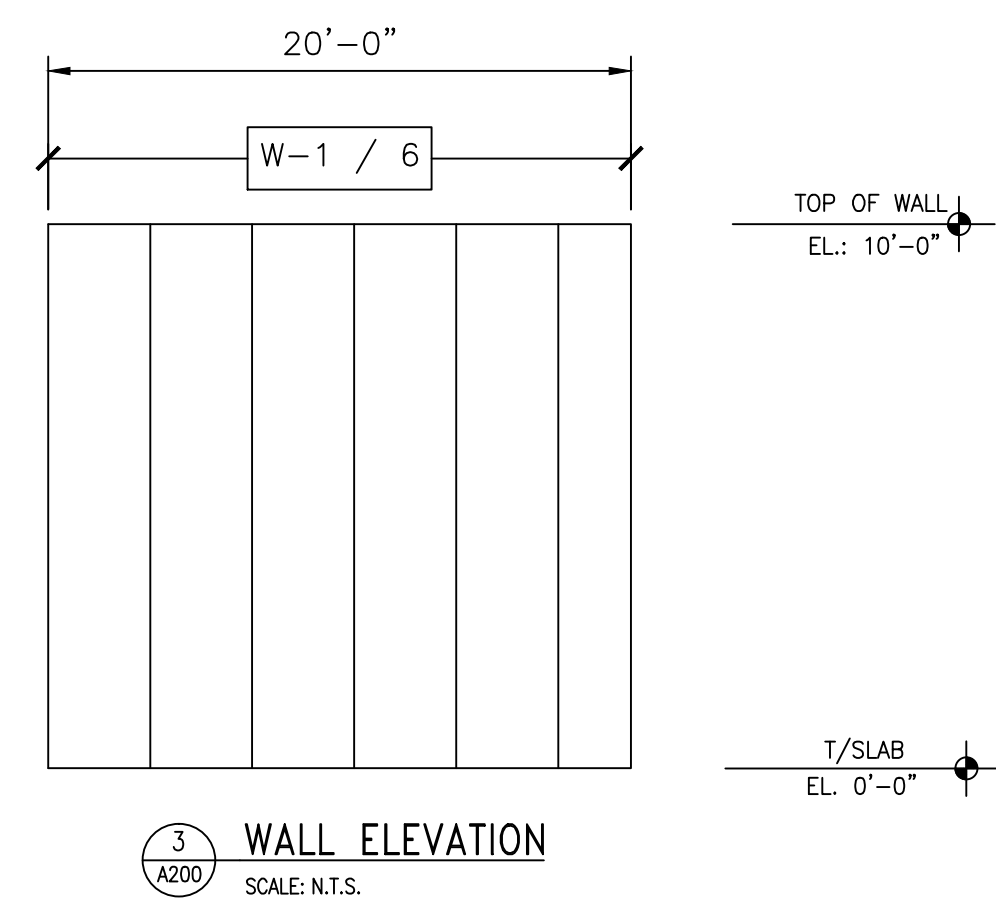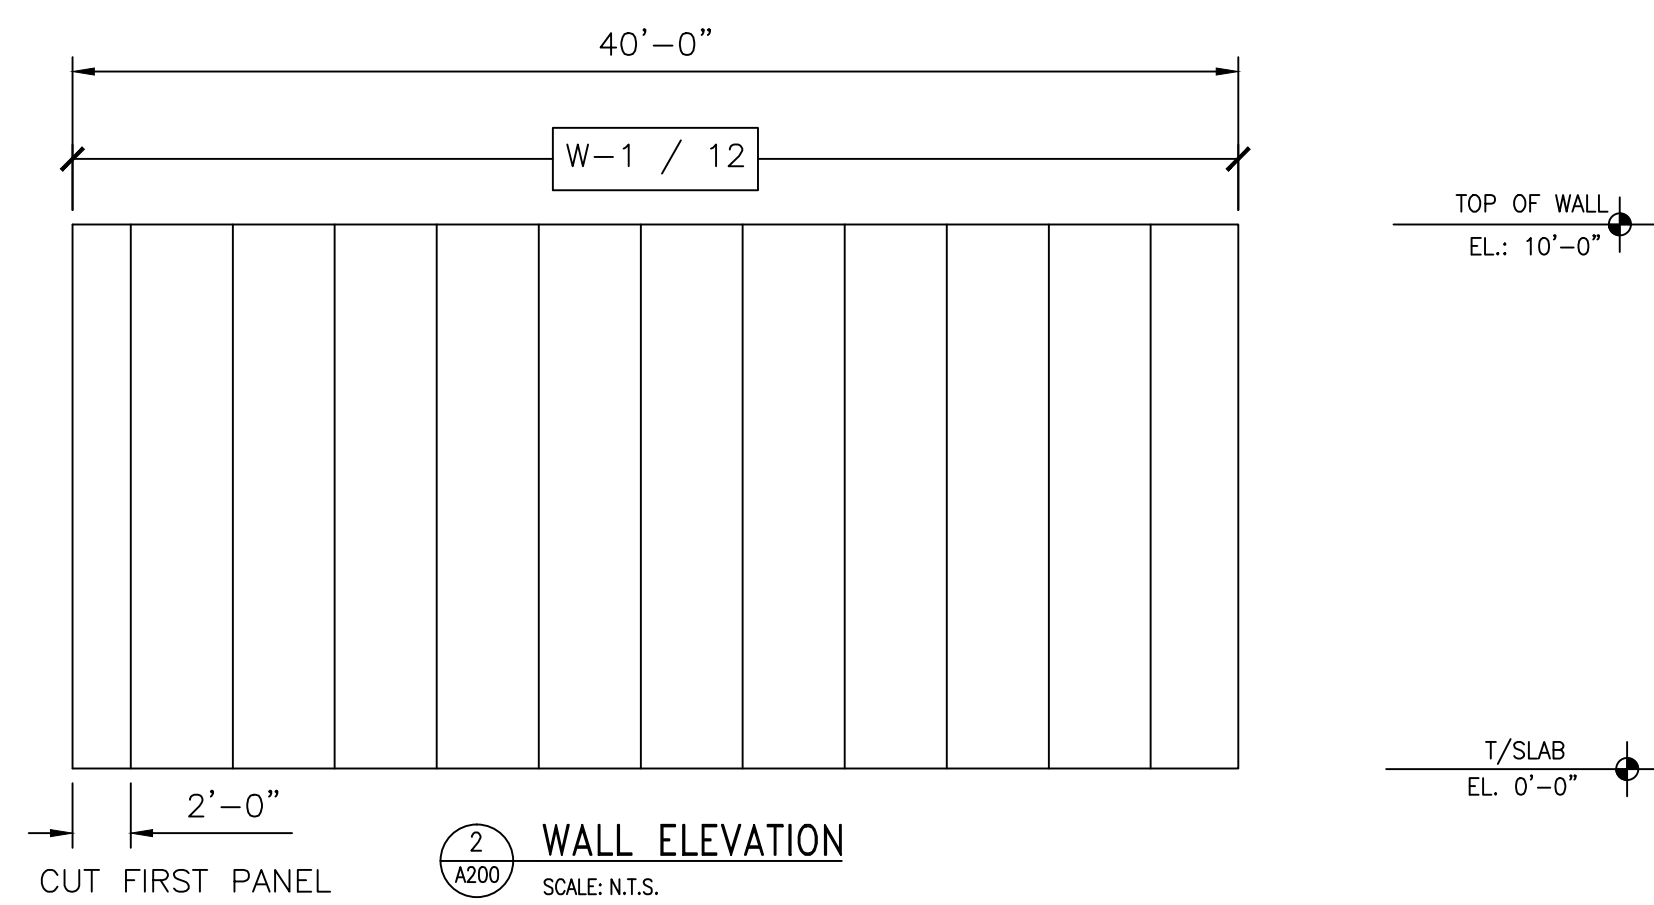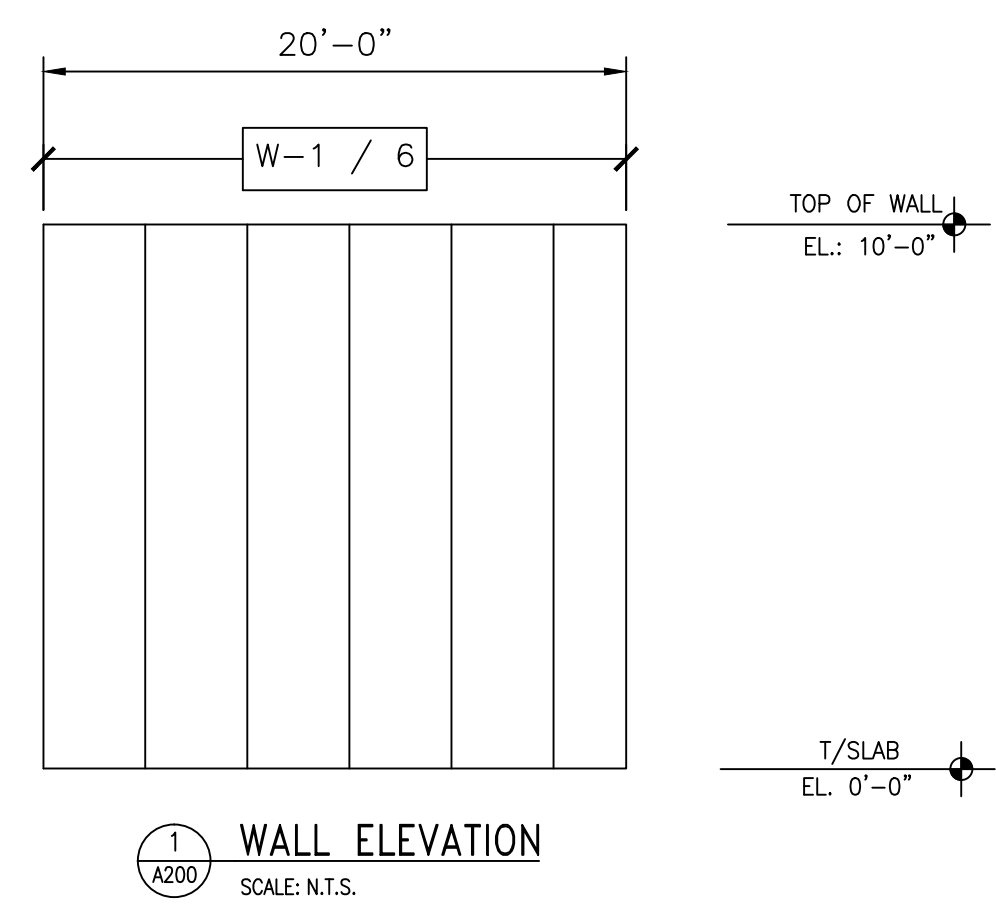

PANEL SCHEDULE

PANEL DESIG.	PANEL HEIGHT	QTY. OF PANELS	PANEL THICK	PANEL SERIES	PANEL COLOR
W-1	10'-0"	36	4"	MESALINE	USDA WHITE
C-2	20'-0"	12	4"	MESALINE	USDA WHITE

NO.	REVISION	BY	DATE

Barr Inc.
1423 Planeview Drive
Oshkosh, WI 54904
920-231-1711 Phone

20' x 40' x 10'-4"
Drive-In Freezer

TOLERANCES UNLESS SPECIFIED
FRACTIONAL .XX ± 1/32"
DECIMAL .015 ± .005
X' ± 0'30"
X' ± .005
X'X' ± 0'05"
X'X' ± .001
X'X'X ± .001
X'X'X ± .001

Draftsman is not responsible for panel heights, quantities and/or dimensions. Contractor to verify all information.

WALL ELEVATIONS

DR. BY: KRZ
DATE: 8/30/2016
SCALE: NTS
CHECKED BY:
SHEET NO. A200

