

Barr Inc.

1423 Planeview Drive

Oshkosh, WI 54904

920-231-1711 Phone

25' x 40' x 10'-4"

Drive-In Cooler

DRAWING INDEX

T.1	TITLE SHEET
A100	FLOOR/CEILING PLAN
A200	INSULATED WALL PANEL ELEVATIONS
A300	INSULATED WALL PANEL DETAILS

REVISION	BY	DATE

Barr Inc.
 1423 Planeview Drive
 Oshkosh, WI 54904
 920-231-1711 Phone


25' x 40' x 10'-4"
 Drive-In Cooler

TOLERANCES UNLESS SPECIFIED
 FRACTIONAL XX ± 1/32" .XX ± .015" X ± 0°30'
 DECIMAL .XXX ± .005" .XXX ± 0°05'
 .XXXX ± .001" .XXXX ± 0°05'


Draftsman is not responsible for panel heights, quantities and / or dimensions. Contractor to verify all information.

TITLE


DR.BY: KRZ
 DATE: 10/13/2022
 SCALE: NTS
 CHECKED BY:
 SHEET NO.
 T.1

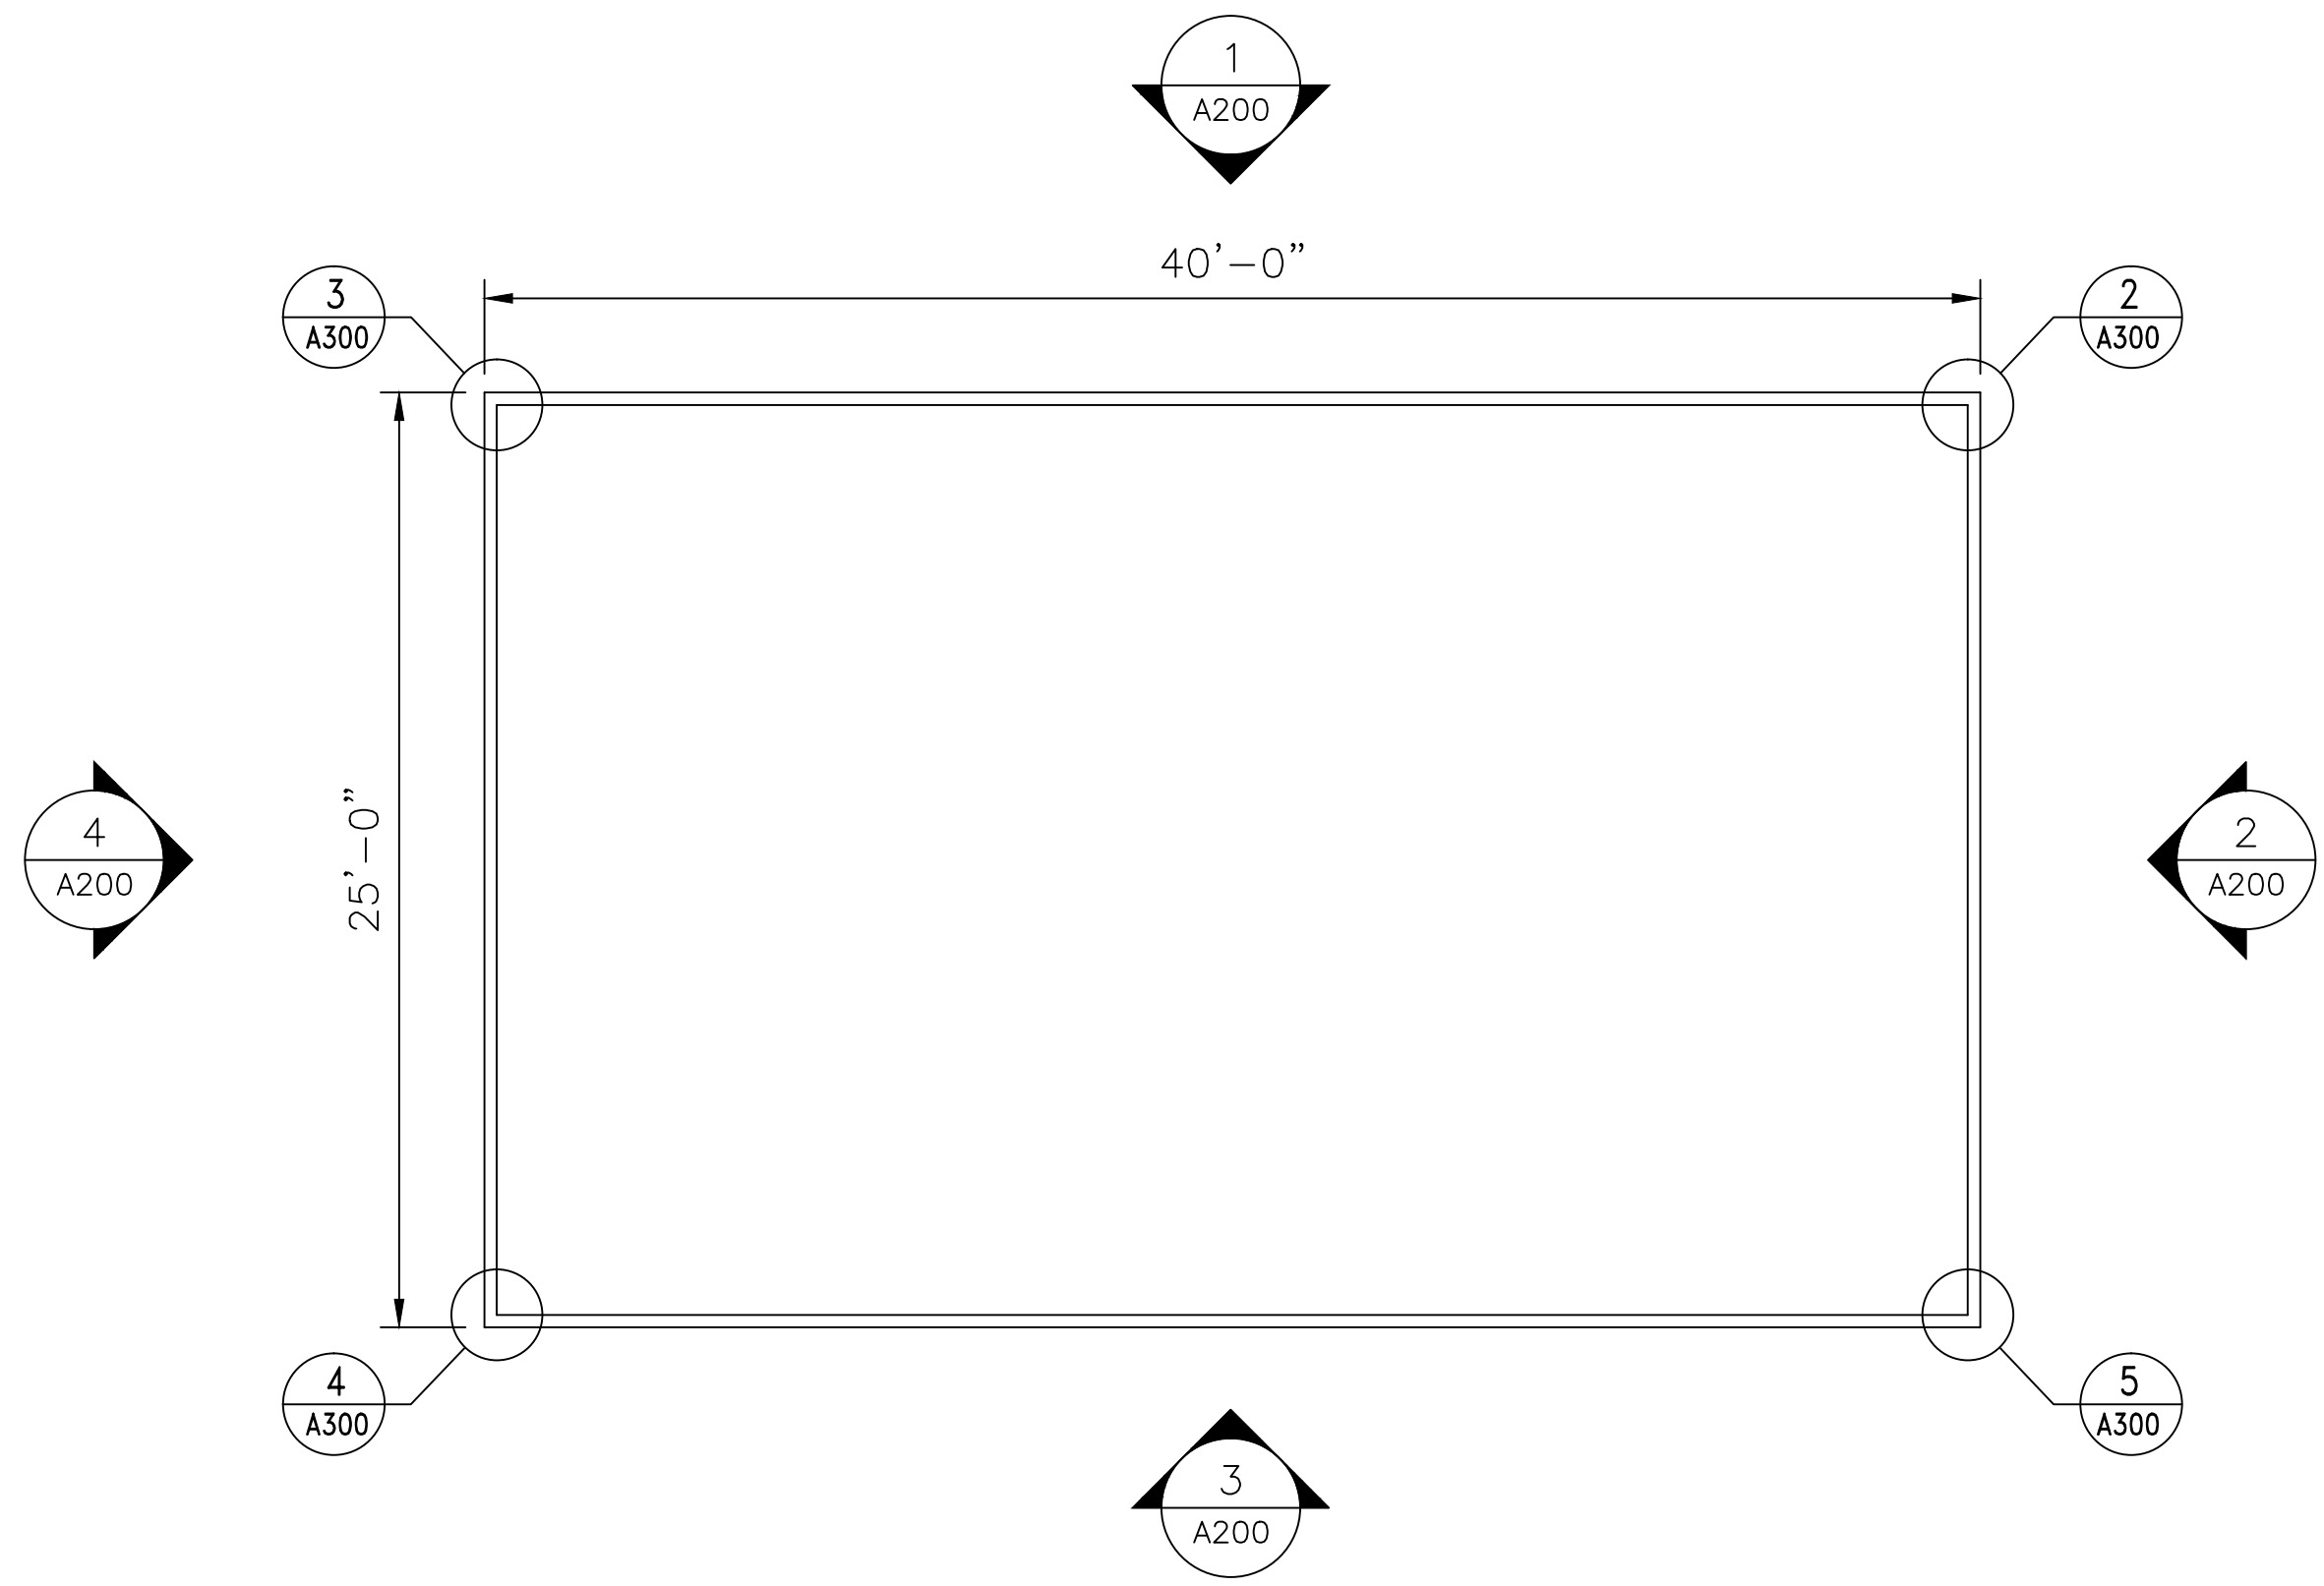

1 FLOOR PLAN
A100 SCALE: N.T.S.

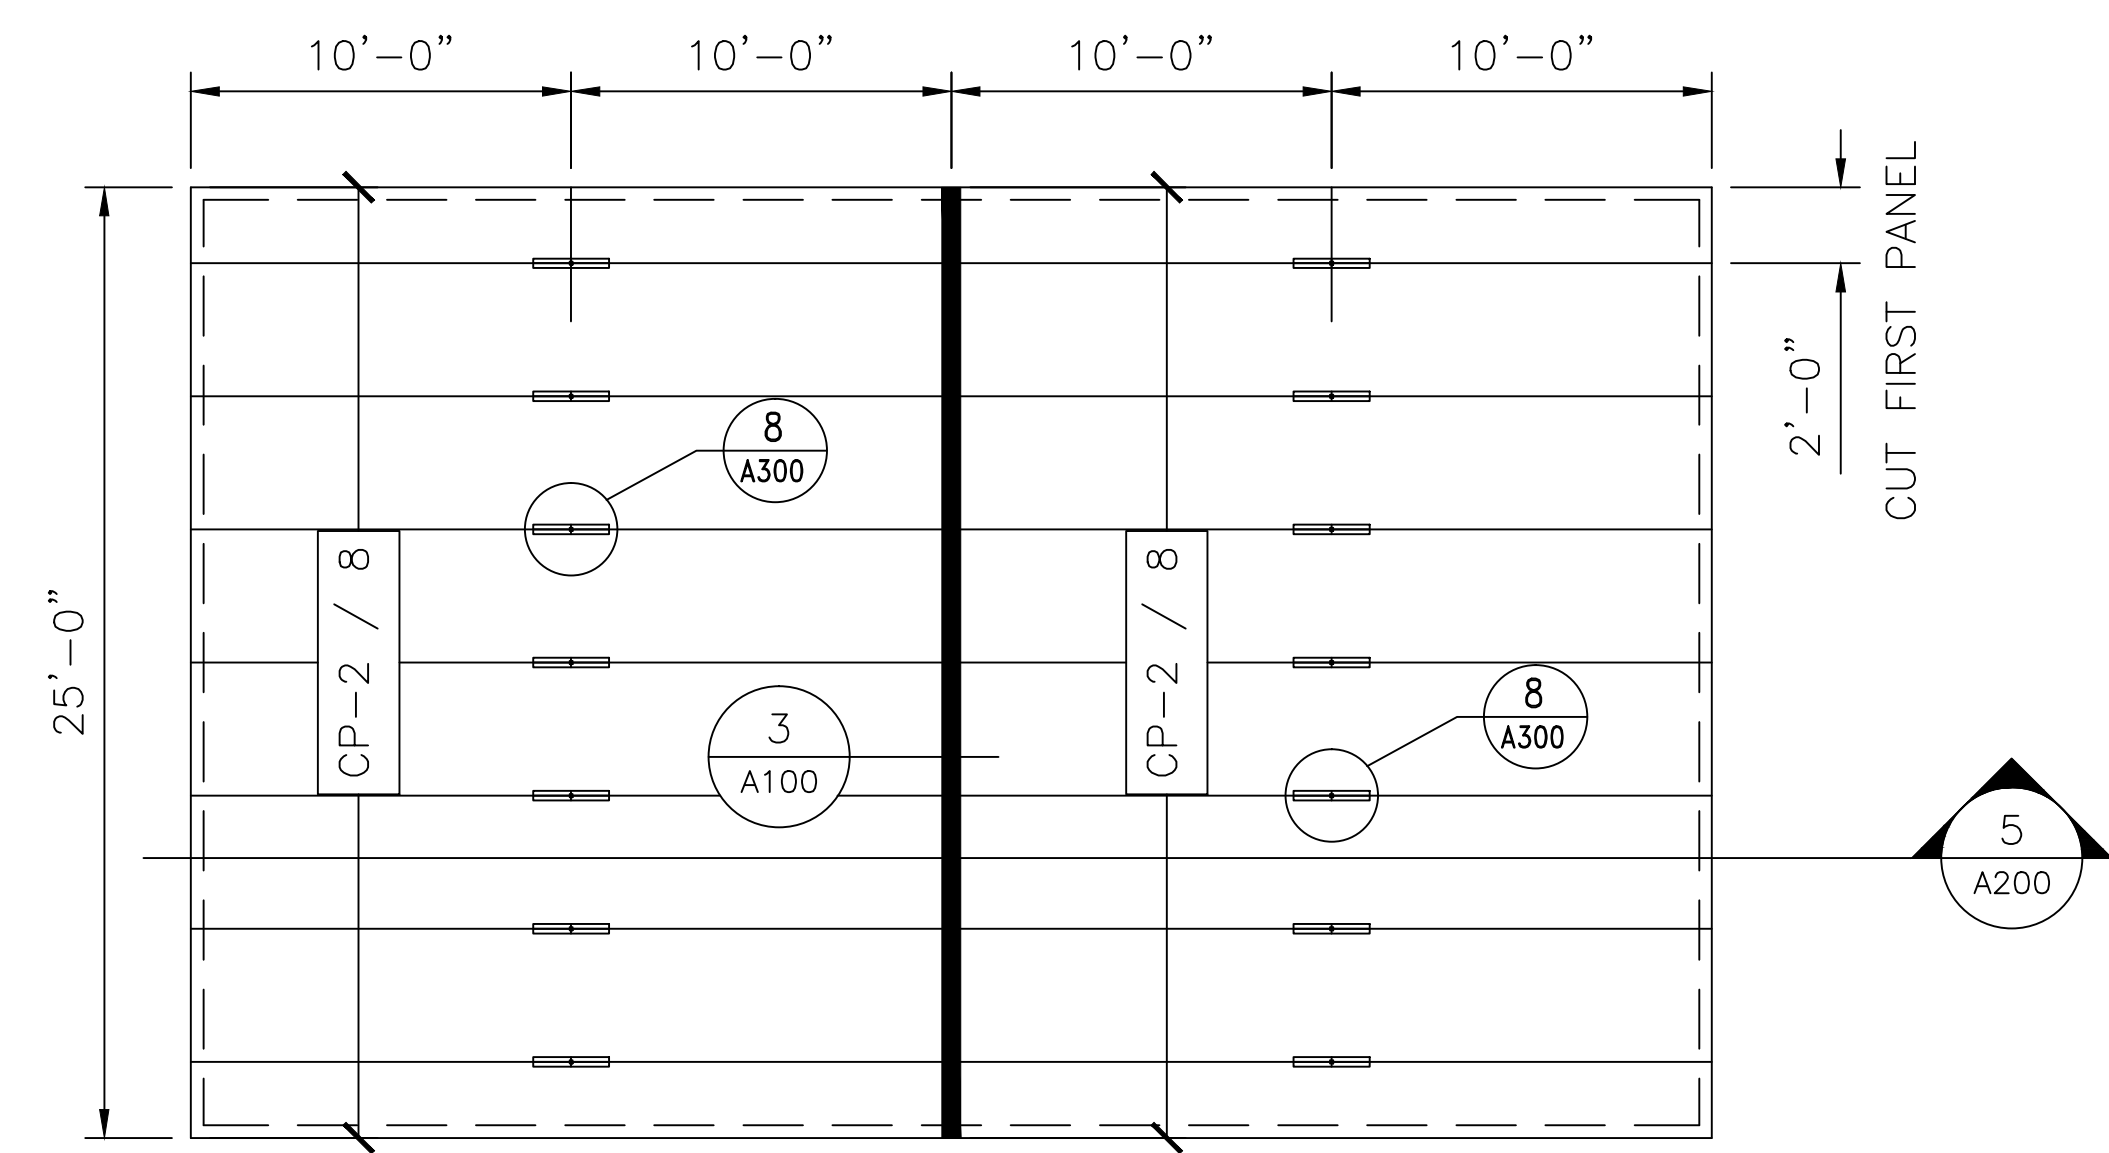

2 CEILING PLAN
A100 SCALE: N.T.S.

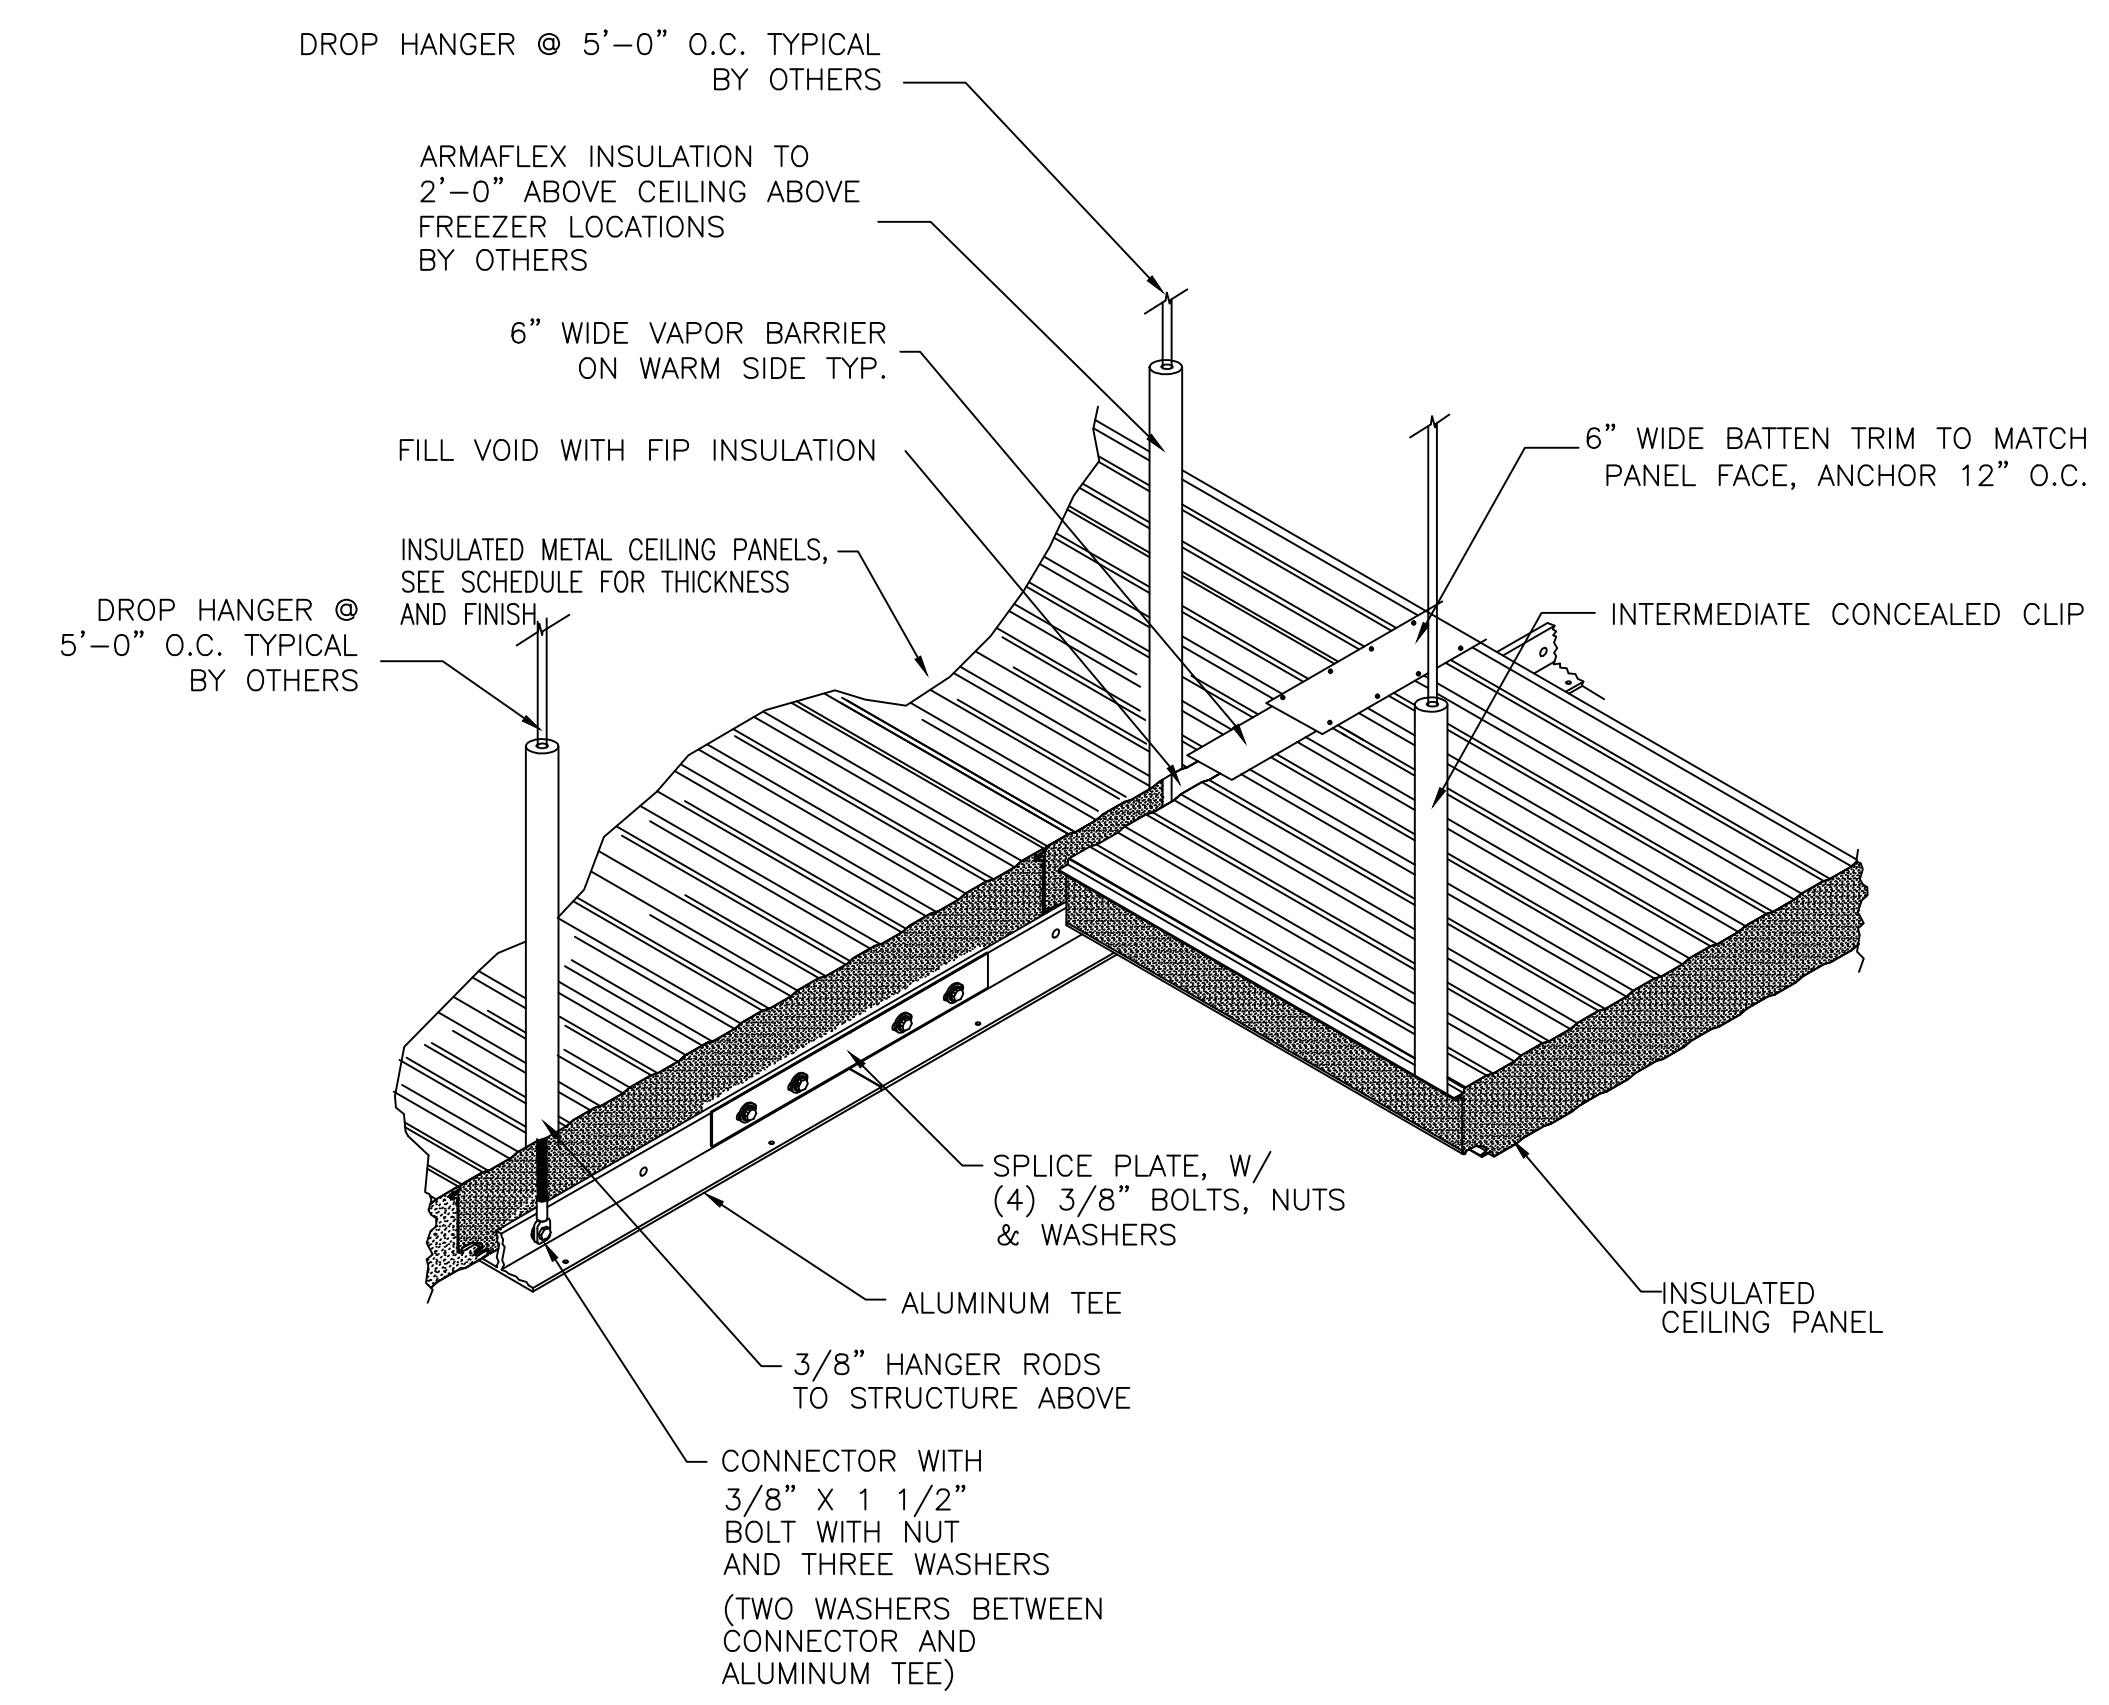

3 CEILING TEE DETAIL
A100 SCALE: N.T.S.

PANEL SCHEDULE

PANEL DESIG.	PANEL HEIGHT	QTY OF PANELS	PANEL THICK	PANEL SERIES	PANEL COLOR
WP-1	10'-0"	40	4"	MESALINE	USDA WHITE
CP-2	20'-0"	16	4"	MESALINE	USDA WHITE

NO.	REVISION	DATE	BY

Barr Inc.
1423 Planeview Drive
Oshkosh, WI 54904
920-231-1711 Phone






25' x 40' x 10'-4"
Drive-In Cooler

TOLERANCES UNLESS SPECIFIED
FRACTIONAL DECIMAL ANGLE
X/X" ± 1/32" .XX ± .015 X° ± 0'30"
.XXX ± .005 XXX' ± 0'05"
.XXXX ± .001

Draftsman is not responsible for panel heights, quantities and/or dimensions. Contractor to verify all information.


FLOOR PLAN

DR. BY: KRZ
DATE: 10/13/2022
SCALE: NTS
CHECKED BY:
SHEET NO. A100

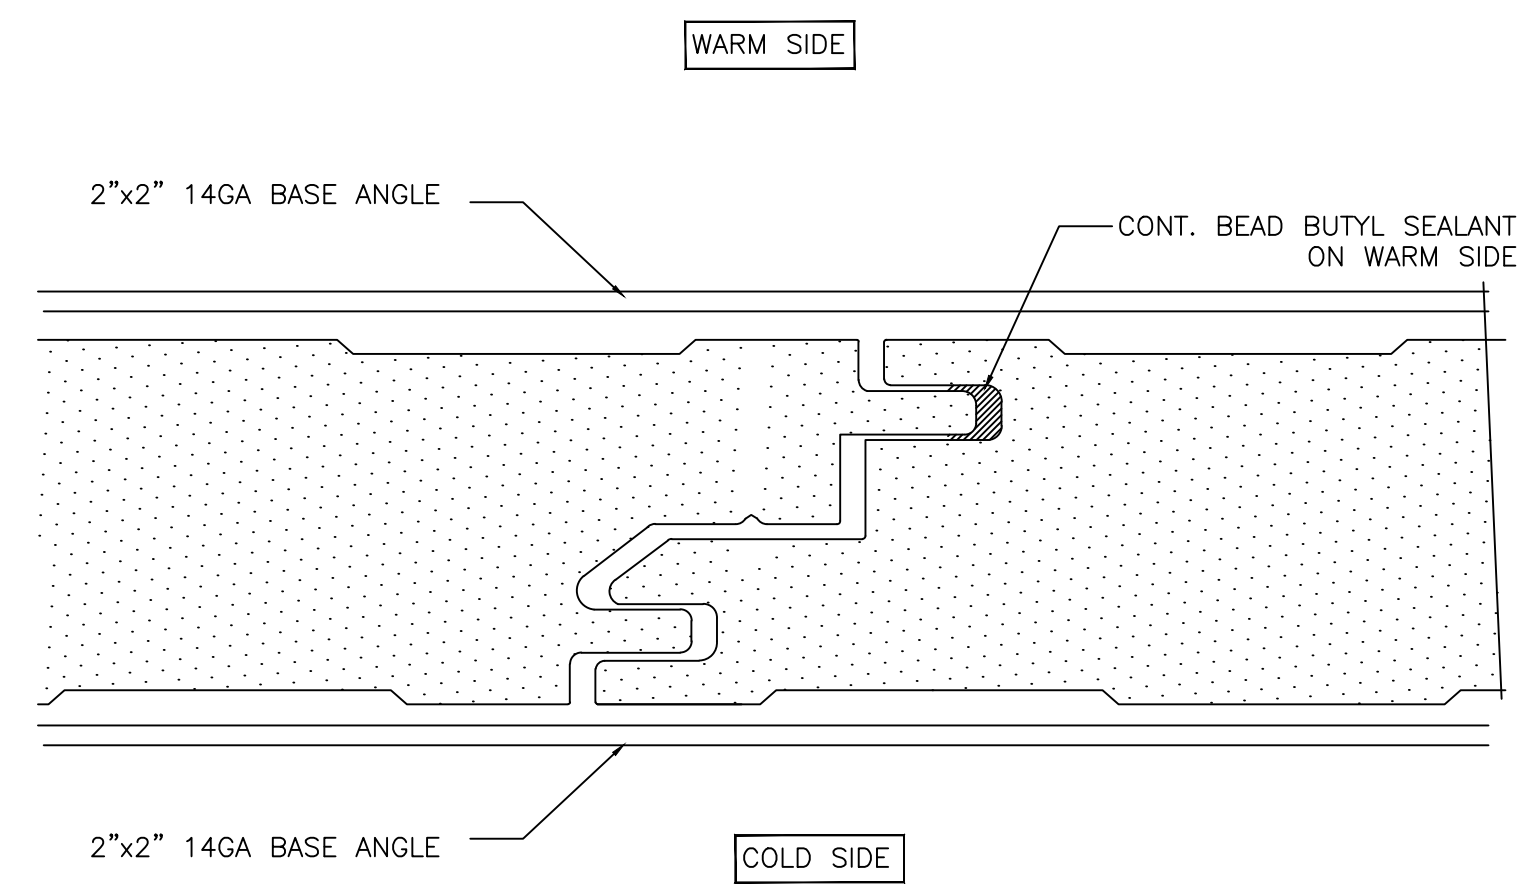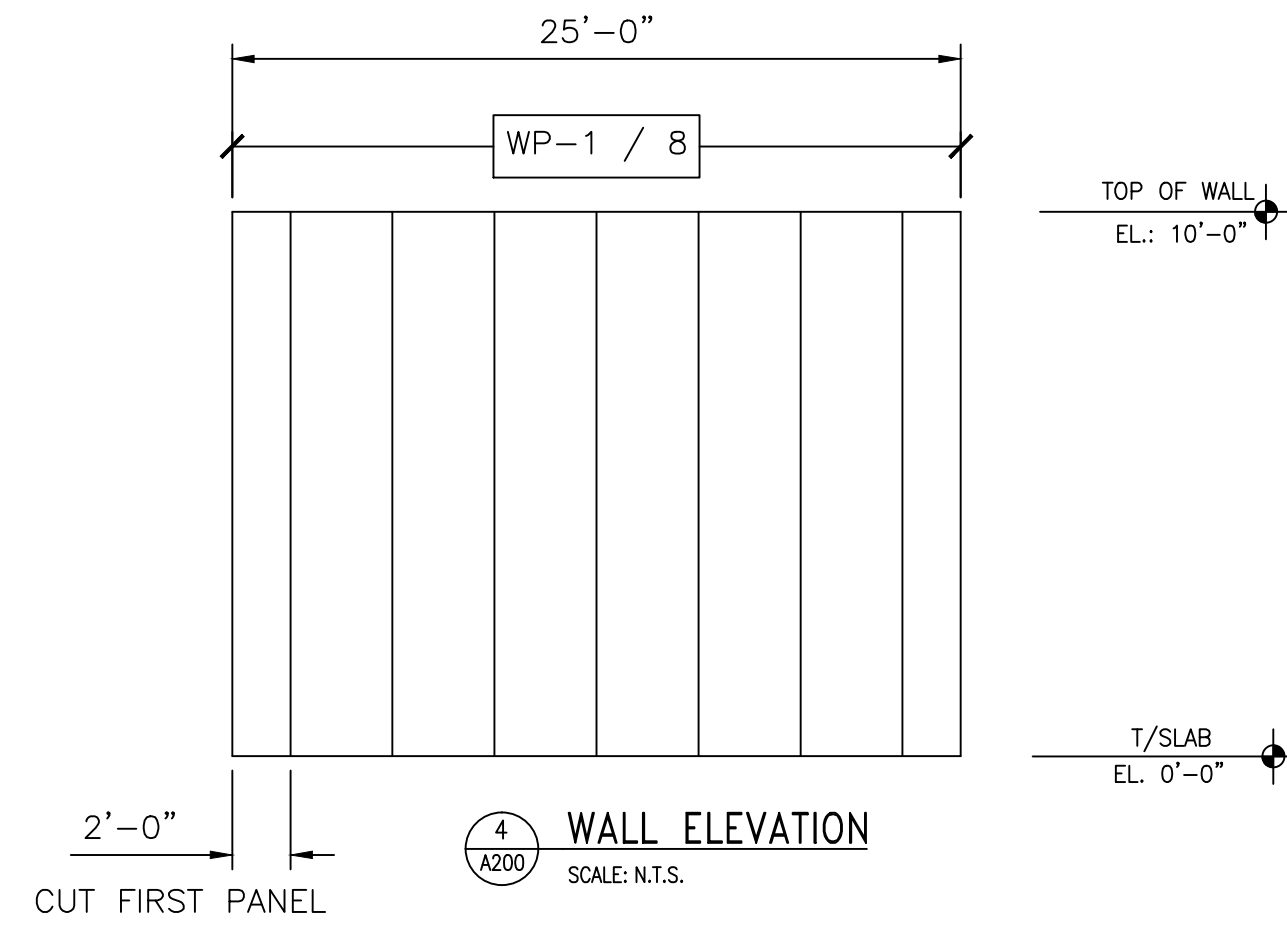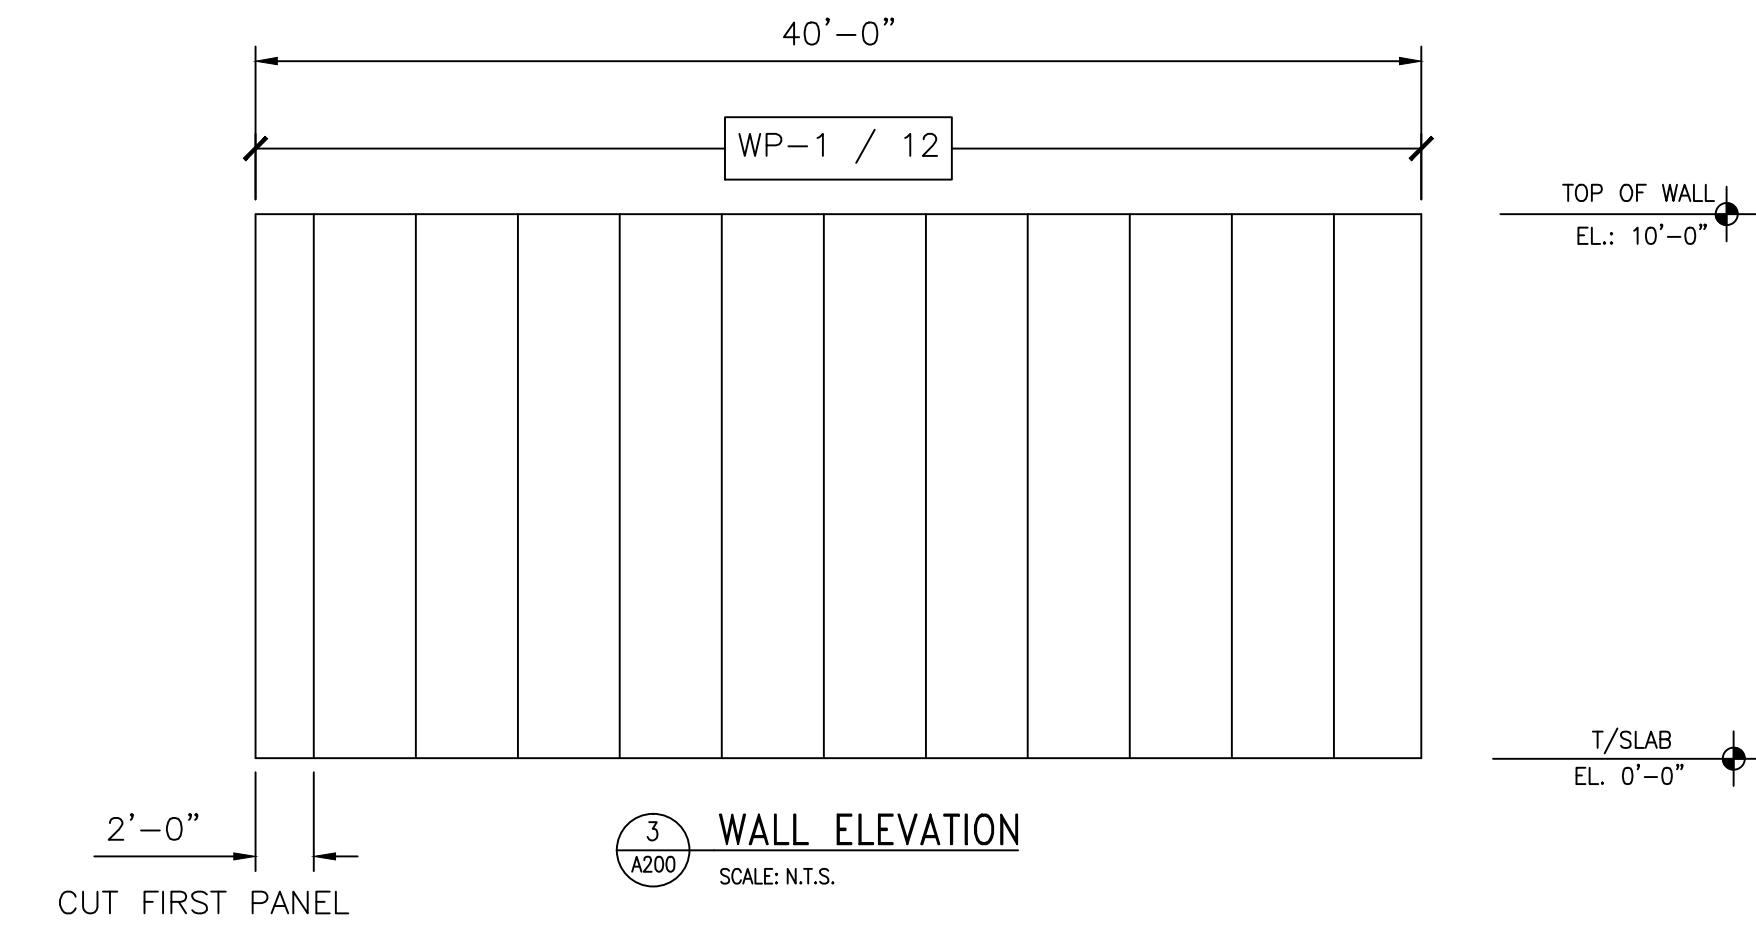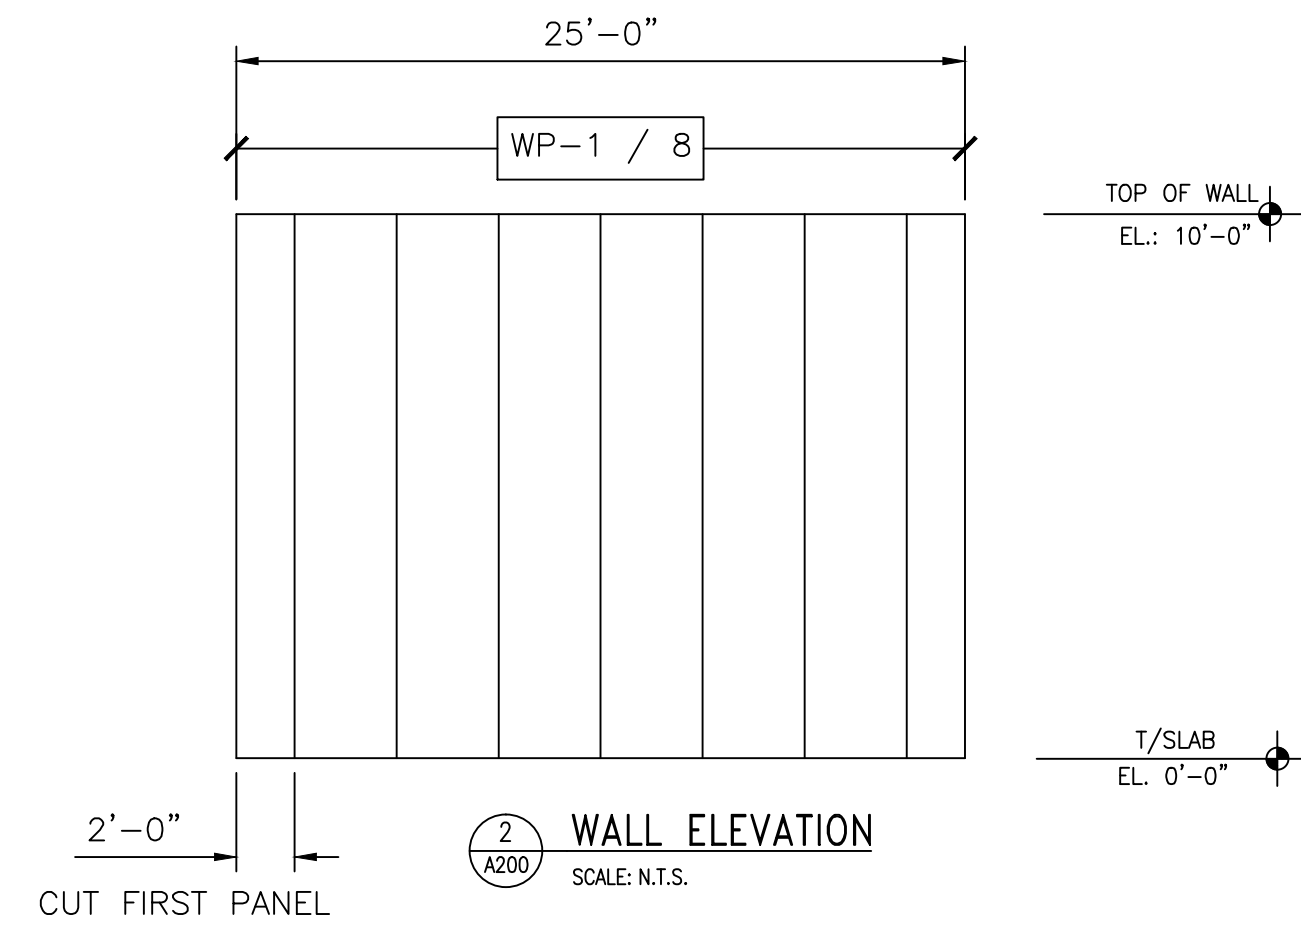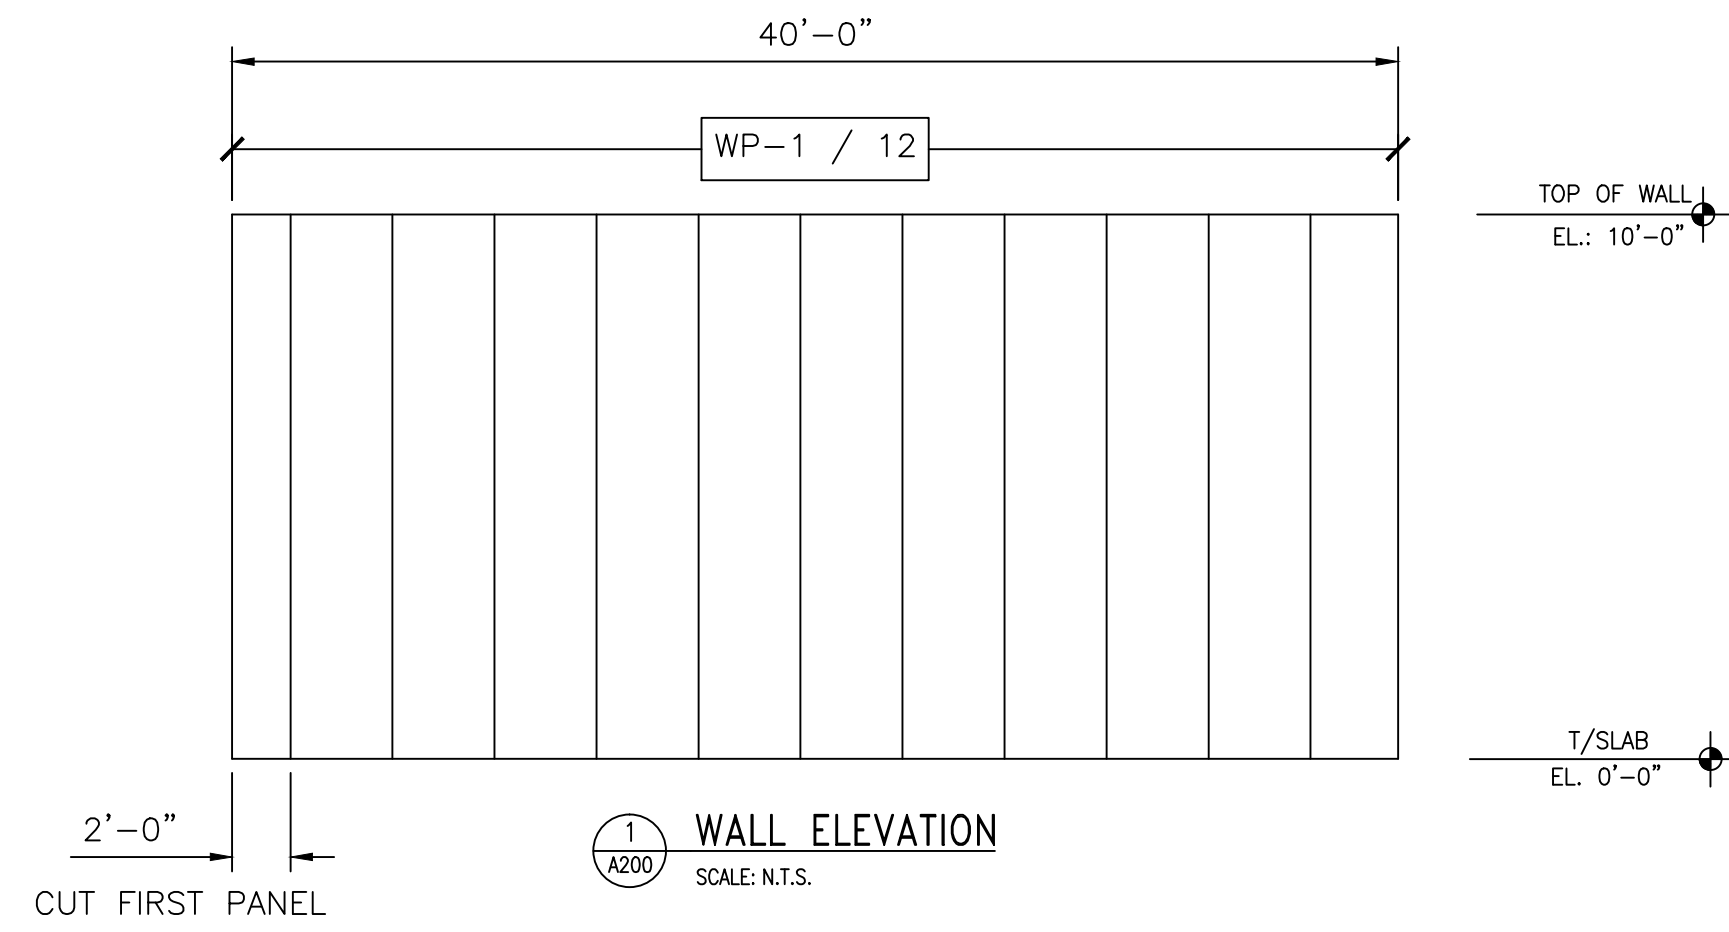

PANEL SCHEDULE

PANEL DESIG.	PANEL HEIGHT	QTY. OF PANELS	PANEL THICK	PANEL SERIES	PANEL COLOR
WP-1	10'-0"	40	4"	MESALINE	USDA WHITE
CP-2	20'-0"	16	4"	MESALINE	USDA WHITE

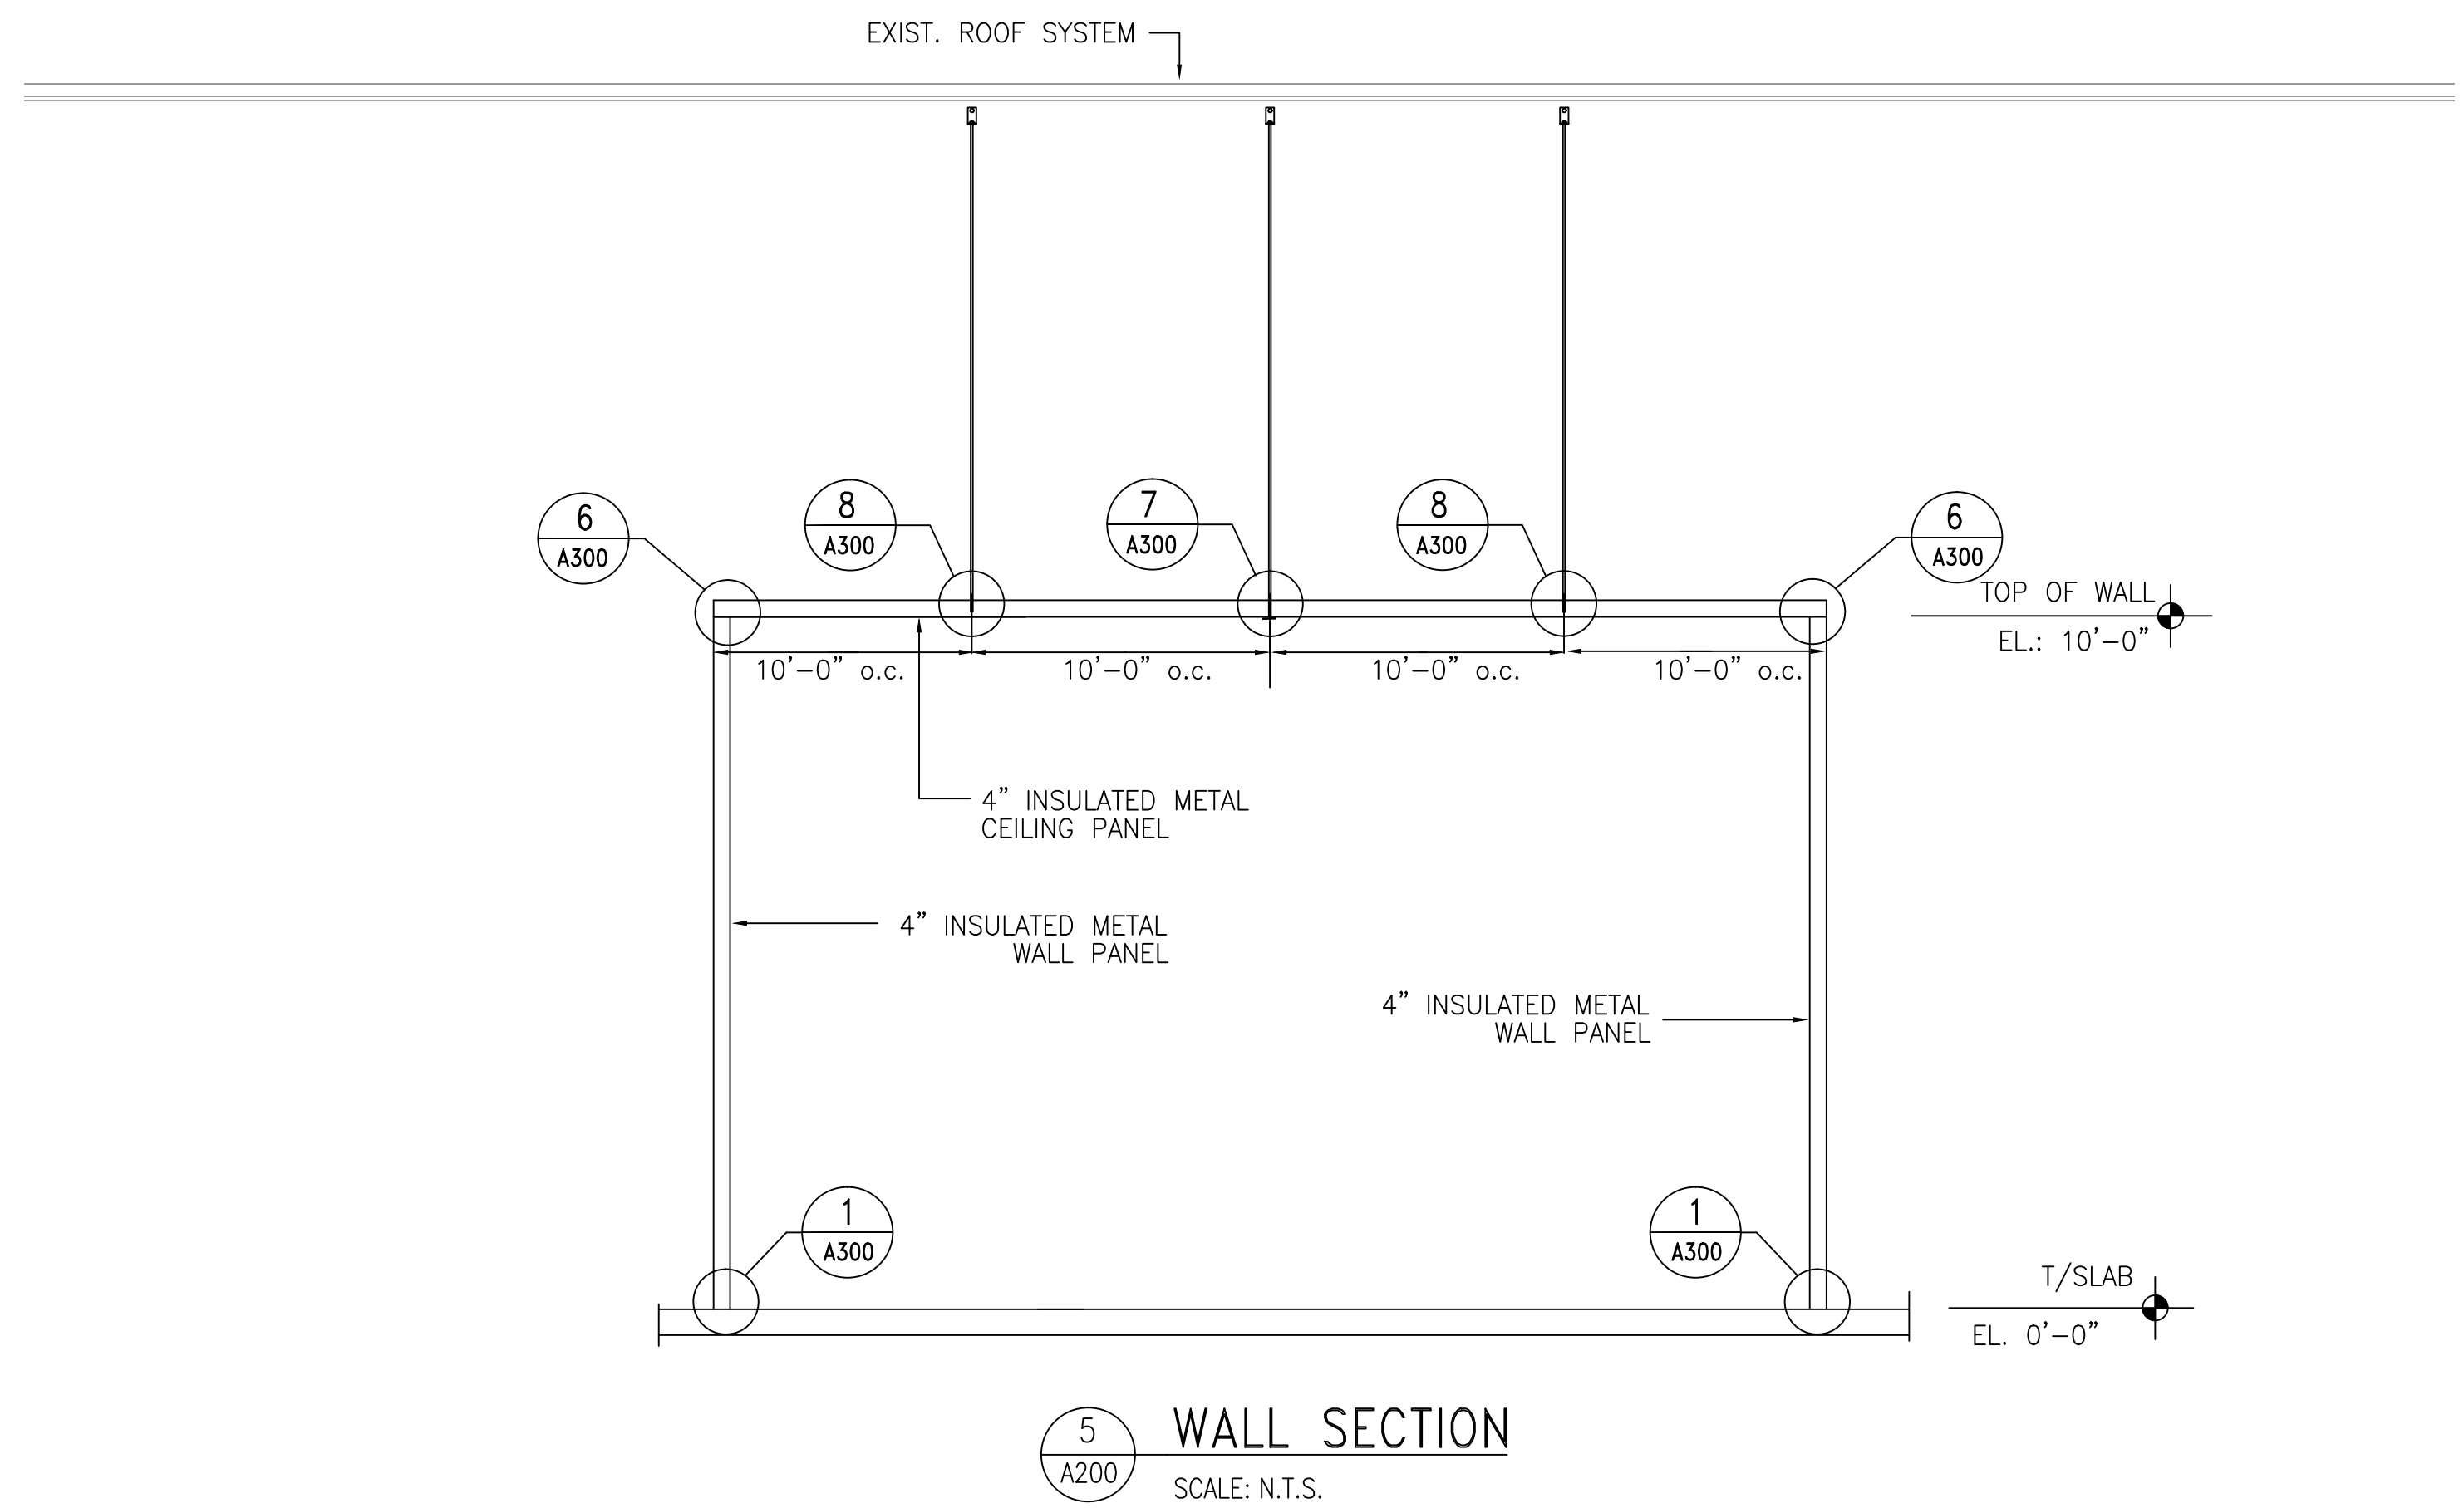

NO.	REVISION	DATE	BY


Barr Inc.
1423 Planeview Drive
Oshkosh, WI 54904
920-231-1711 Phone

25' x 40' x 10'-4"
Drive-In Cooler


TOLERANCES UNLESS SPECIFIED
FRACTIONAL .XX ± 1/32"
DECIMAL .015 X ± 0.30"
ANGLE .XXX ± .005
XXX ± .001
XXXX ± .001
Draftsman is not responsible for panel heights, quantities and/or dimensions. Contractor to verify all information.

WALL ELEVATIONS


DR. BY: KRZ
DATE: 10/13/2022
SCALE: NTS
CHECKED BY:
SHEET NO. A200

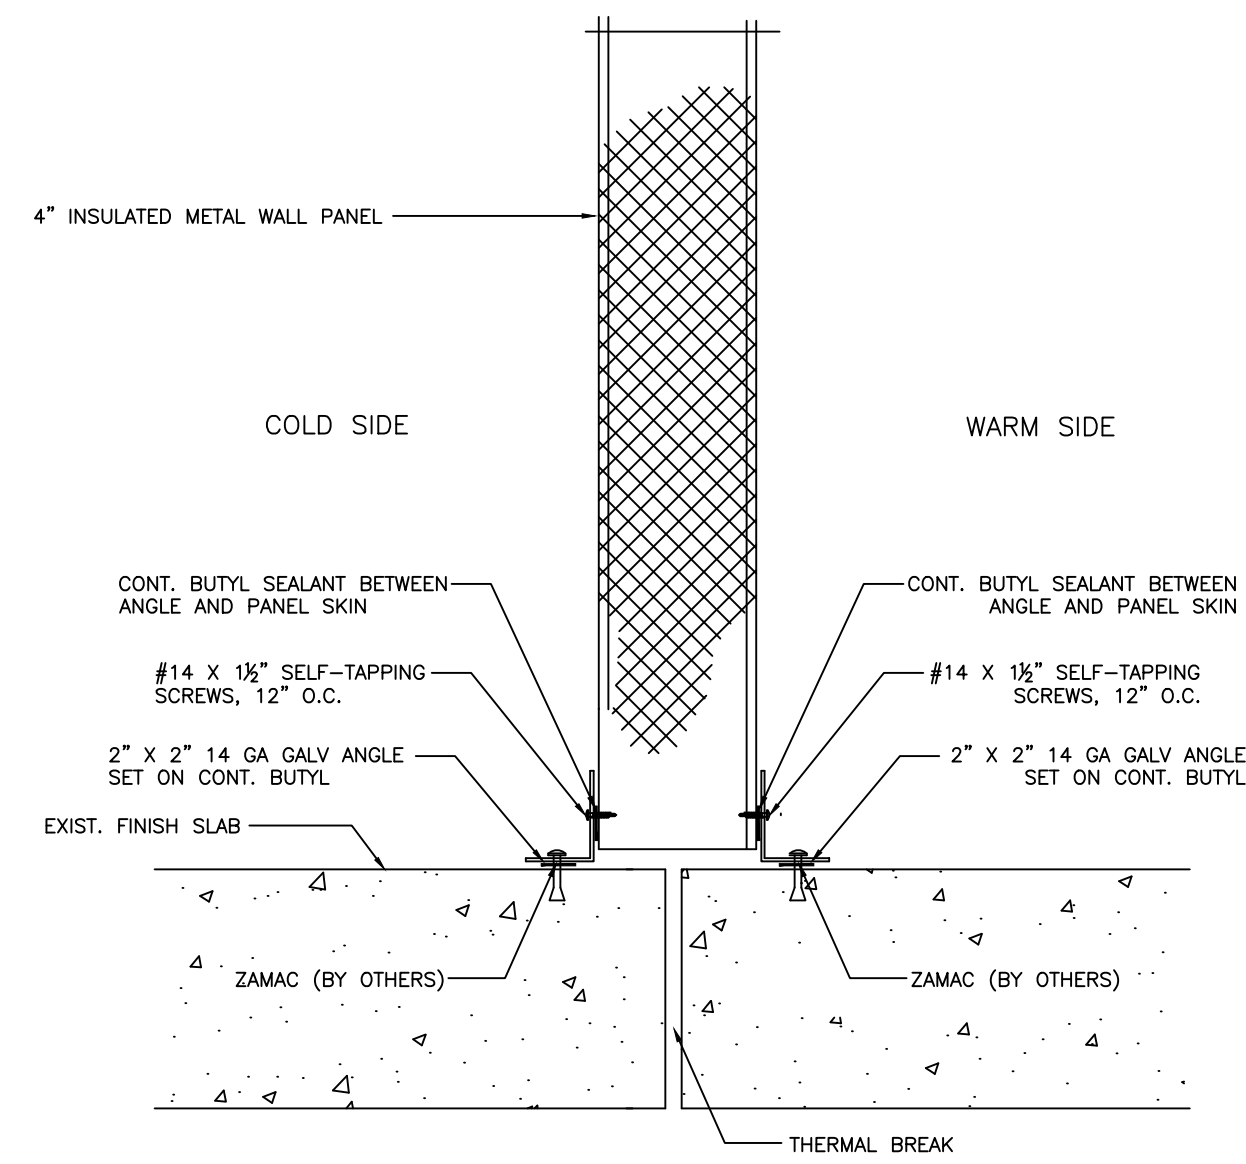


1 BASE DETAIL
A300

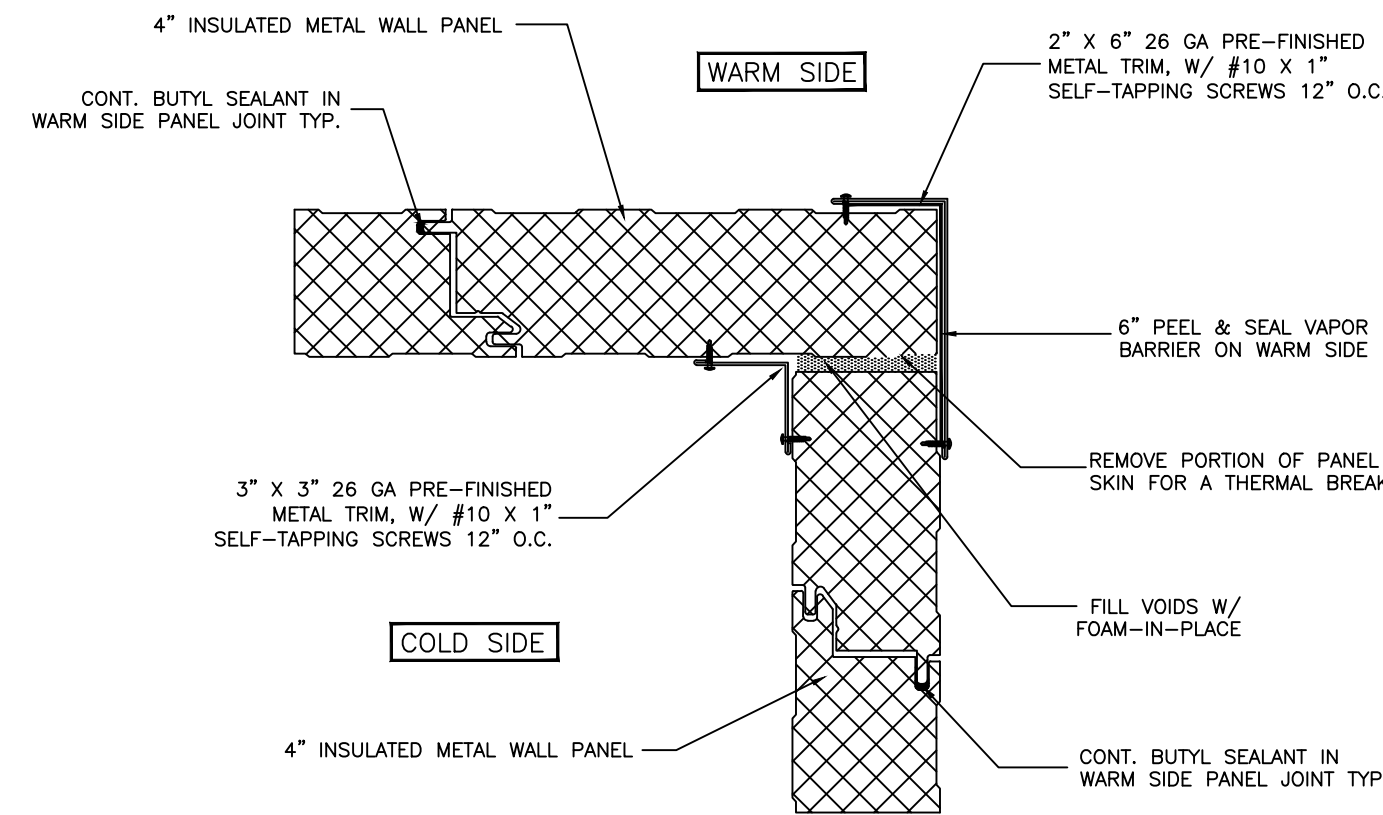


2 CORNER DETAIL
A300

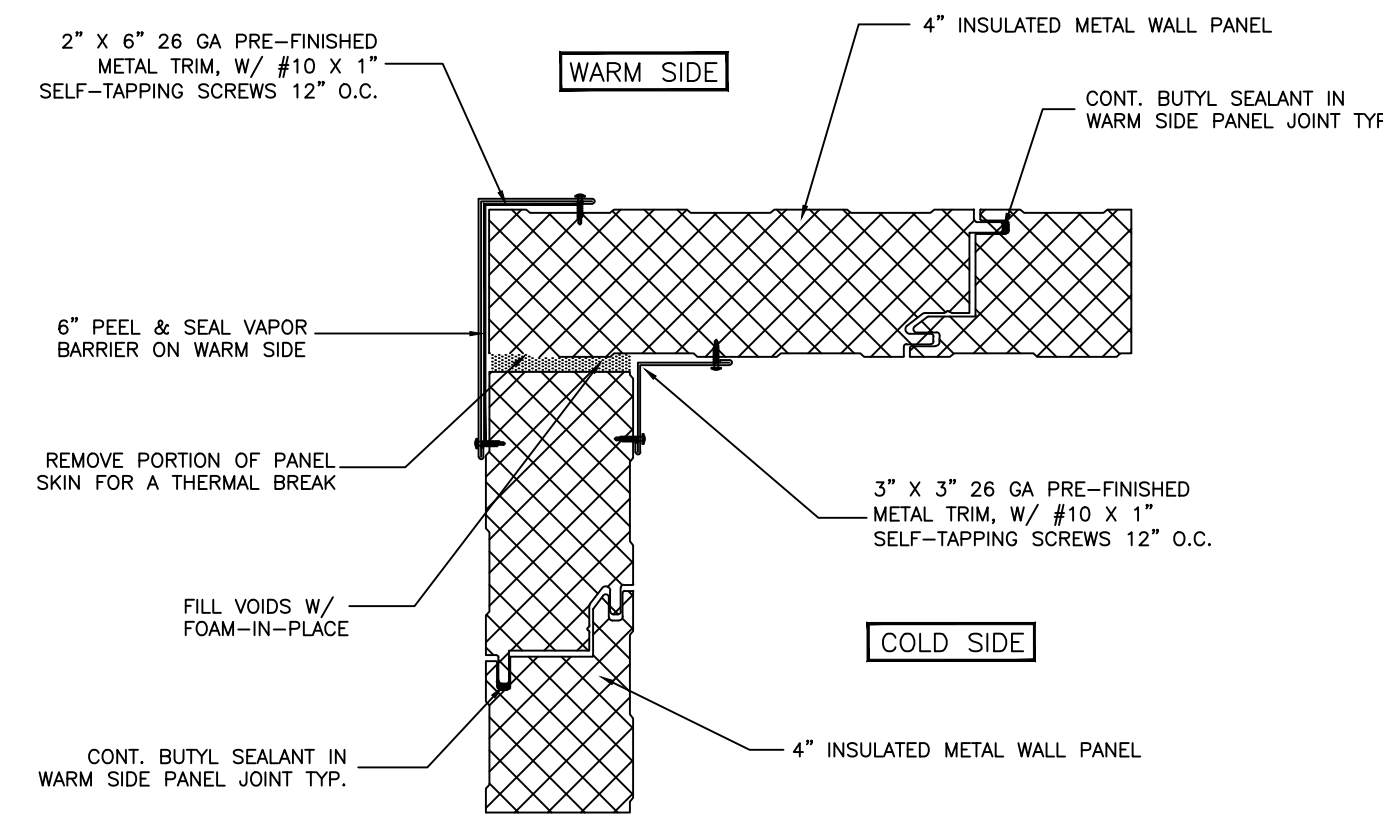


3 CORNER DETAIL
A300

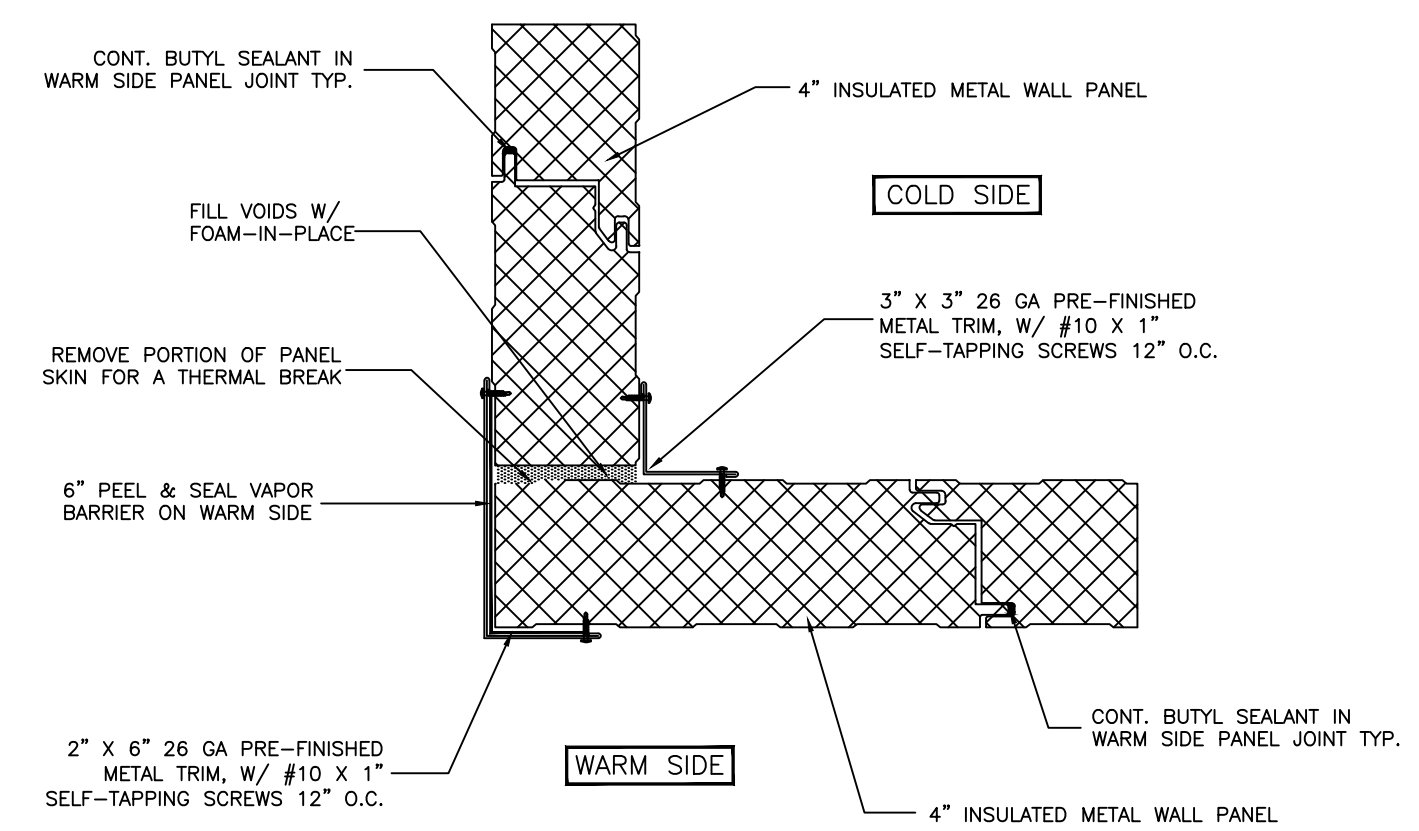


4 CORNER DETAIL
A300

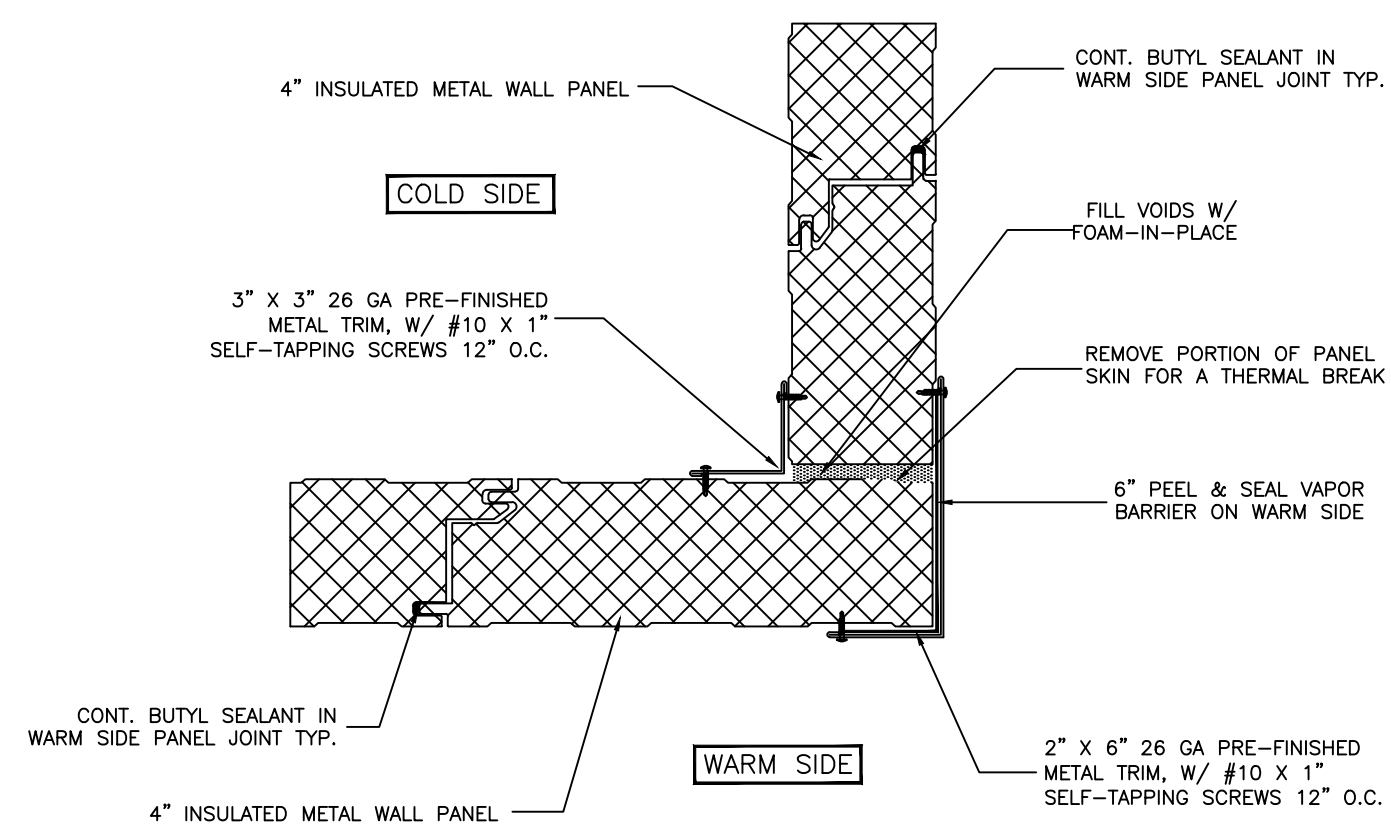


5 CORNER DETAIL
A300

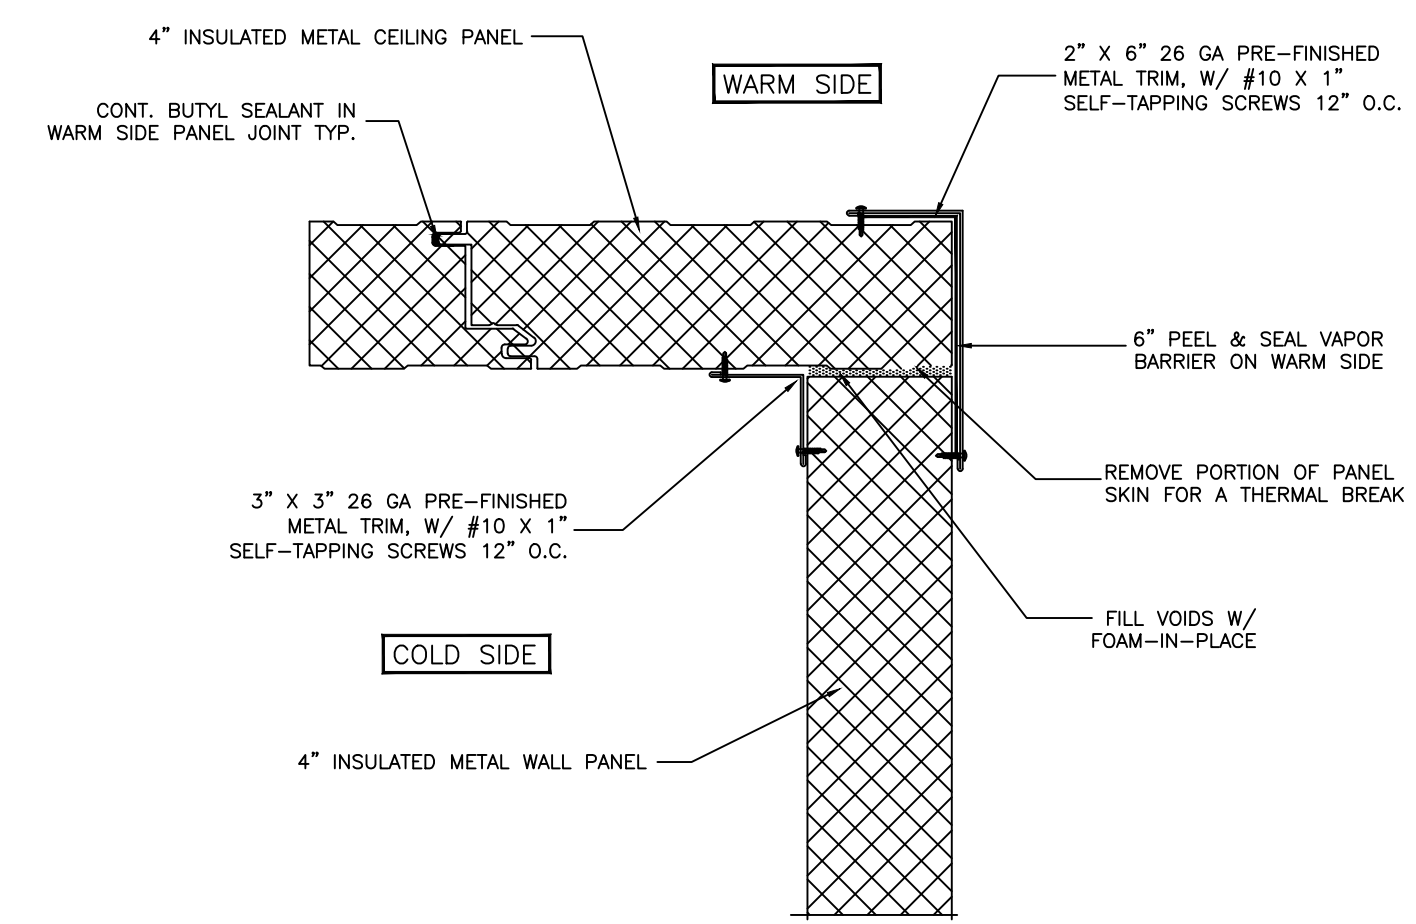

6 WALL / CEILING DETAIL
A300

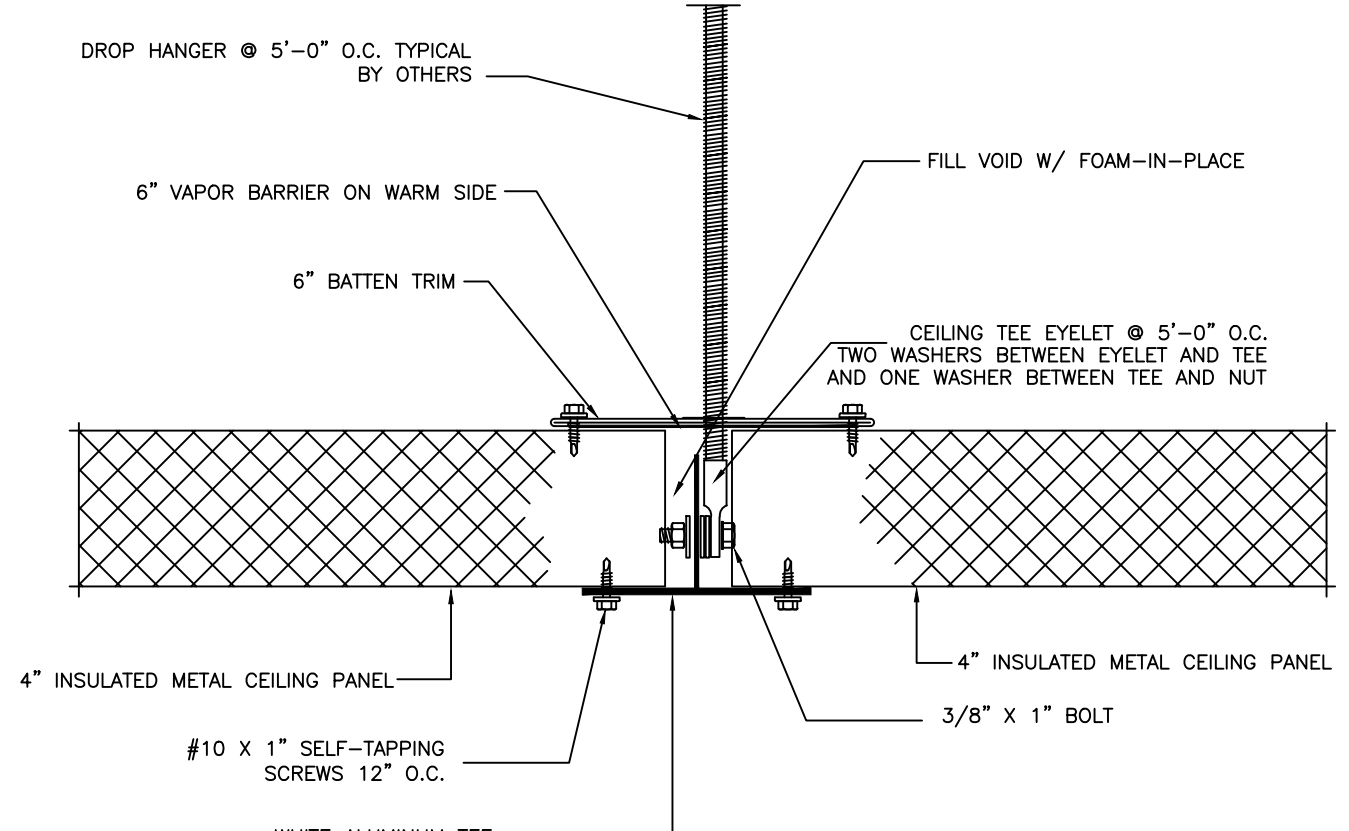

7 CEILING TEE DETAIL
A300

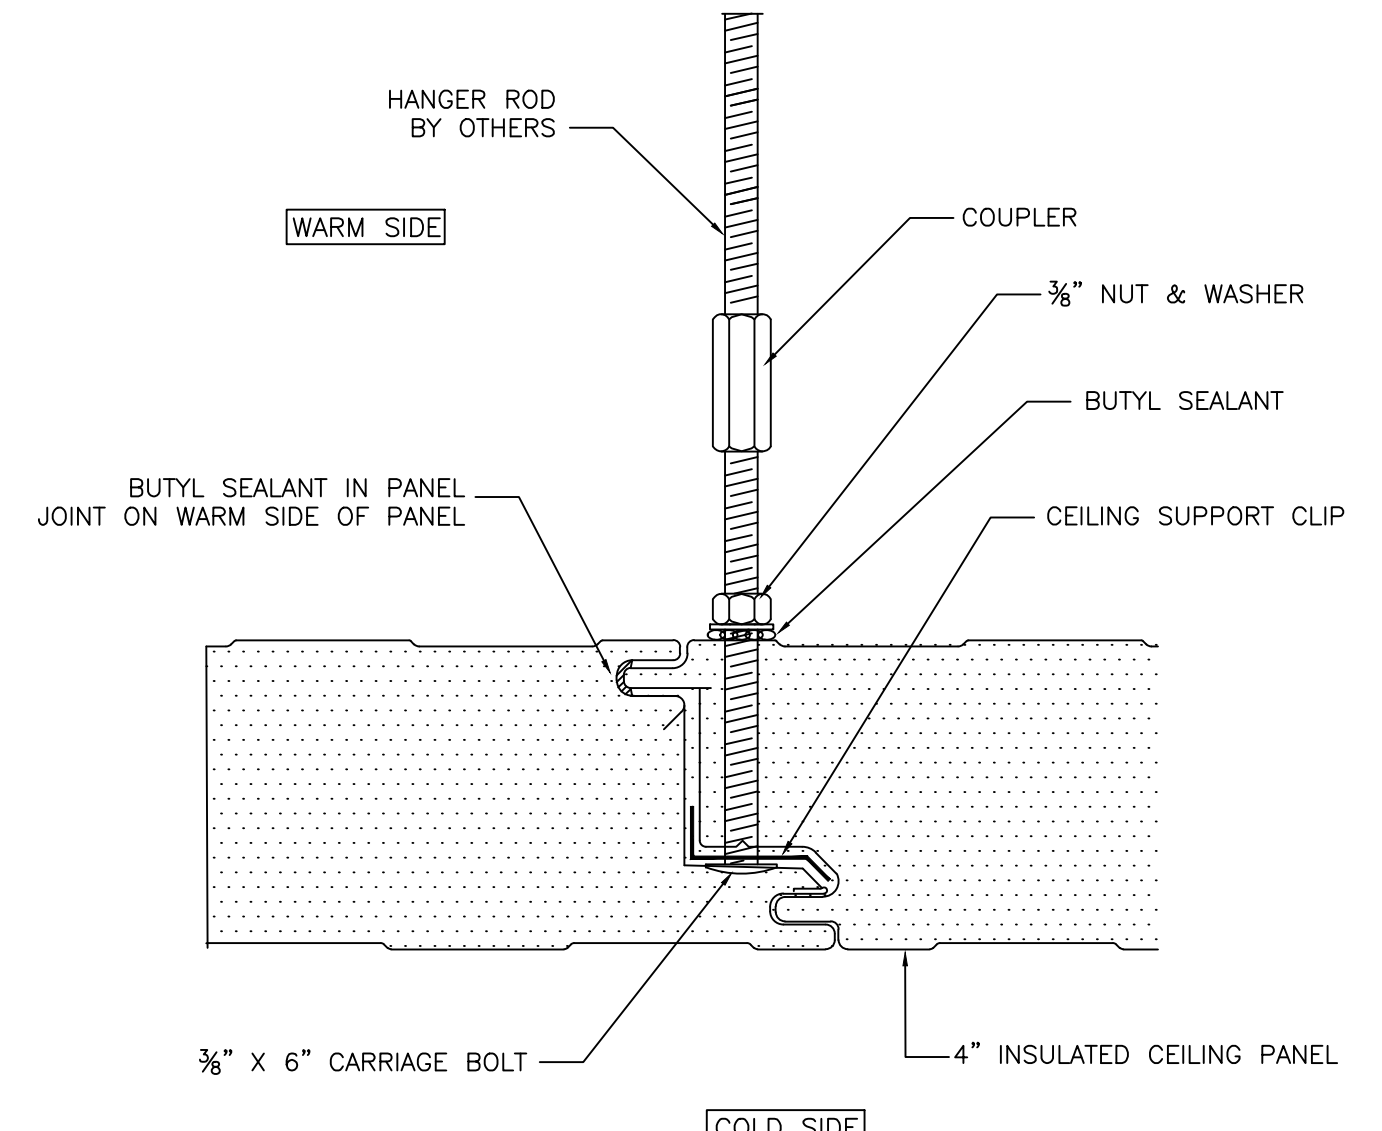

8 INTERMEDIATE CEILING SUPPORT
A300

NO.	REVISION	BY	DATE

Barr Inc.
1423 Planeview Drive
Oshkosh, WI 54904
920-231-1711 Phone

25' x 40' x 10'-4"
Drive-In Cooler

TOLERANCES UNLESS SPECIFIED
FRACTIONAL DECIMAL .015 X' ANGLE
X/X" ± 1/32" .XX ± .05 X'X' ± 0'05"
.XXX ± .005 X'X' ± 0'05"
.XXXX ± .001

Draftsman is not responsible for panel heights, quantities, and/or dimensions. Contractor to verify all information.

WALL DETAILS

DR. BY: KRZ
DATE: 10/13/2022
SCALE: NTS
CHECKED BY:
SHEET NO. A300